

Consultant
 CIVIL ENGINEER
 SMART ENGINEERS Associates, Inc.
 278 Main Street, Suite 806
 Providence, RI 02903
 Phone: (401) 772-1121
 Fax: (401) 879-0886

Consultant
 MECHANICAL/ELECTRICAL ENGINEER
 BIRD, ROE & ATHONS Consulting Engineers, LLC
 311 Arsenal Street, Corcoran
 Middletown, MA 02047-5799
 Phone: (508) 833-1100
 Fax: (508) 772-1070

Consultant
 EQUIPMENT PLANNING
 GARDNER, BURNETT & ASSOCIATES
 144 Fore Street P.O. Box 618
 Providence, RI 02903
 Phone: (401) 772-3846
 Fax: (401) 772-1070

Consultant
 CONSTRUCTION MANAGER
 PROVIDENCE PROJECT GROUP
 7 Jackson Walkway
 Providence, Rhode Island 02903
 Phone: (401) 458-5516
 Fax: (401) 458-5516

Consultant
 FOOD SERVICE
 FOOD SERVICE, LLC
 1808 West End Ave, Suite 1400
 Providence, RI 02903
 Phone: (401) 321-5591
 Fax: (401) 321-5689

It is the responsibility of the Construction Manager/General Contractor and all subcontractors to verify all scope and exact conditions of prior work by related trades before proceeding with any work.

Date: CORE & SHELL ISSUED 10.02.06 FOR CONSTRUCTION
 Drawn By: MAF/JUL/CLB/CLV/LMS
 Scale: AS NOTED

Francis

Caufman

Roley

Hoffmann


Francis Cauffman
 Foley Hoffmann
 Architects Ltd.
 2120 Acorn Street
 Philadelphia, PA 19103
 Phone: 215-568-8250

Project Title
 Mercy Health
 System of Maine
 FORE RIVER SHORT
 STAY HOSPITAL




Project Number: F05-4898
 Drawing Title and Number: Entrance Canopy Plan
 & Elevations


A1.08

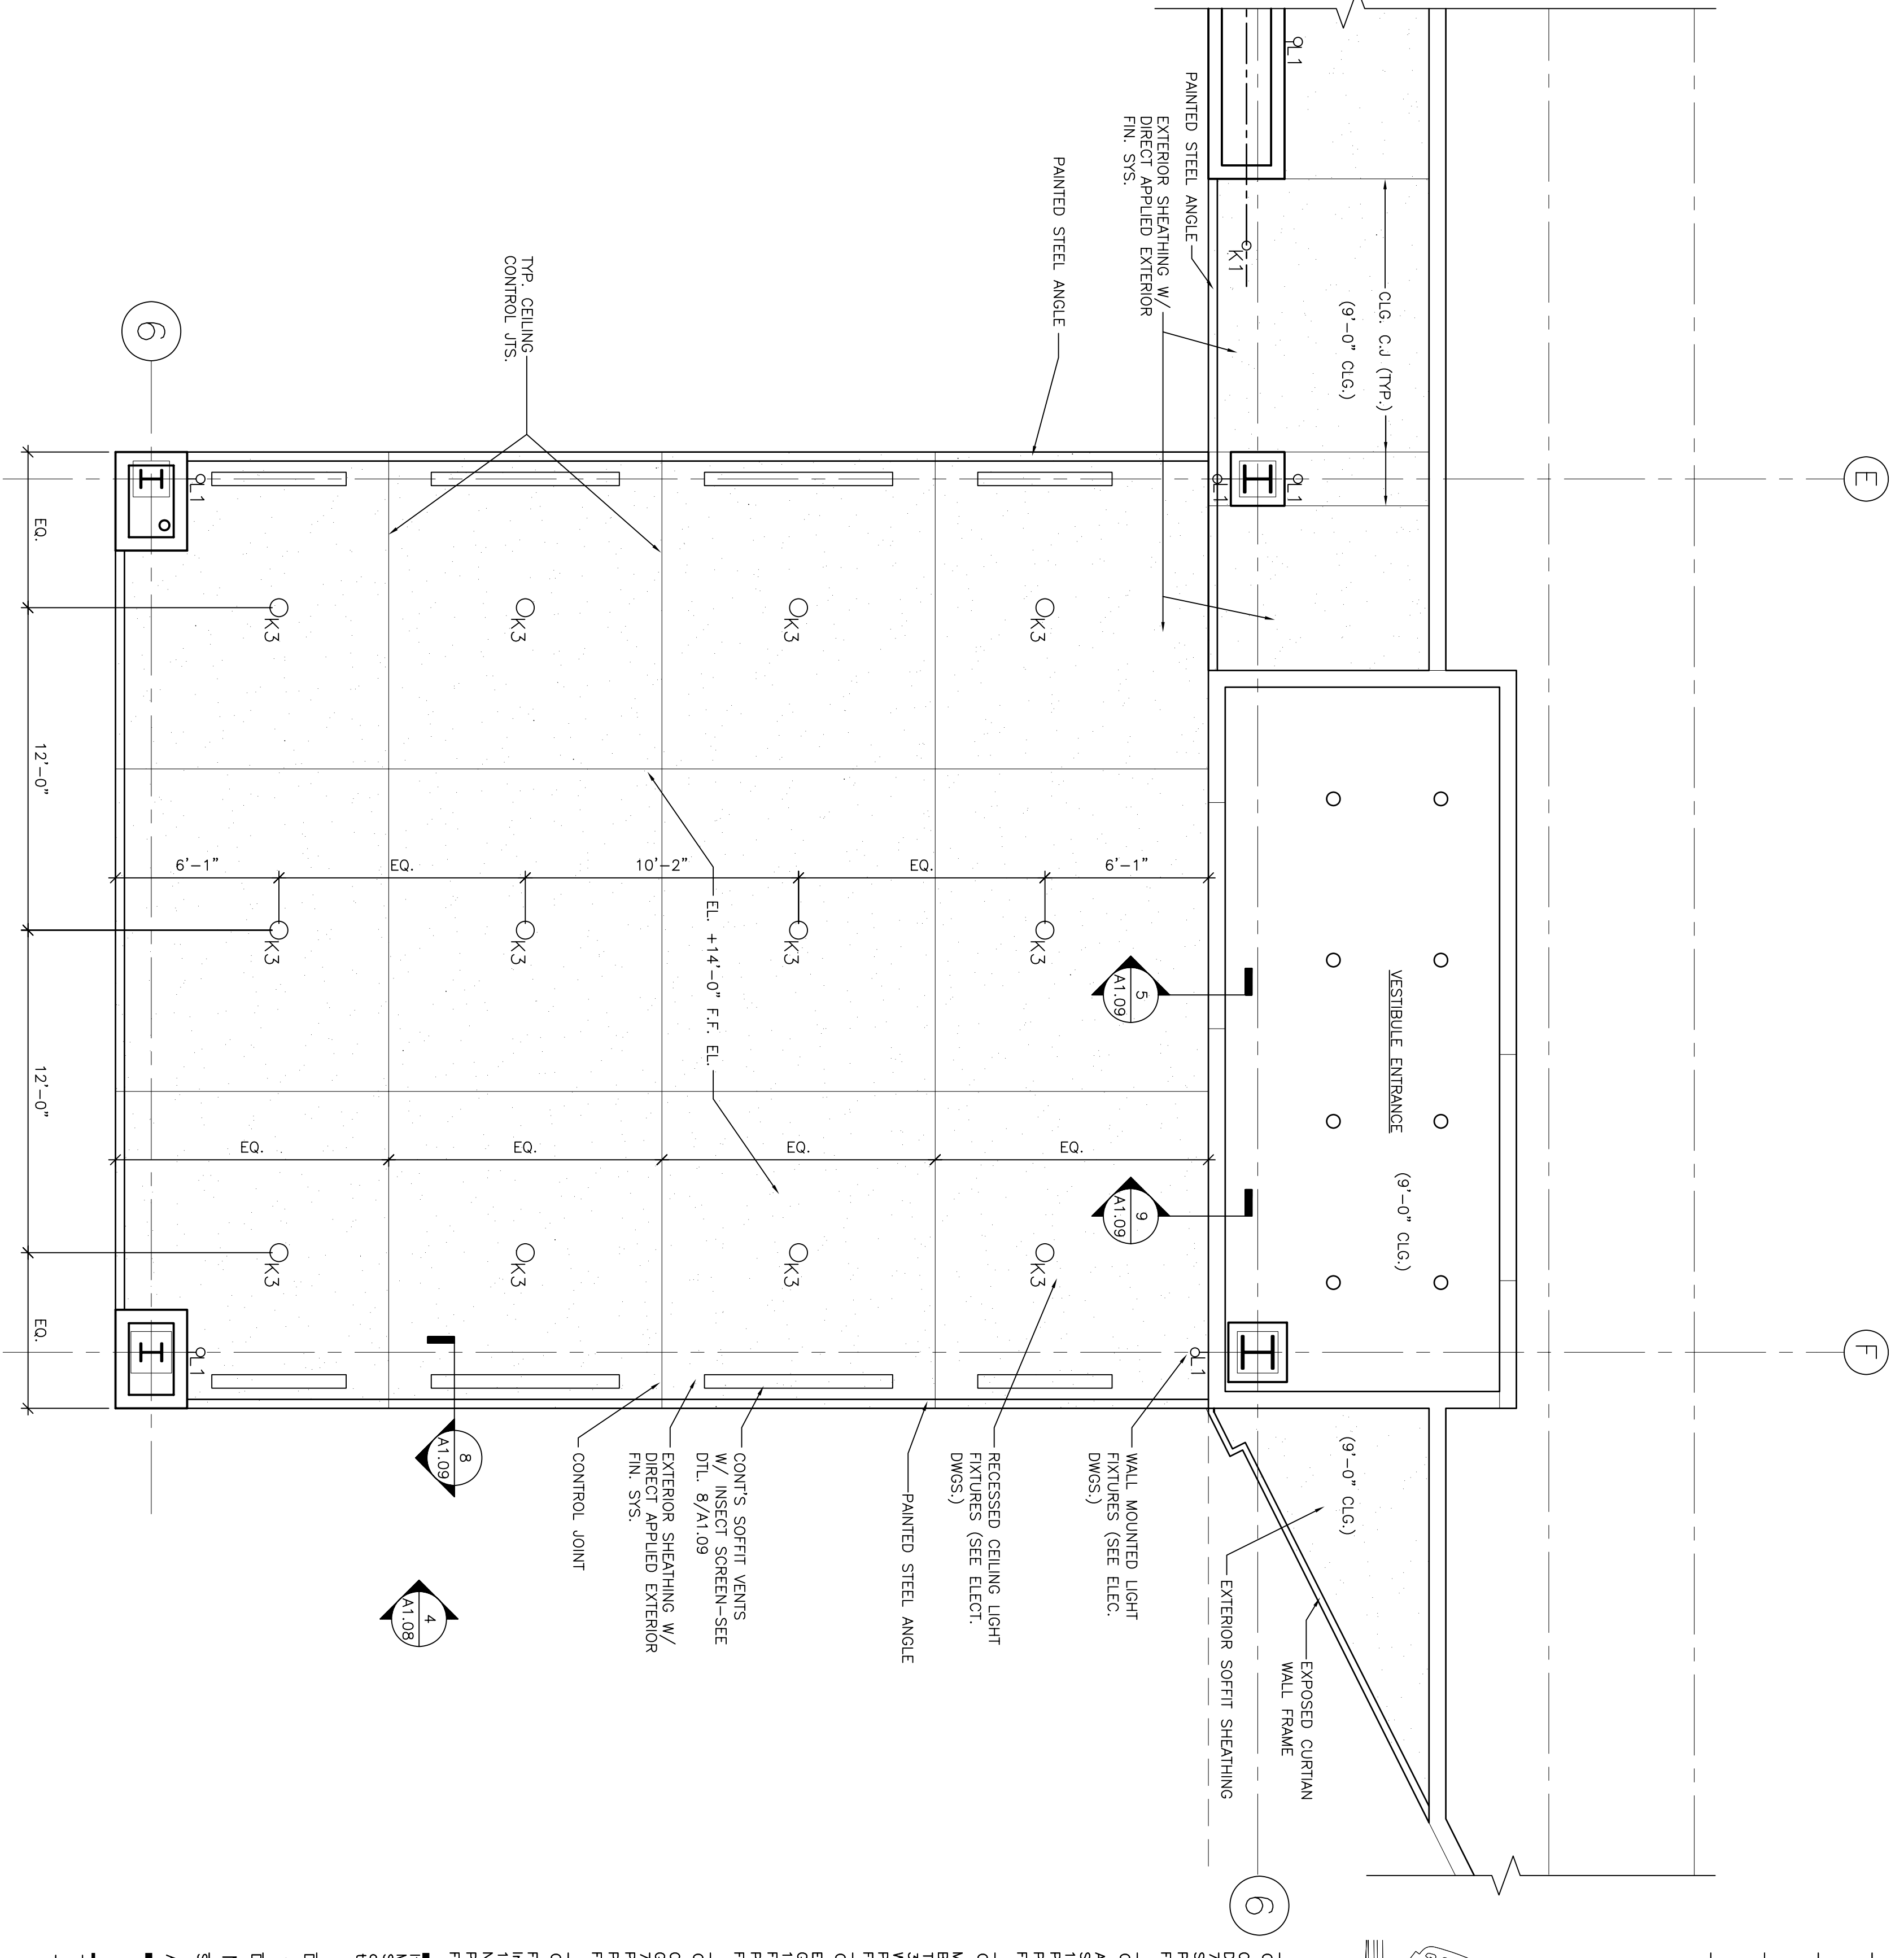


3 ENTRANCE CANOPY - REFLECTED CEILING PLAN
 SCALE: 1/4"=1'-0"

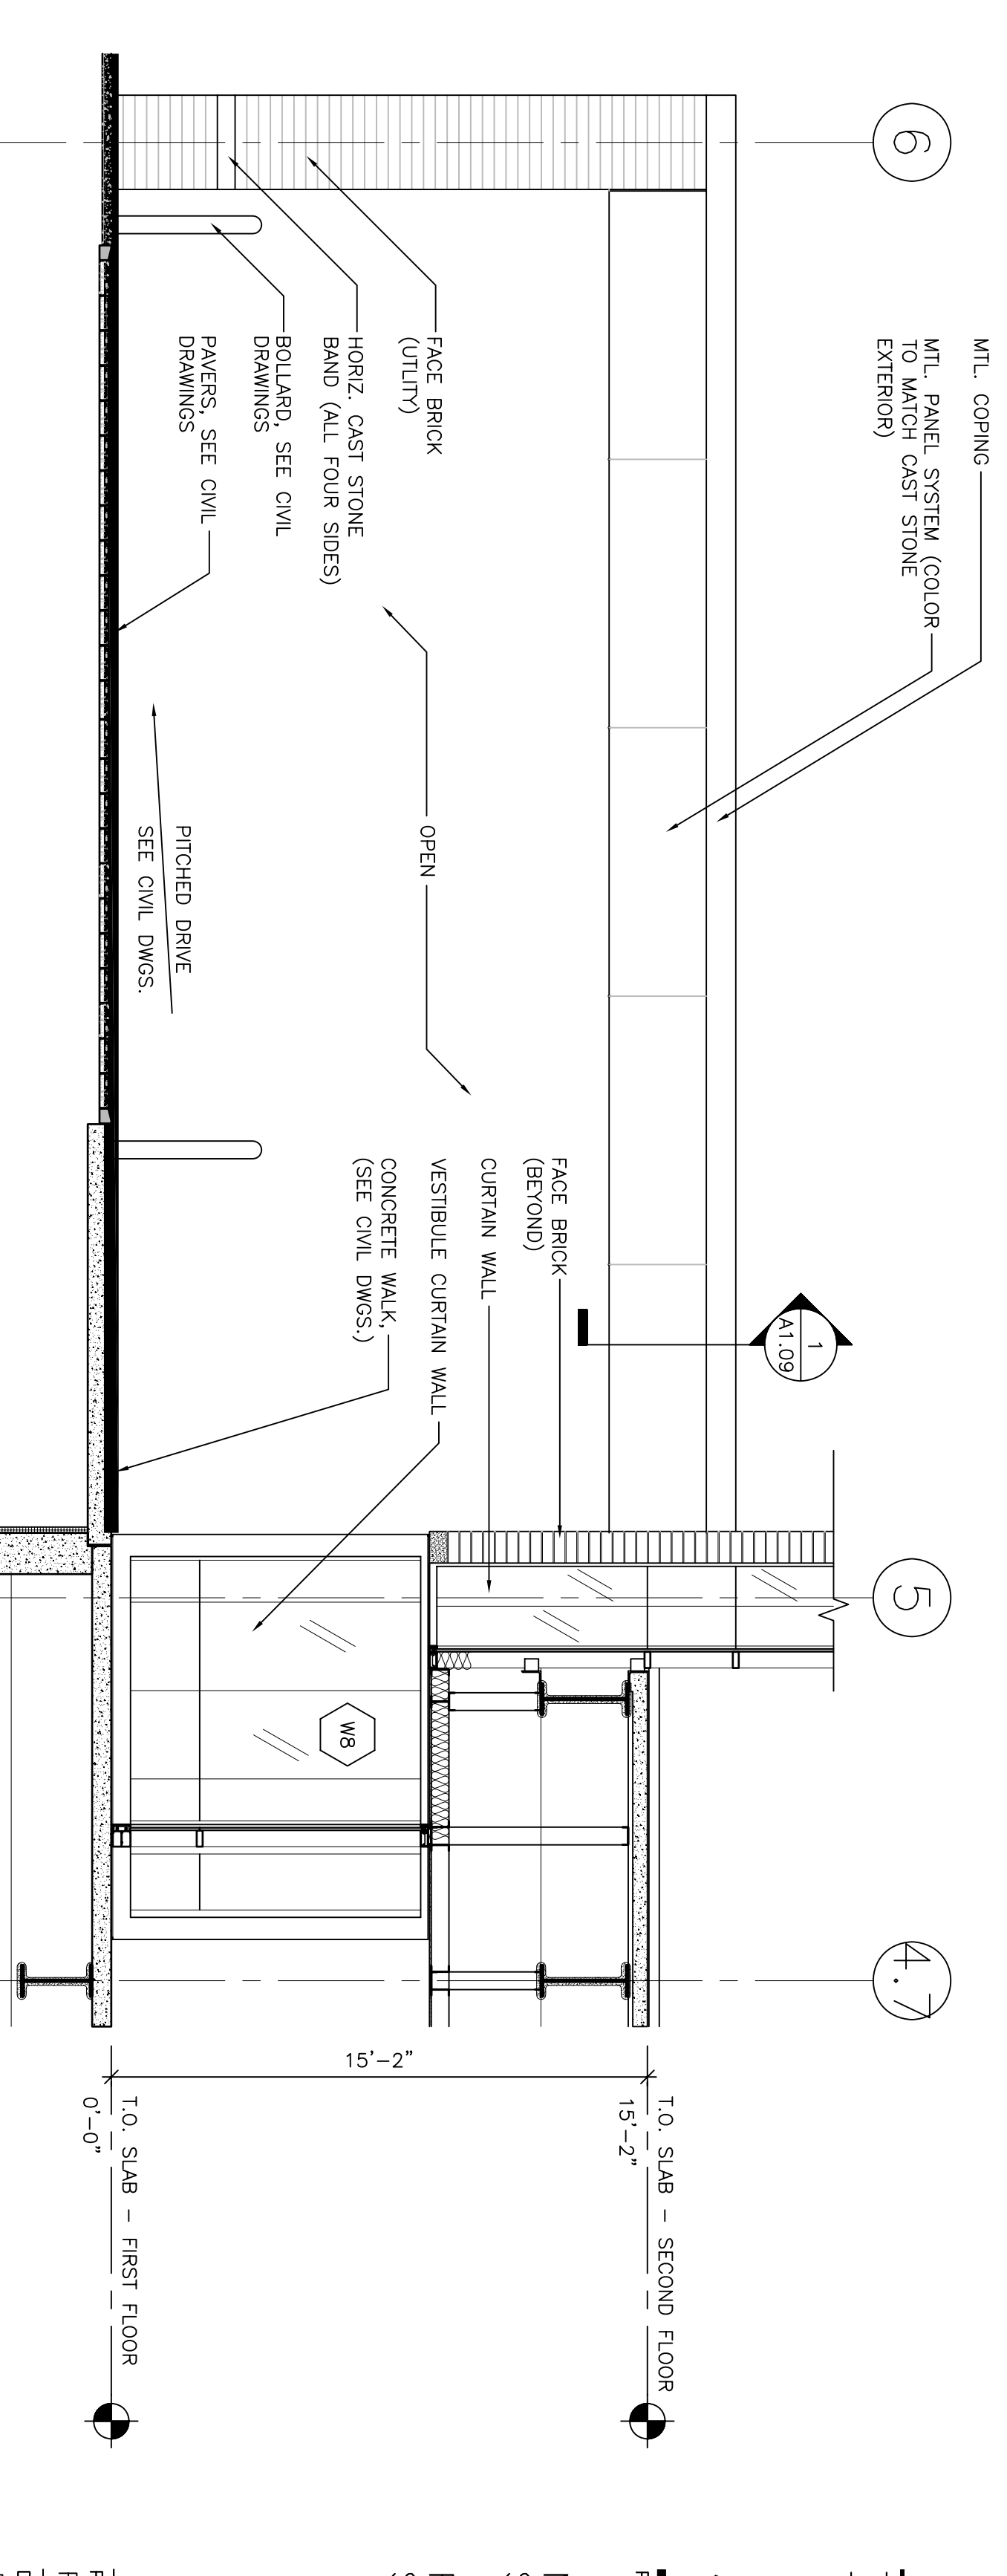

4 ENTRANCE CANOPY - EXTERIOR ELEVATION
 SCALE: 1/4"=1'-0"

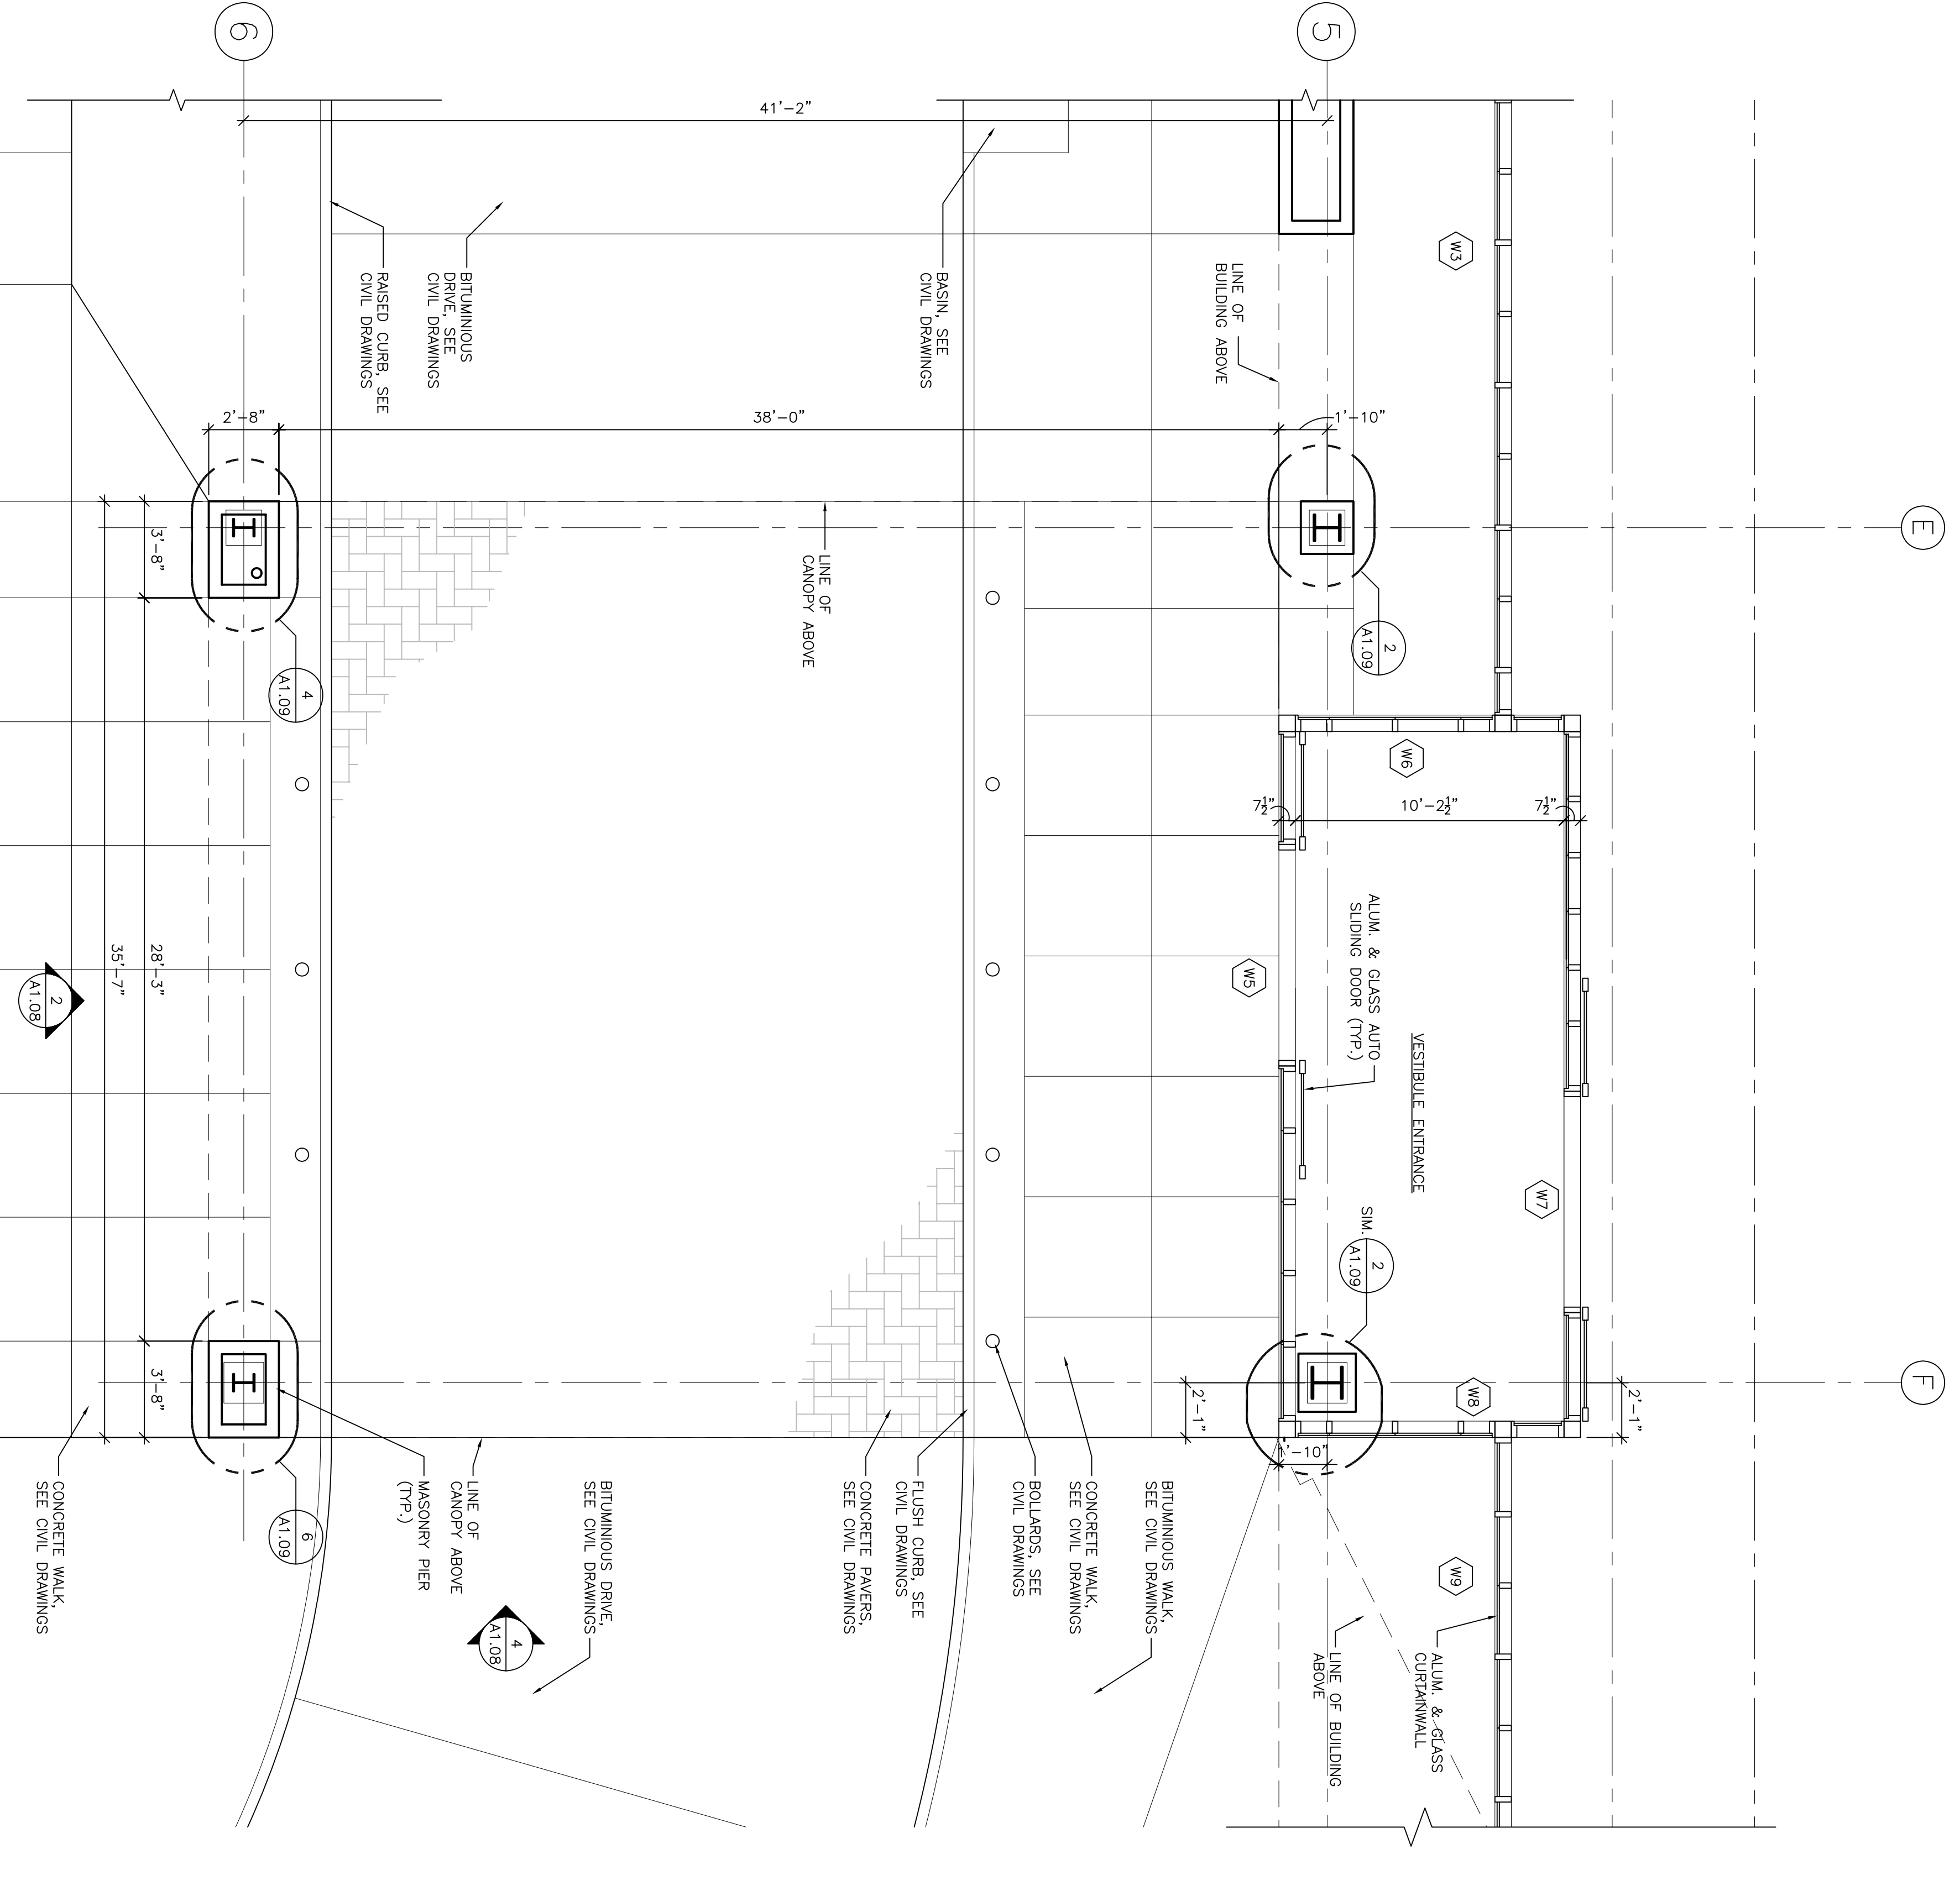

1 ENTRANCE CANOPY - PLAN
 SCALE: 1/4"=1'-0"

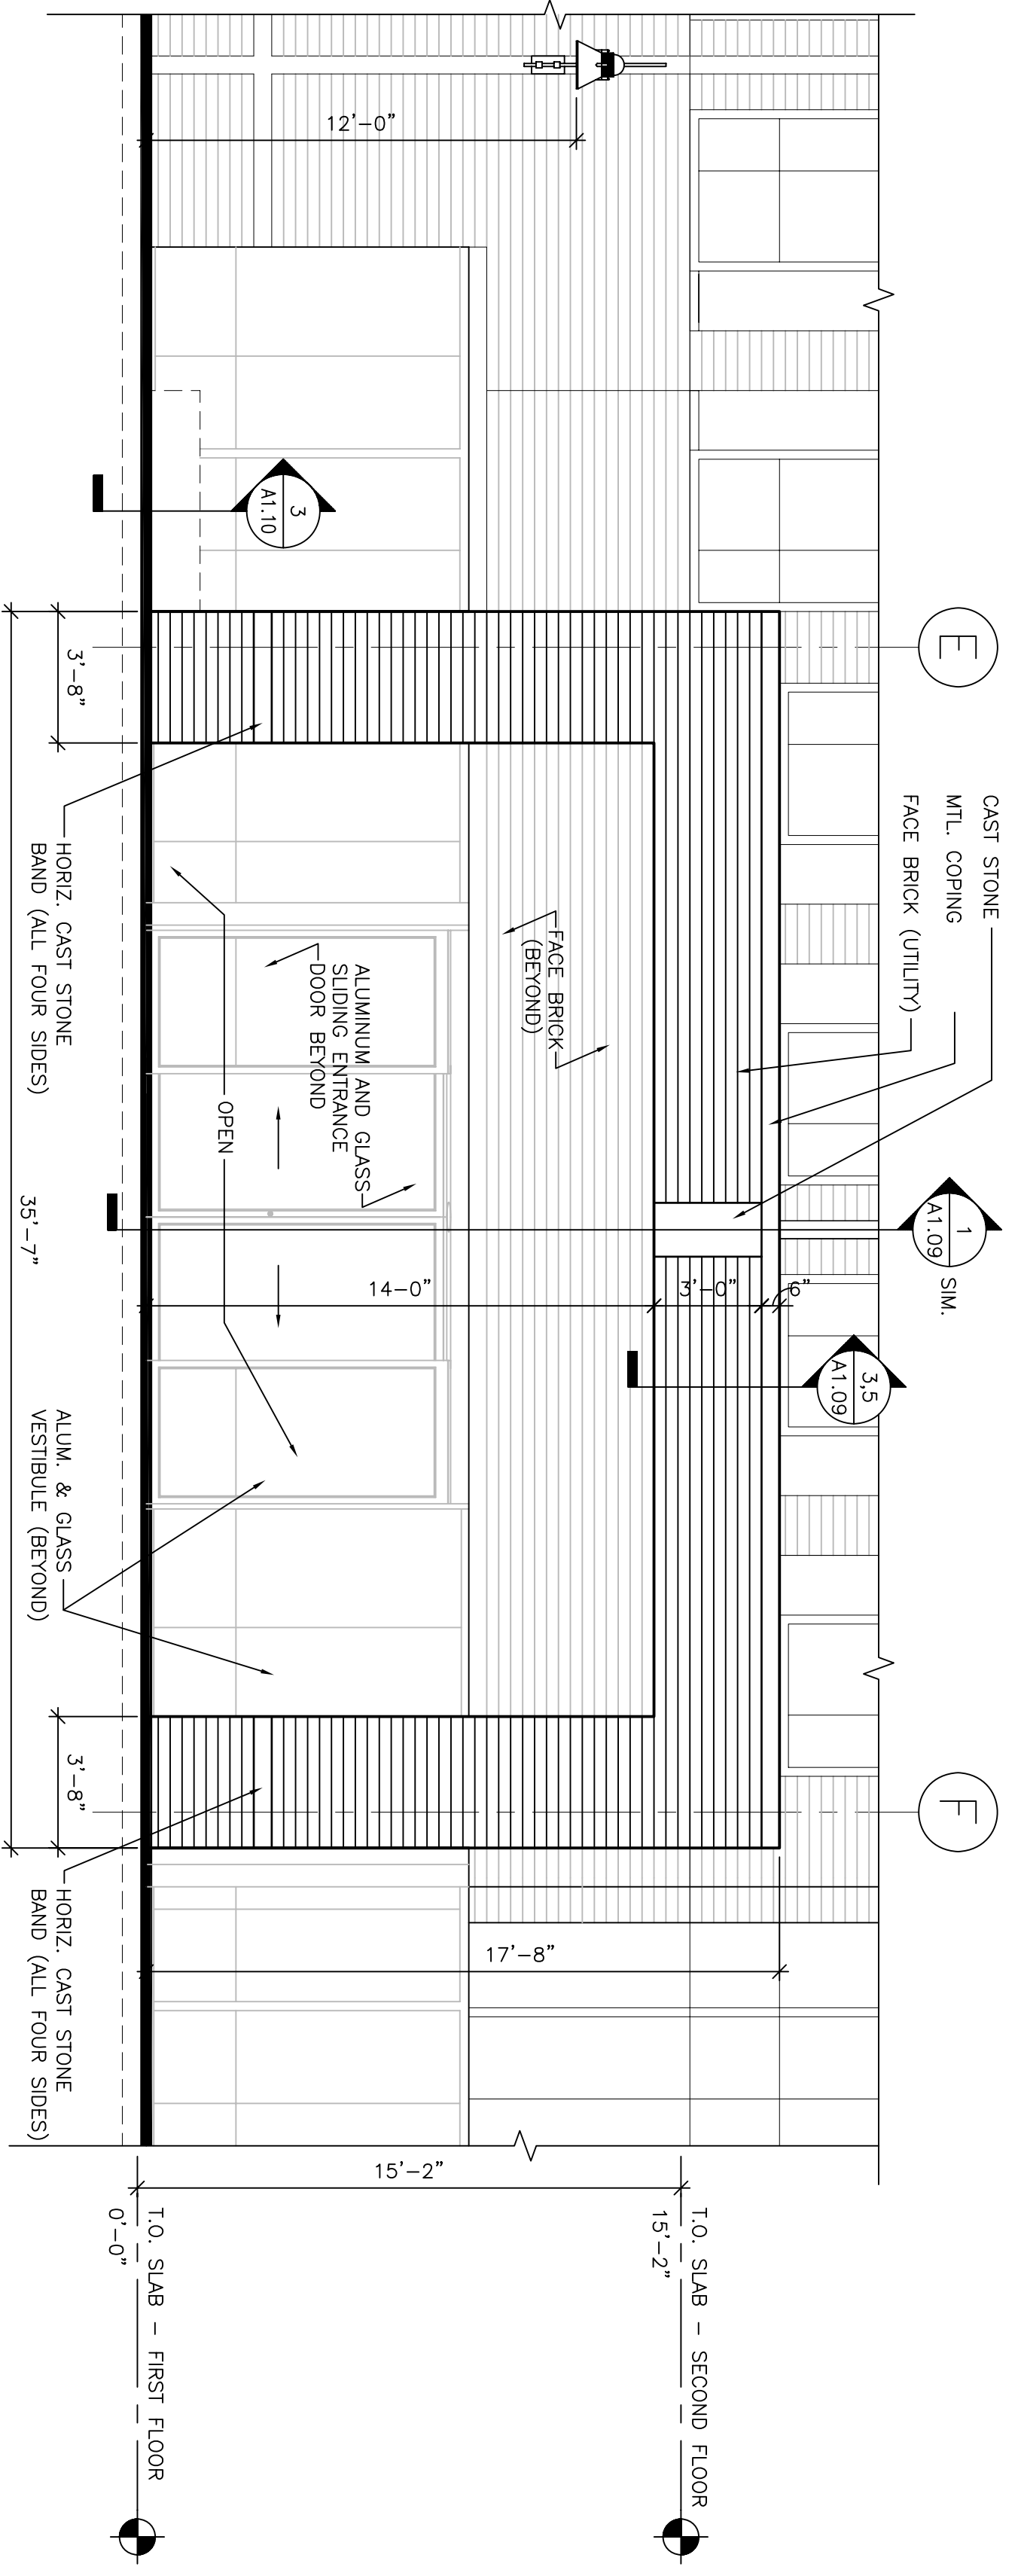

2 ENTRANCE CANOPY - WEST ELEVATION
 SCALE: 1/4"=1'-0"