

Consultant  
Civil Engineer  
Palumbo-Hoffman Associates, Inc.  
226 Main Street, Suite 806  
Portland, Maine 04106  
Phone: (207) 775-1121  
Fax: (207) 879-0986

Consultant  
ASSOCIATE ARCHITECT/STRUCTURAL ENGINEER  
SHERPINE SHAW P.C. Box 618  
Portland, Maine 04106  
Phone: (207) 772-3346  
Fax: (207) 772-1070

Consultant  
MECHANICAL/ELECTRICAL ENGINEER  
Boyd, Ross + Atkins Consulting Engineers, LLC  
311 Arsenal Street, Suite 200  
Portland, Maine 04102  
Phone: 6172440016  
Fax: 6173243339

Consultant  
EQUIPMENT PLANNING  
Manning Construction Management  
1893 General George Patton Drive  
Franklin, Tennessee 37067  
Phone: (615) 376-3114  
Fax: (615) 376-3114

Consultant  
CONSTRUCTION MANAGER  
Manning Construction Management  
7 Jackson Way  
Franklin, Tennessee 37063  
Phone: (401) 456-5905  
Fax: (401) 456-5916

Consultant  
Interior Architect  
Impon Federovics, LLC  
1808 Main End Ave, Suite 1400  
Portland, Maine 04102  
Phone: (615) 321-5591  
Fax: (615) 321-5689

**The responsibility of the Construction Manager/General Contractor and all design and construction work shall be in accordance with the conditions of prior work by related trades before proceeding with any work.**

Date	Issue for
11/10/06	Construction
Drawn By	SKG/MAG
Scale	AS NOTED

Francis

Cauffman

Foley

Hoffmann


Project Architect  
Foley Hoffmann  
Architects Ltd.  
2120 Arch. Street  
Philadelphia, PA 19103  
215-568-8250

Project Title  
Mercy Health Core  
System of Maine  
FORE RIVER SHORT  
STAY HOSPITAL




Project Number  
FO5-4898  
Drawing Title and Number  
LOBBY DETAILS


A1.28A

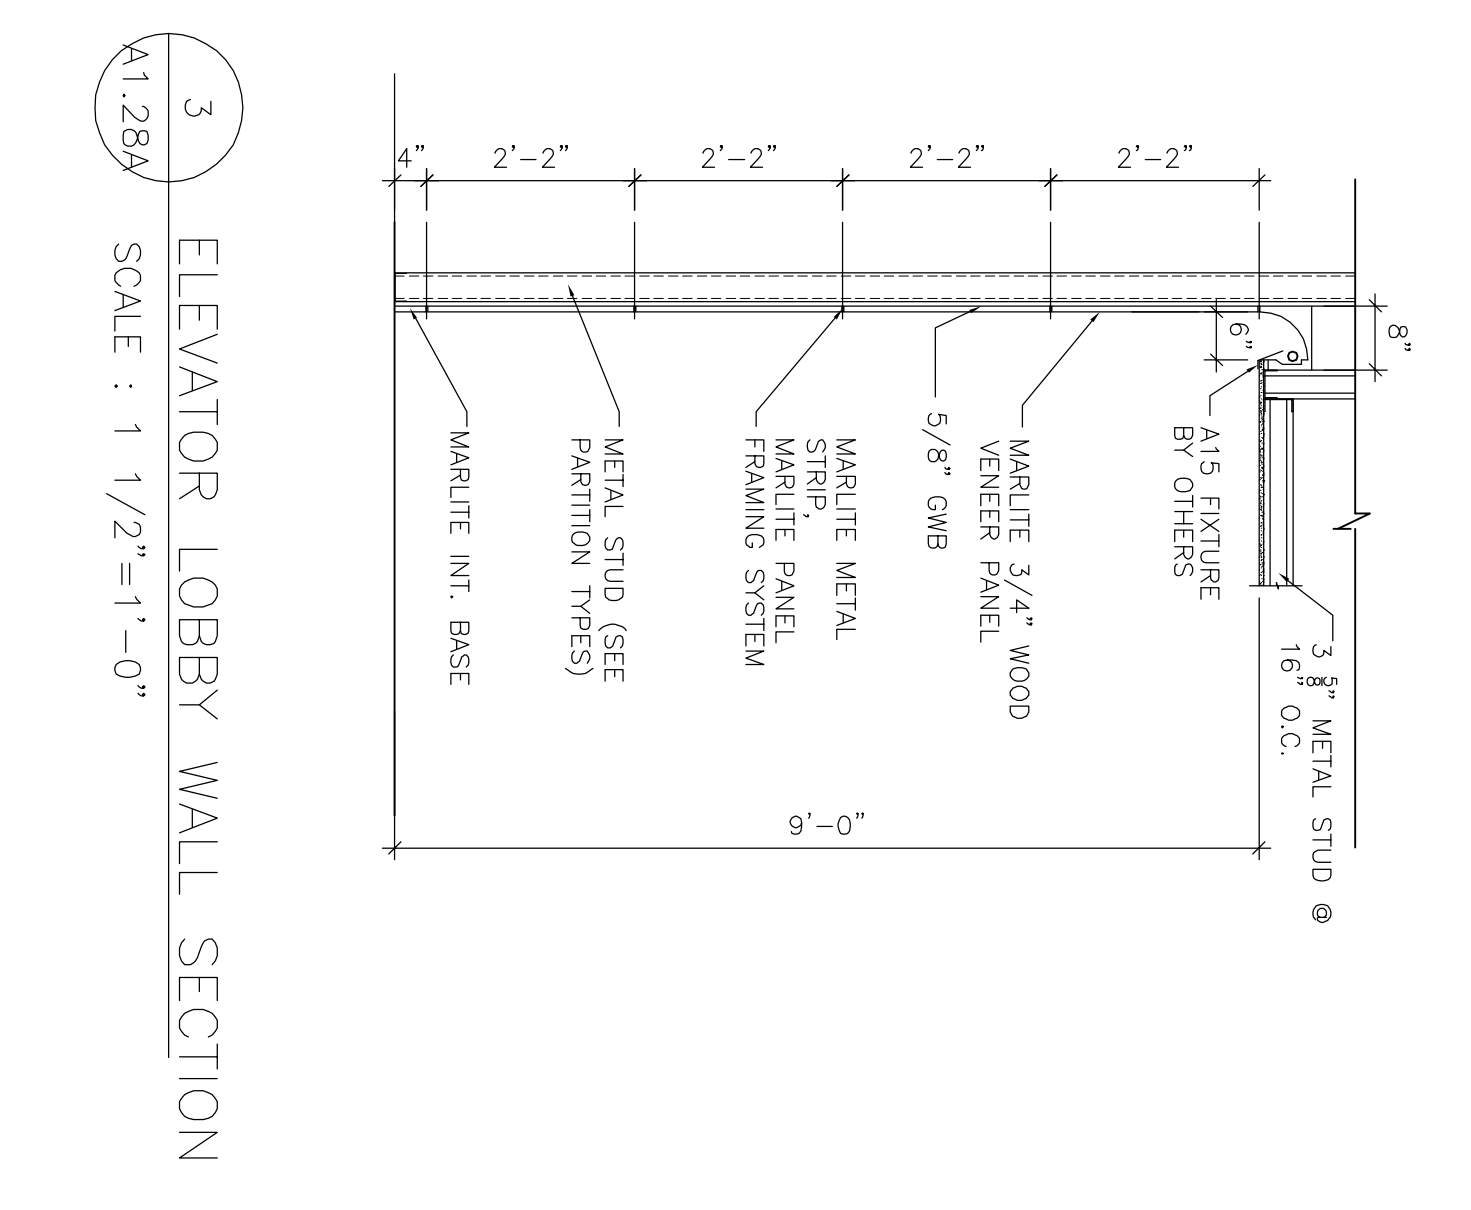

3 ELEVATOR LOBBY WALL SECTION  
SCALE : 1 1/2"=1'-0"

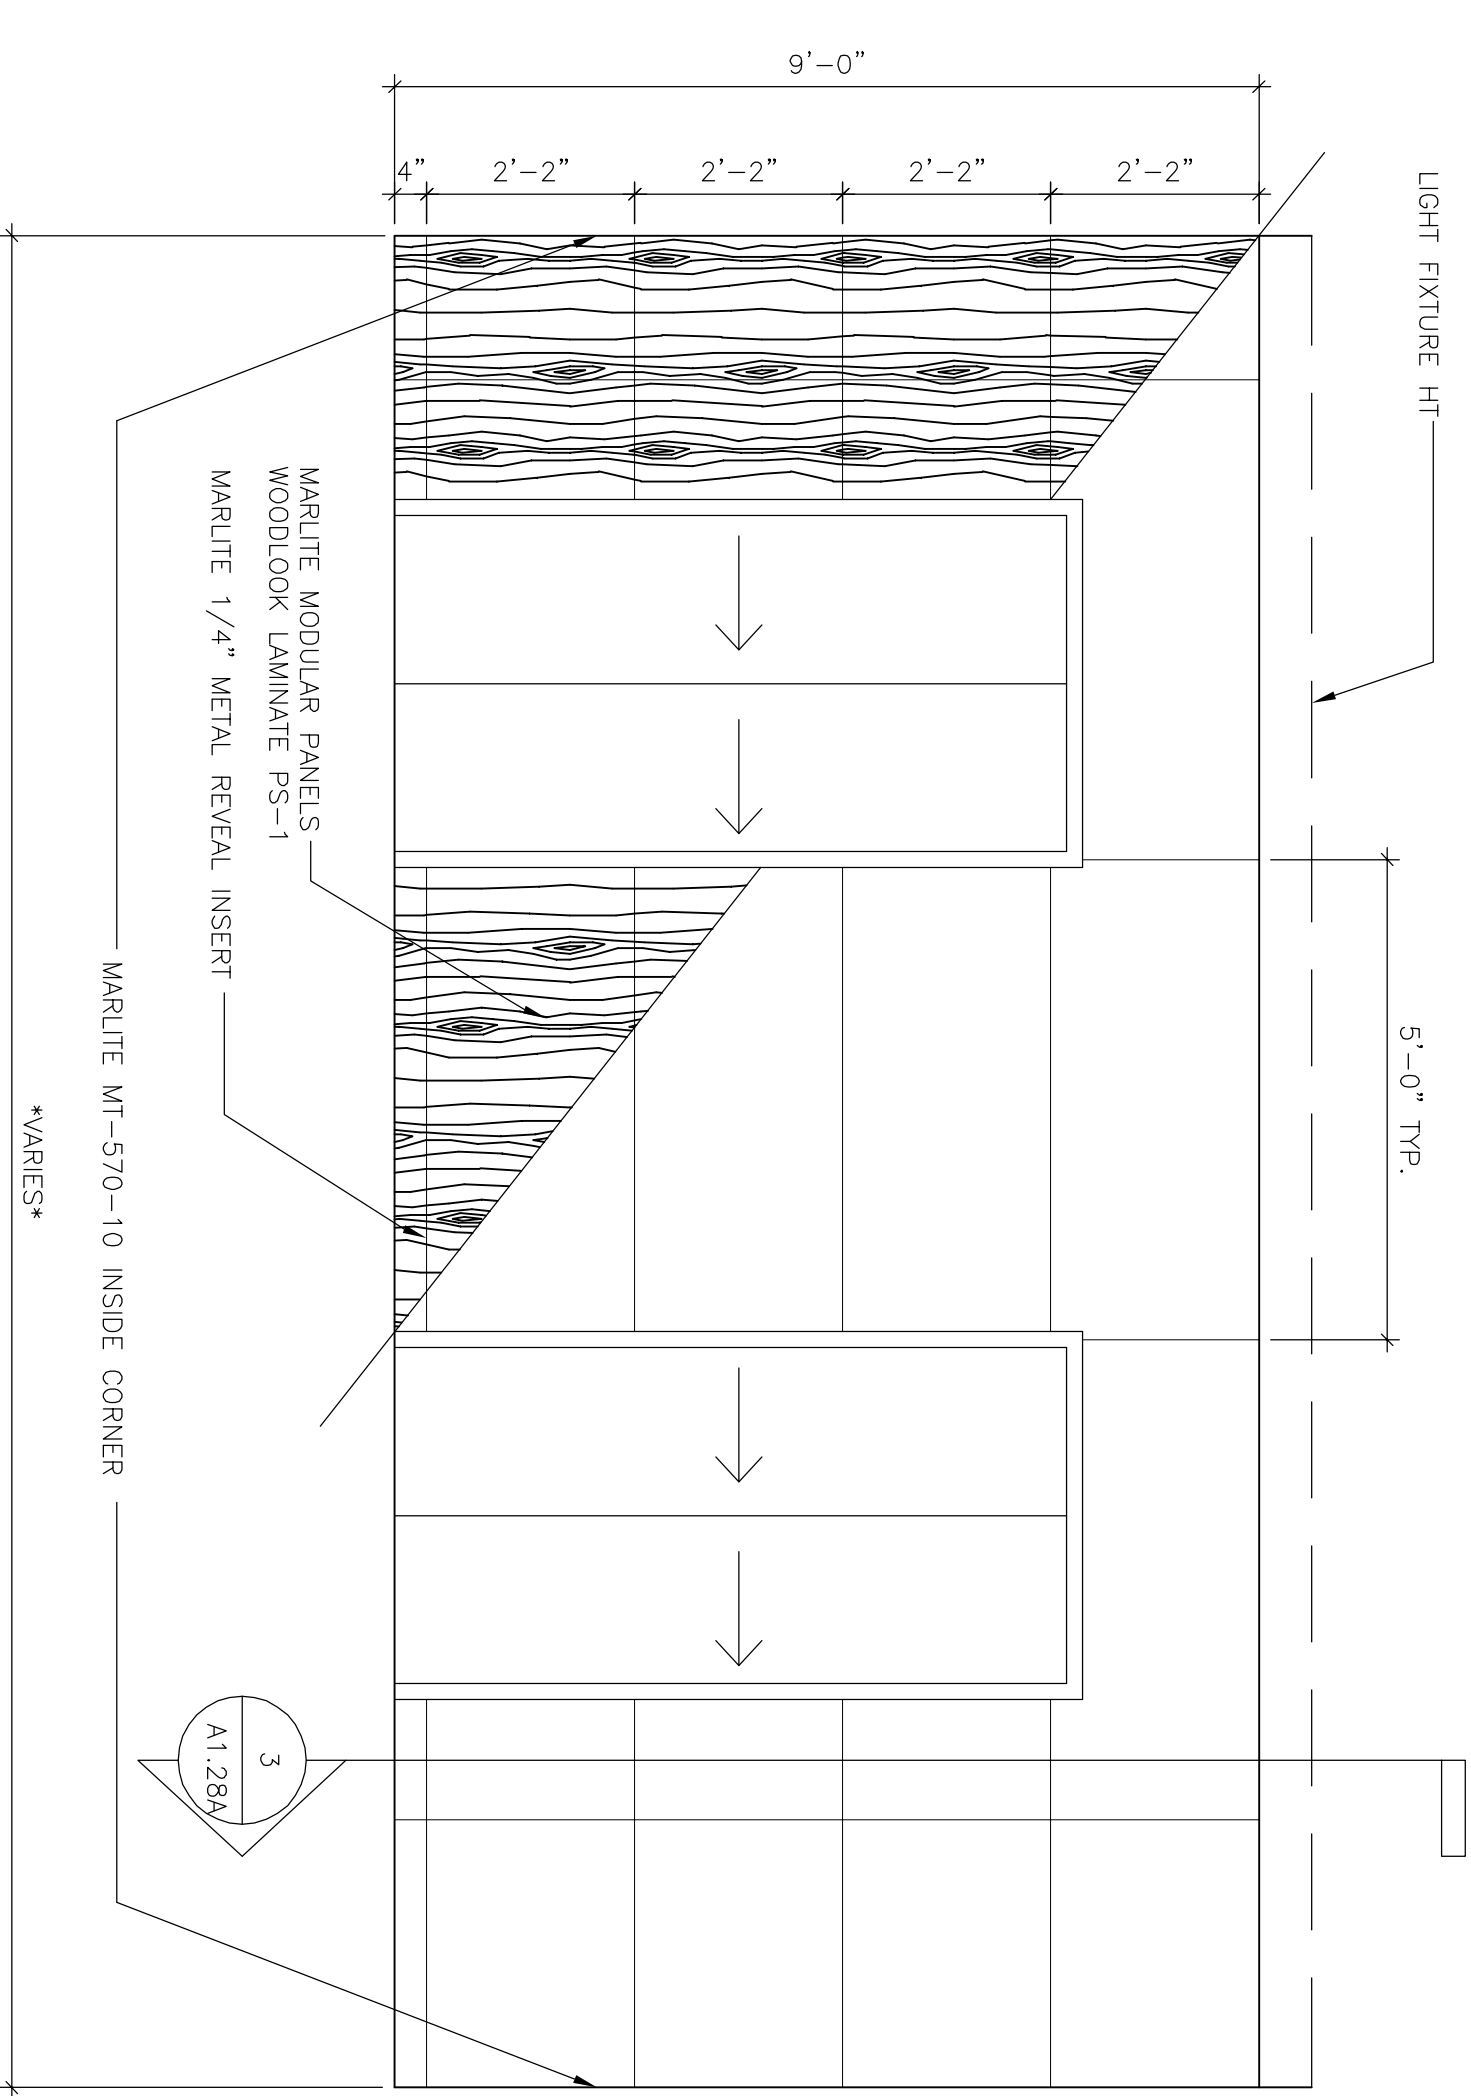

2 ELEVATOR LOBBY ELEVATION  
SCALE : 1 1/2"=1'-0"

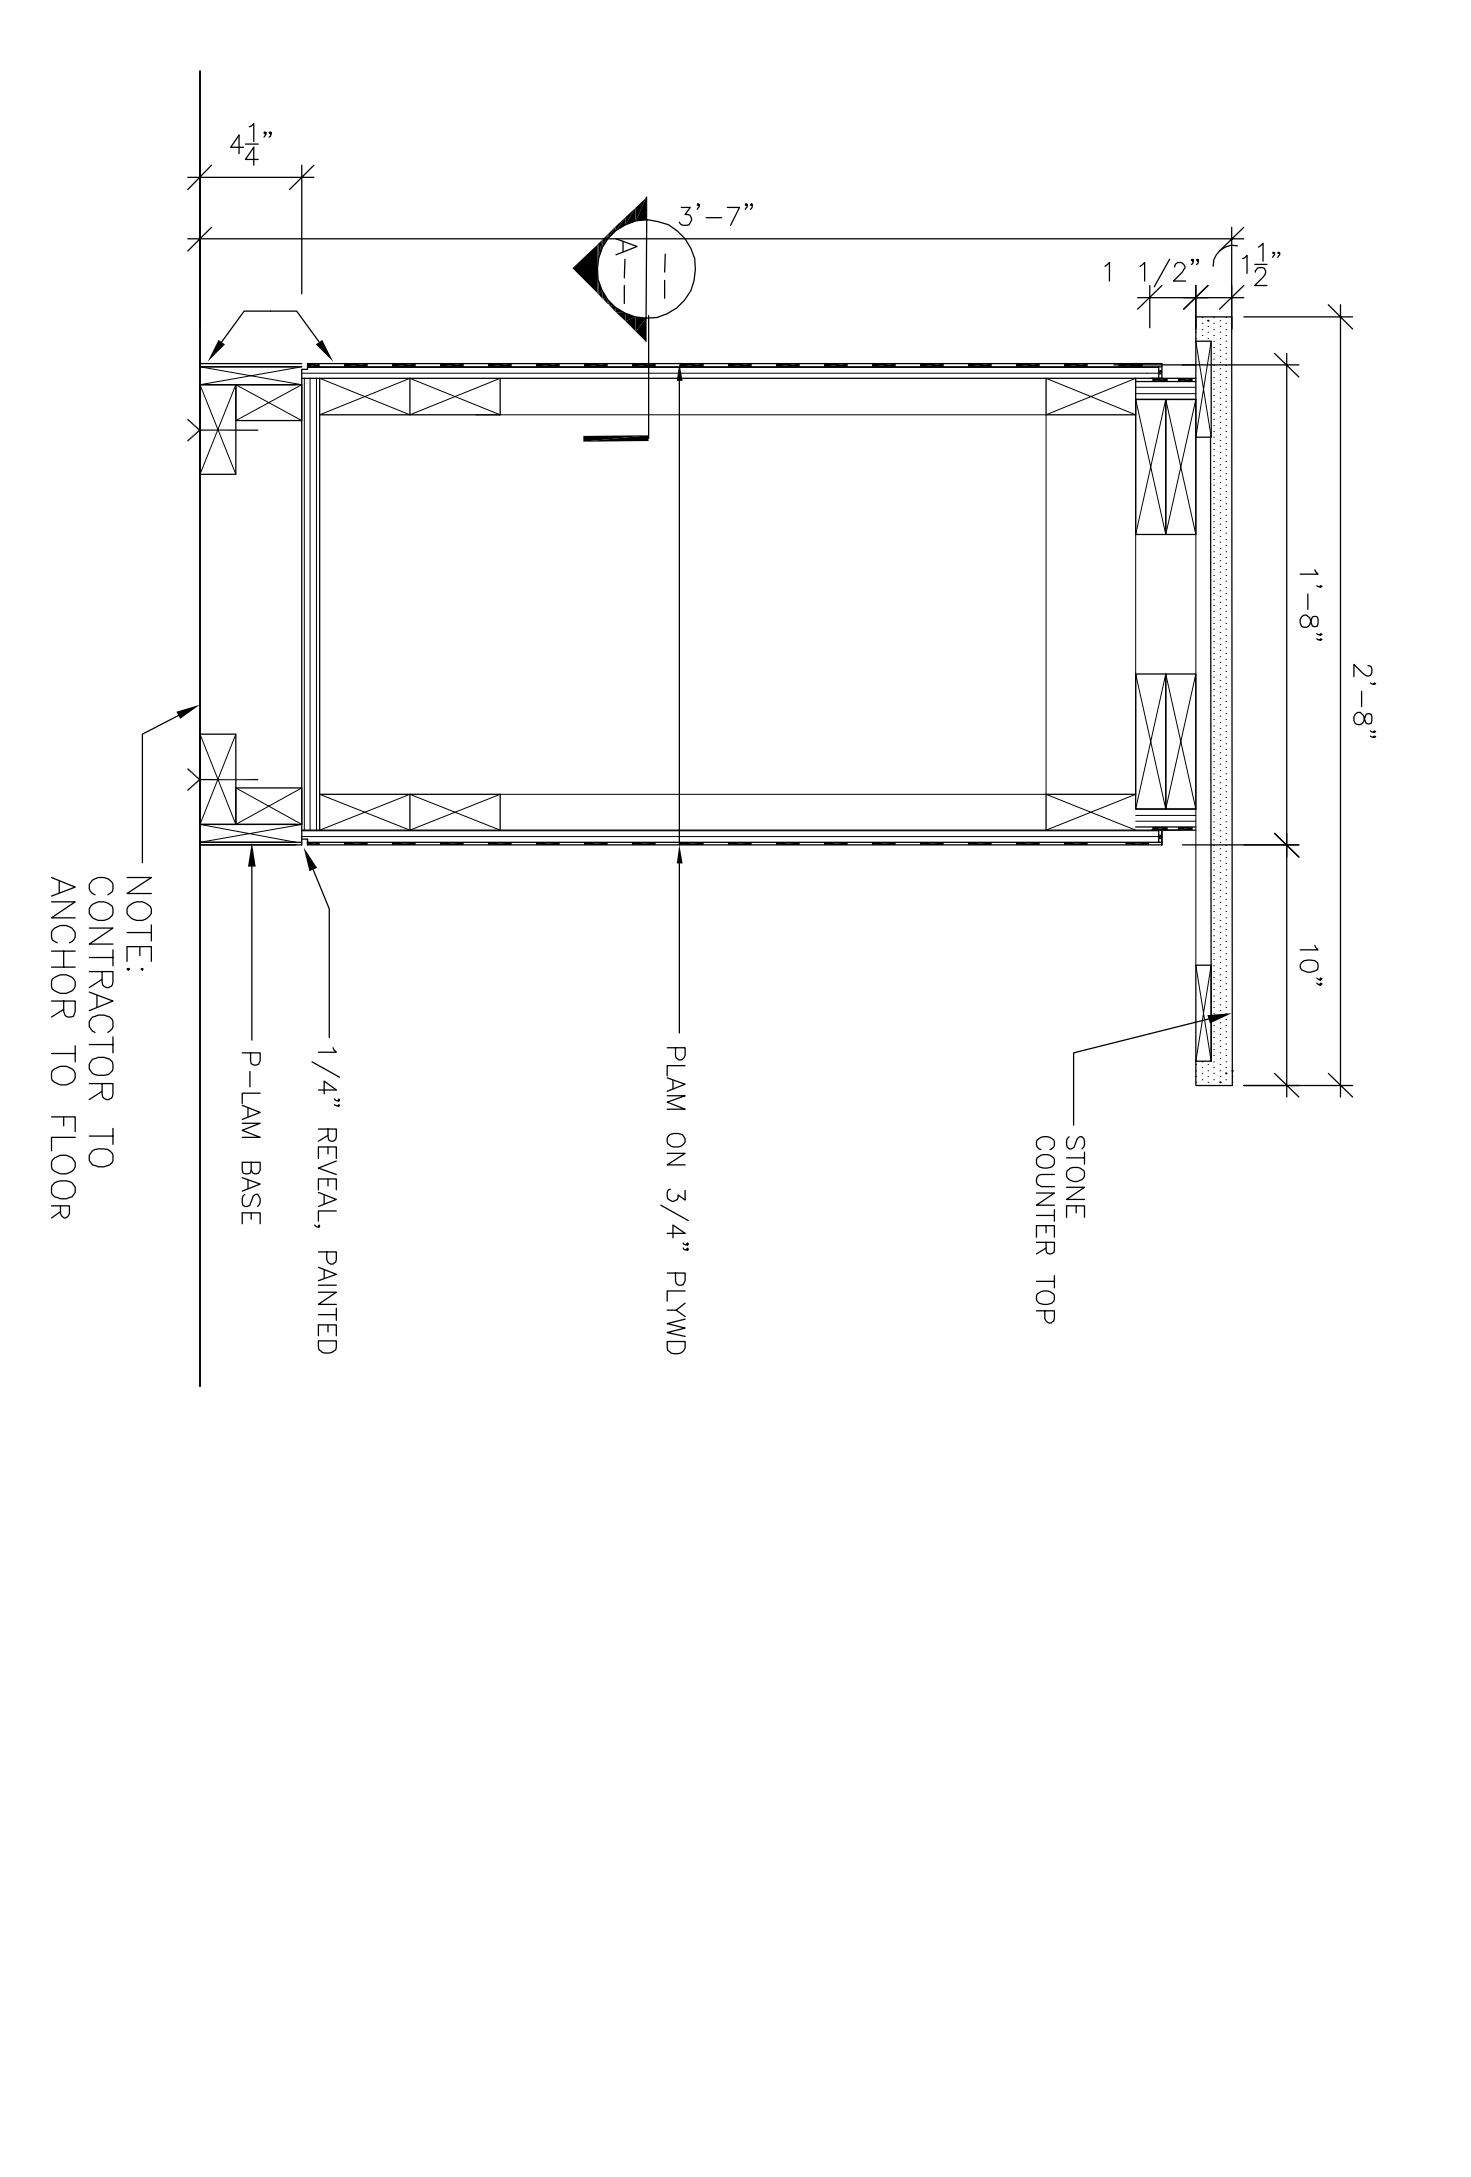

1 COUNTER SECTION - 2ND FLOOR WAITING  
SCALE : 1 1/2"=1'-0"