





CUMBERLAND COUNTY
CORRECTIONAL FACILITY

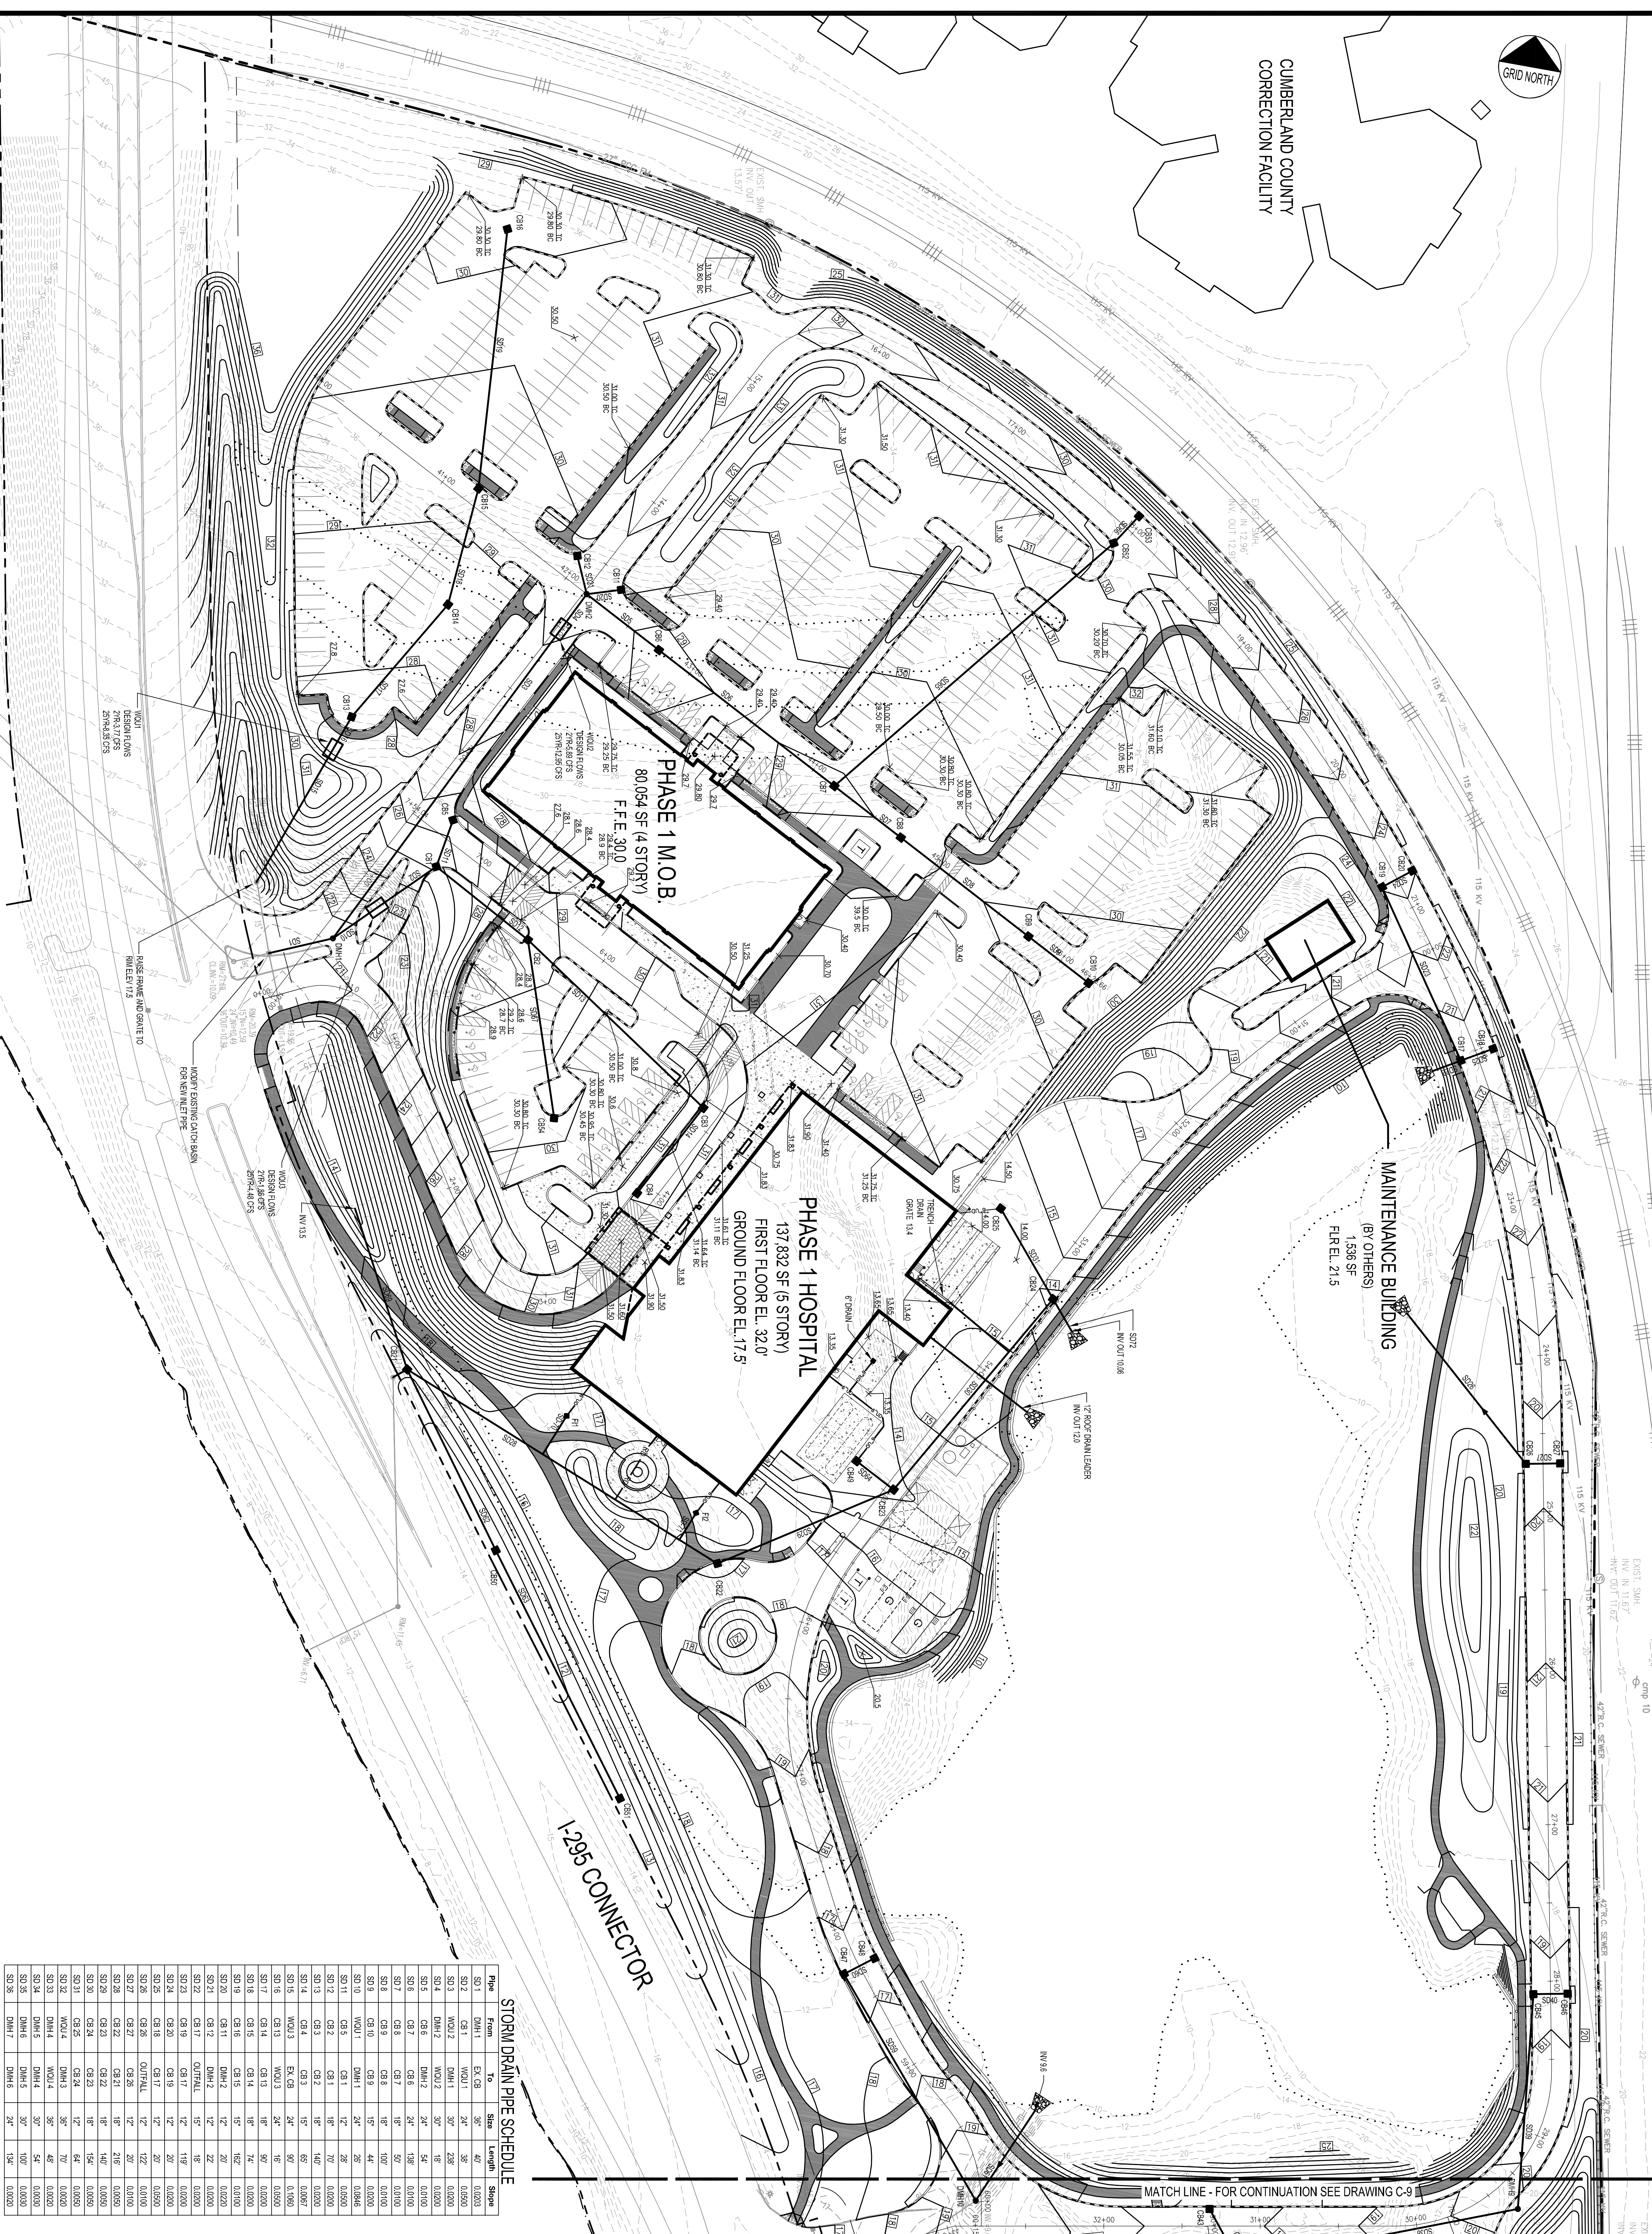

STORM DRAIN PIPE SCHEDULE

Pipe	From	To	Size	Length	Slope
S01	DMH1	EX C8	36"	40'	0.0030
S02	C81	W011	24"	38'	0.0030
S03	W012	W011	30"	28'	0.0030
S04	DM12	W011	30"	18'	0.0030
S05	DM12	DM12	30"	18'	0.0030
S06	DM12	DM12	30"	18'	0.0030
S07	DM12	DM12	30"	18'	0.0030
S08	DM12	DM12	30"	18'	0.0030
S09	DM10	DM11	24"	44'	0.0030
S10	DM10	DM11	24"	26'	0.0030
S11	DM11	DM11	24"	26'	0.0030
S12	DM11	DM11	24"	26'	0.0030
S13	DM11	DM11	24"	26'	0.0030
S14	DM11	DM11	24"	26'	0.0030
S15	DM11	DM11	24"	26'	0.0030
S16	DM11	DM11	24"	26'	0.0030
S17	DM11	DM11	24"	26'	0.0030
S18	DM11	DM11	24"	26'	0.0030
S19	DM11	DM11	24"	26'	0.0030
S20	DM11	DM11	24"	26'	0.0030
S21	DM11	DM11	24"	26'	0.0030
S22	DM11	DM11	24"	26'	0.0030
S23	DM11	DM11	24"	26'	0.0030
S24	DM11	DM11	24"	26'	0.0030
S25	DM11	DM11	24"	26'	0.0030
S26	DM11	DM11	24"	26'	0.0030
S27	DM11	DM11	24"	26'	0.0030
S28	DM11	DM11	24"	26'	0.0030
S29	DM11	DM11	24"	26'	0.0030
S30	DM11	DM11	24"	26'	0.0030
S31	DM11	DM11	24"	26'	0.0030
S32	DM11	DM11	24"	26'	0.0030
S33	DM11	DM11	24"	26'	0.0030
S34	DM11	DM11	24"	26'	0.0030
S35	DM11	DM11	24"	26'	0.0030
S36	DM11	DM11	24"	26'	0.0030
S37	DM11	DM11	24"	26'	0.0030
S38	DM11	DM11	24"	26'	0.0030

ID	SIZE	MM	IN	ANSI	DESCRIPTION	INVENTORY
C81	4.00	100	4	100	4.00	100
C82	4.00	100	4	100	4.00	100
C83	4.00	100	4	100	4.00	100
C84	4.00	100	4	100	4.00	100
C85	4.00	100	4	100	4.00	100
C86	4.00	100	4	100	4.00	100
C87	4.00	100	4	100	4.00	100
C88	4.00	100	4	100	4.00	100
C89	4.00	100	4	100	4.00	100
C90	4.00	100	4	100	4.00	100
C91	4.00	100	4	100	4.00	100
C92	4.00	100	4	100	4.00	100
C93	4.00	100	4	100	4.00	100
C94	4.00	100	4	100	4.00	100
C95	4.00	100	4	100	4.00	100
C96	4.00	100	4	100	4.00	100
C97	4.00	100	4	100	4.00	100
C98	4.00	100	4	100	4.00	100
C99	4.00	100	4	100	4.00	100
C100	4.00	100	4	100	4.00	100

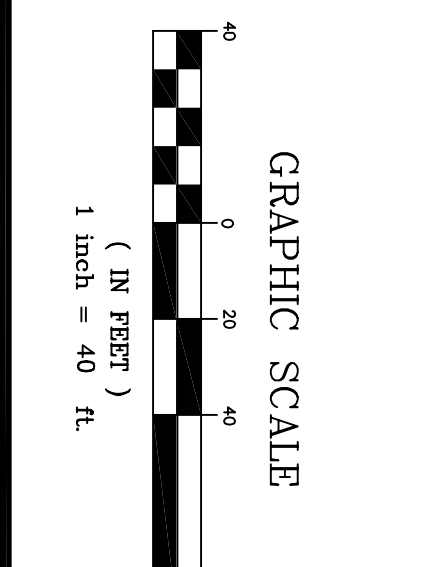

REV	DATE	DESCRIPTION
1	11/01/01	SITE LOCATION OF DEVELOPMENT FROM SUBMISSION
2	11/01/01	PRELIMINARY PLAN APPLICATION TO CITY OF PORTLAND
3	11/01/01	REVISIONS TO CITY OF PORTLAND
4	11/01/01	RESUBMITTED TO CITY OF PORTLAND
5	11/01/01	REVISIONS TO CITY OF PORTLAND
6	11/01/01	REVISIONS TO CITY OF PORTLAND
7	11/01/01	REVISIONS TO CITY OF PORTLAND

PROJECT: MERCY AT THE FORE

SHEET TITLE: GRADING AND DRAINAGE PLAN - NORTH

CLIENT: MERCY HOSPITAL

DESIGNED: SFB | JOB NO. 2149.01

CHECKED: SFB | SCALE: 1"=40'

FILE NAME: 2149.01-M3

SHEET: C-8

DA LUCA-HOFFMAN ASSOCIATES, INC.
7798 MAIN STREET, SUITE B
PORTLAND, ME 04106
PH: 603.766.4444
WWW.DAHLUCAHOFFMAN.COM