



ELECTRICAL DETAIL
X-RAY MAIN DISCONNECT PANEL

ELEC-15
REV. DATE: 01/22/03

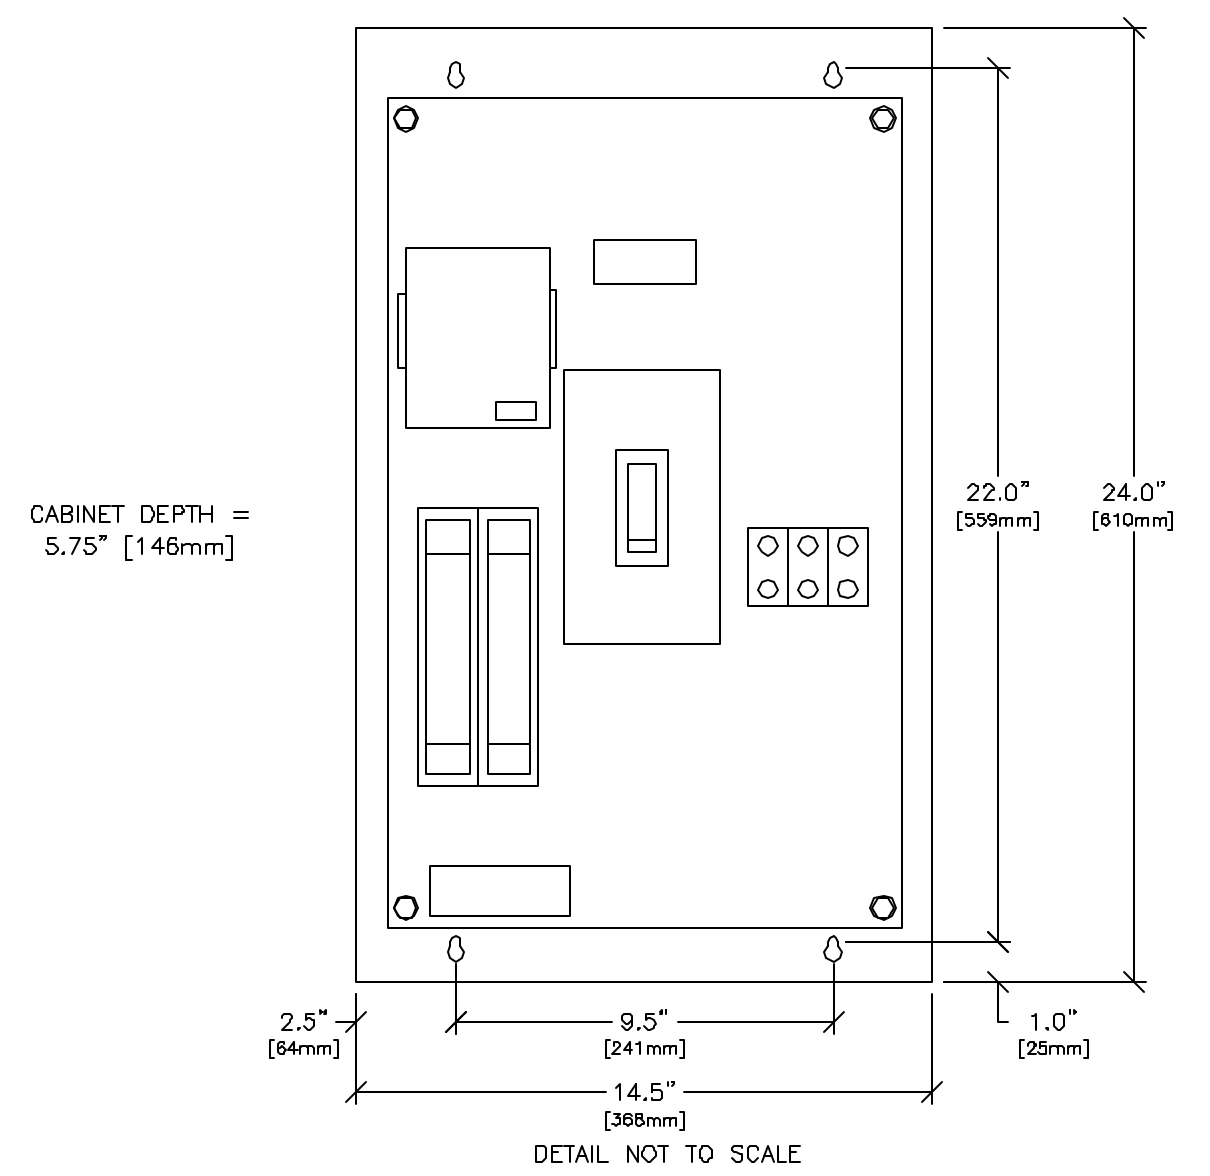


ELECTRICAL DETAIL
VCR WALL PLATE

ELEC-111
REV. DATE: 01/04/02

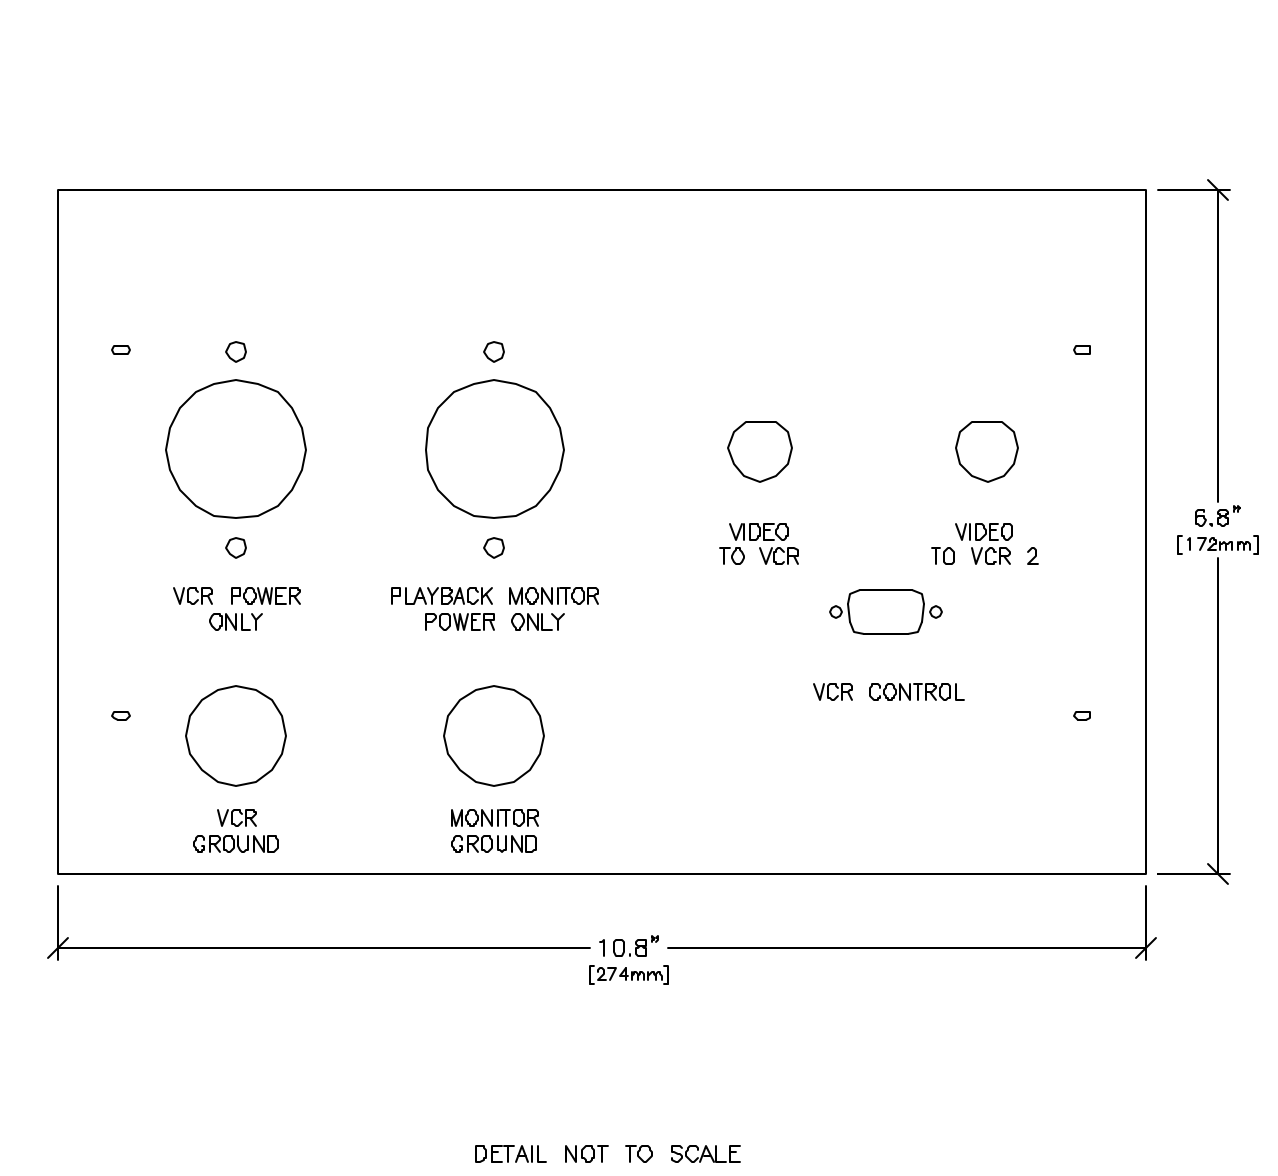


EQUIPMENT DETAIL
IUI WALL PLATE

ELEC-109
REV. DATE: 01/04/02

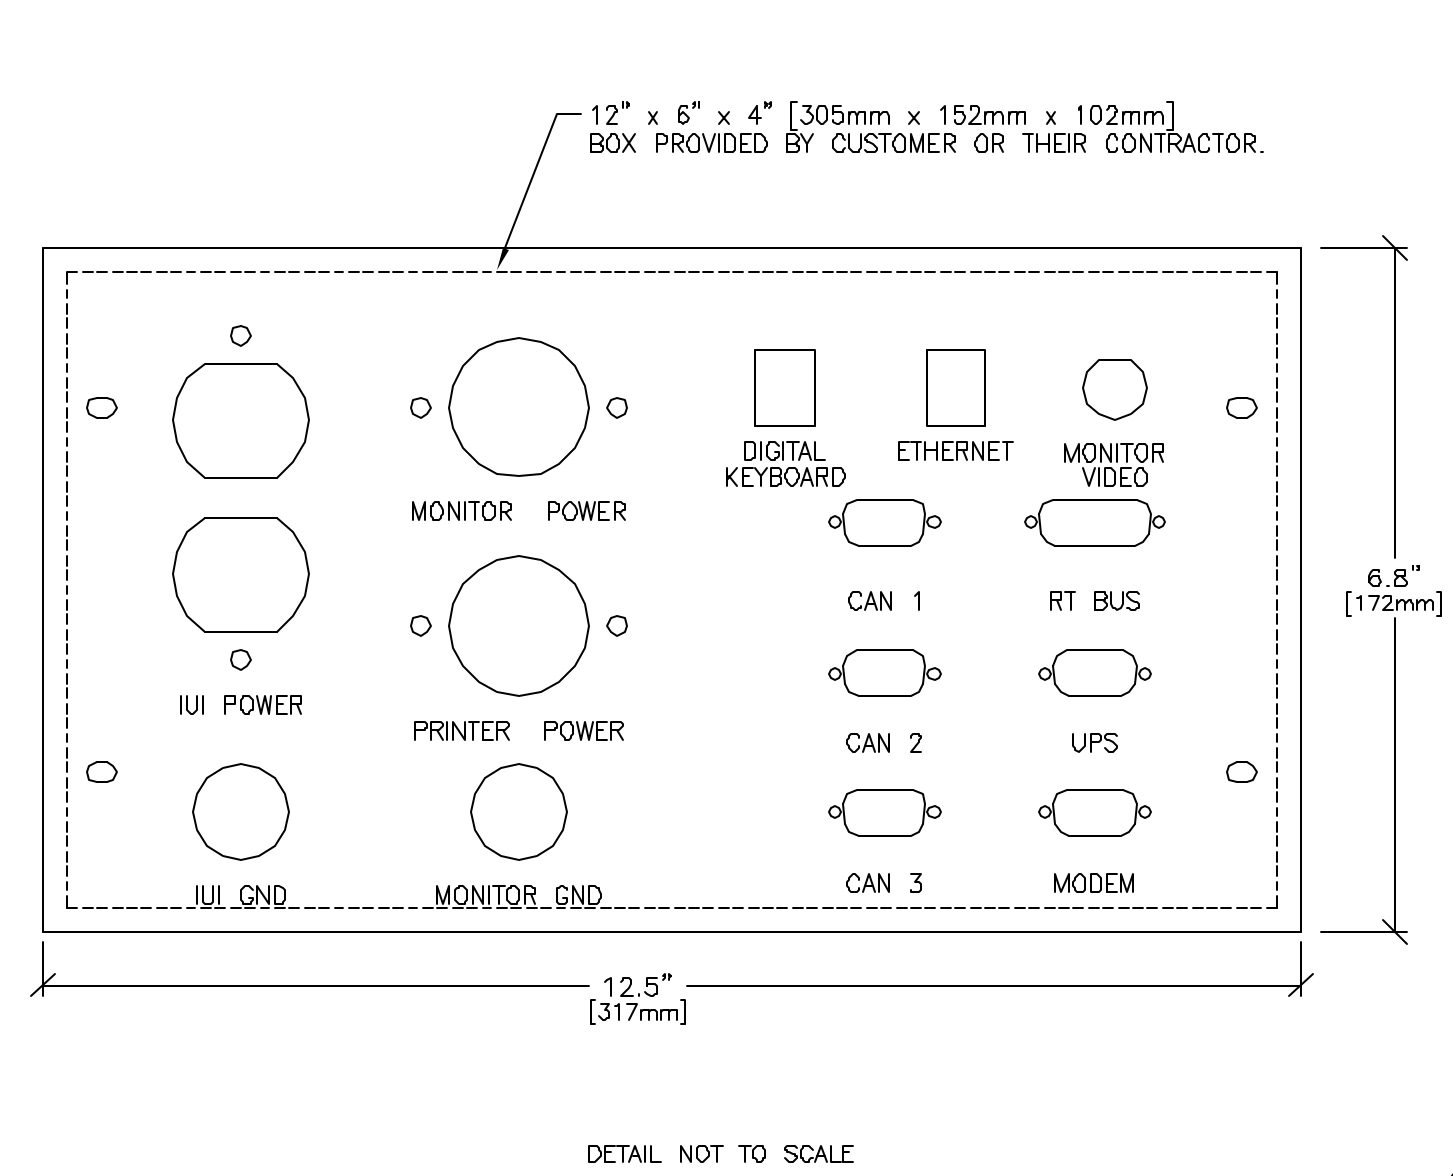

ELECTRICAL DETAIL
INSITE CONNECTION (TYPICAL)

ELEC-1
REV. DATE: 04/24/02

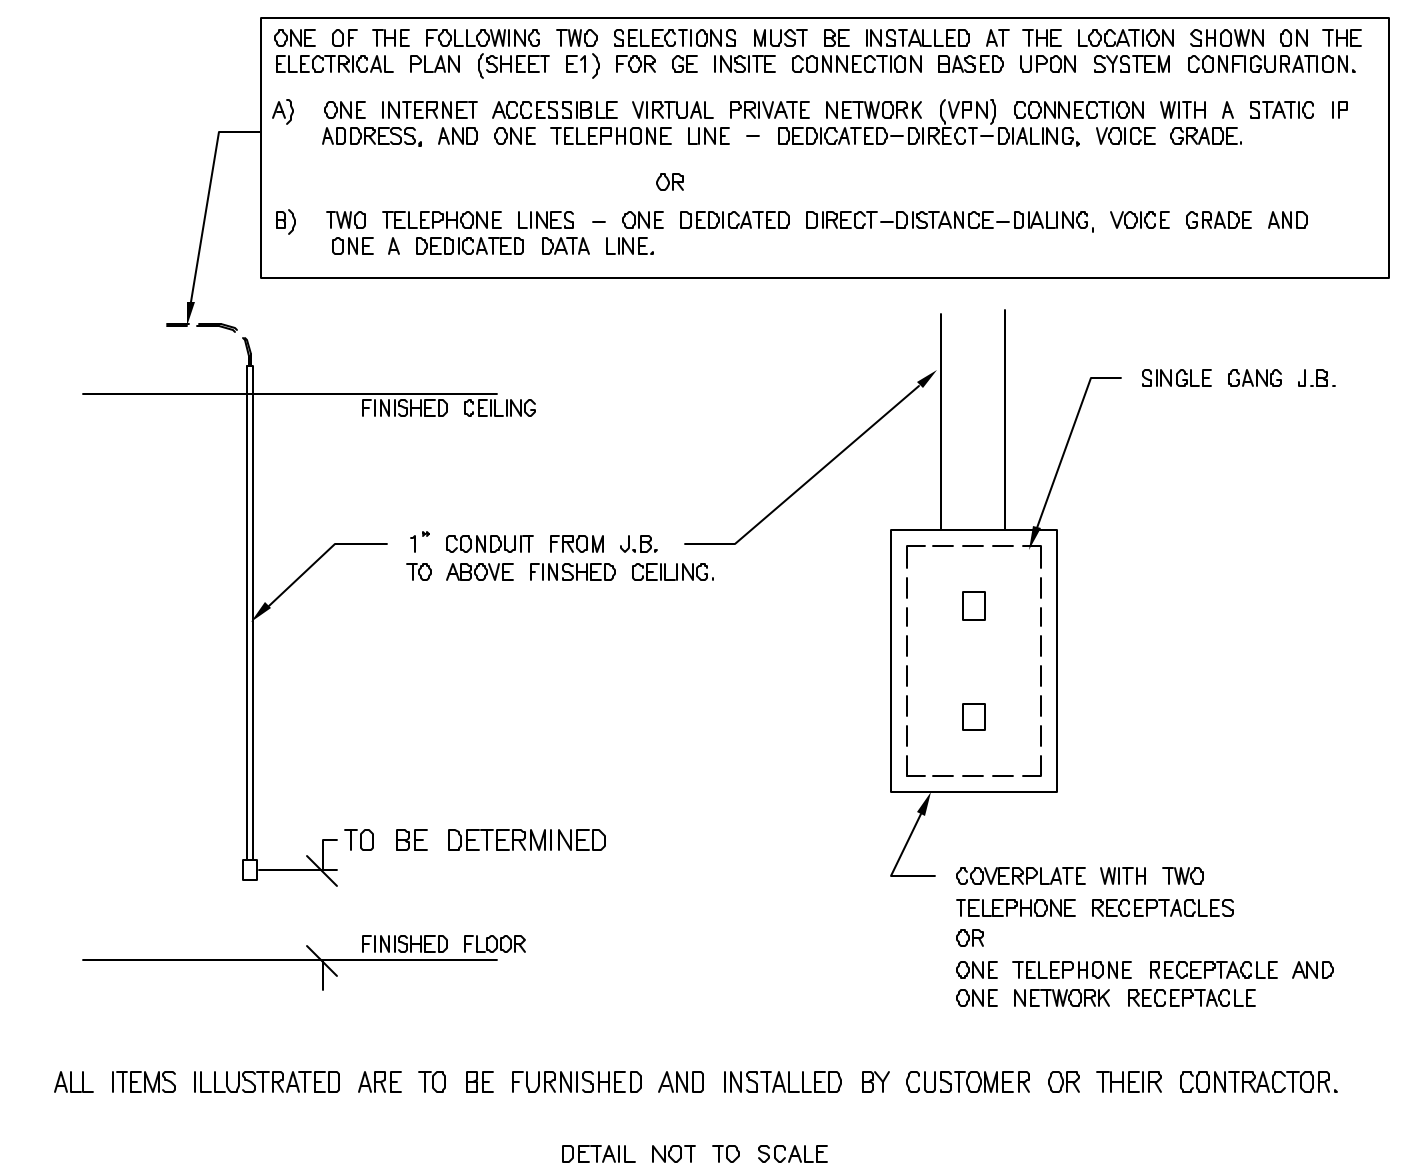

GE Healthcare Technologies
Installation Services Design Center
Milwaukee, Wisconsin

SHEET TITLE: ELECTRICAL DETAILS
MODALITY TYPE: PRECISION 500D

THIS PLAN IS SUBMITTED TO SUGGEST LOCATION OF GE HEALTHCARE EQUIPMENT AND ASSOCIATED APPARATUS. ELECTRICAL WIRING DETAILS AND ROOM ARRANGEMENTS ARE THE RESPONSIBILITY OF THE ARCHITECT. THESE DETAILS ARE NOT TO BE USED FOR ACTUAL CONSTRUCTION PURPOSES. HOWEVER, AND THE COMPANY CANNOT ACCEPT RESPONSIBILITY FOR ANY DAMAGES RESULTING THEREFROM.

PROJECT TITLE:
**MERCY HOSPITAL
FORE RIVER
PORTLAND, MAINE**

PROJECT	REVISION
065710	00
DATE:	09-18-06
DRAWN BY:	NMS
CHECKED BY:	JDR
QUOTE NO.:	KX1CB9
QT. DATE:	09-07-06

REVISION HISTORY:

SHEET
E4

This drawing is based on Sketch No.: D6nef025B