


AUTOMATIC SPRINKLER SYSTEM	
DESIGN CRITERIA	
TYPE WET	
MINIMUM RATED	1500 GPM
DESIGN RATED	1500 GPM
MINIMUM RATED	150 GPM
DESIGN RATED	100 GPM
MINIMUM RATED	100 GPM
DESIGN RATED	100 GPM

1 SECOND FLOOR PLAN  
A1.03 1/8" = 1'-0"

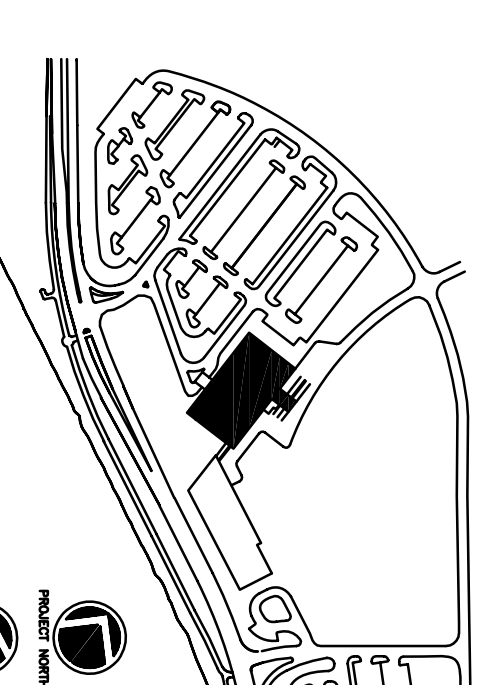

**Consultant**  
 ORTHOPEDIC  
 DeLorenzo-Hoffman Associates, Inc.  
 726 Main Street, Suite 8  
 Philadelphia, PA 19106  
 Phone (207) 775-1211  
 Fax (207) 879-0898

**Consultant**  
 ASSOCIATE ARCHITECT/STRUCTURAL ENGINEER  
 SMRT  
 201 Chestnut Street, Box 618  
 Philadelphia, PA 19106  
 Phone (207) 772-3846  
 Fax (207) 772-1070

**Consultant**  
 MECHANICAL/ELECTRICAL ENGINEER  
 BIRD, BOG & ANDRUS Consulting Engineers, LLC  
 311 Aerial Street  
 Philadelphia, PA 19106  
 Phone (215) 763-2789  
 Fax (215) 763-2789

**Consultant**  
 EQUIPMENT PLANNING  
 1853 General George Patton Drive  
 Franklin, Tennessee 37067  
 Phone (615) 376-3114  
 Fax (615) 376-3114

**Consultant**  
 CONSTRUCTION MANAGER  
 7 Johnson Walkway  
 Philadelphia, PA 19106  
 Phone (401) 456-8999  
 Fax (401) 456-5516

**Consultant**  
 Interior  
 Simon Soderstrom, LLC  
 1808 West End Ave Suite 1400  
 Philadelphia, PA 19106  
 Phone (610) 321-5591  
 Fax (610) 321-5889

Date  
 11/10/06 Final-Issued for Construction  
 Drawn By  
 MF  
 Scale  
 1/8" = 1'-0"

**Francis**

**Cauffman**

**Foley**

**Hoffmann**  
 Francis, Goldstein  
 & Foley Hoffmann  
 Architects Ltd.  
 2129 Arch Street  
 Philadelphia, PA 19103  
 215-568-8250

**Project Title**  
 Mercy Health Core  
 System of Maine  
 FORE RIVER SHORT  
 STAY HOSPITAL



**Project Number**  
 F05-4898  
**Drawing Title**  
 LEVEL 2 FLOOR PLAN  
**FP1.02**