

Consultant  
Dillon-Hoffmann  
Dillon-Hoffmann Associates, Inc.  
705 Main Street, Suite 8  
Baltimore, MD 21201  
Phone: (410) 775-1121  
Fax: (410) 775-0888

Consultant  
ASSOCIATE ARCHITECT/STRUCTURAL ENGINEER  
SHEPHERD HUNTER  
One State Pk., Box 618  
Pottersville, MD 21134  
Phone: (207) 772-3846  
Fax: (207) 772-1070

Consultant  
MECHANICAL/ELECTRICAL ENGINEER  
Bord, Sooy & Aronson Consulting Engineers, LLC  
311 Arsenal Street  
Middleton, VT 05750-2789  
Phone: (802) 244-0017  
Fax: 817/924/9339

Consultant  
EQUIPMENT PLANNING  
SHEPHERD HUNTER  
1803 General George Patton Drive  
Franklin, Tennessee 37067  
Phone: (615) 276-3114  
Fax: (615) 276-3114

Consultant  
CONSTRUCTION MANAGER  
7 Johnson-Walshway  
Providence, RI 02903  
Phone: (401) 456-8998  
Fax: (401) 456-5516

Consultant  
Francis  
Francis  
1808 West End Ave. Suite 1400  
Nashville, TN 37203  
Phone: (615) 321-5591  
Fax: (615) 321-5889

Consultant  
Coffman  
Coffman  
11/10/06 Final-Issued for Construction


Scale  
1/8" = 1'-0"

Drawn By  
NJP

Date  
11/10/06 Final-Issued for Construction

Project Title  
Mercy Health Core  
System of Maine  
FORE RIVER SHORT  
STAY HOSPITAL

Project Location  
2120 Ash Street  
Philadelphia, PA 19103  
Phone: (215) 568-8250

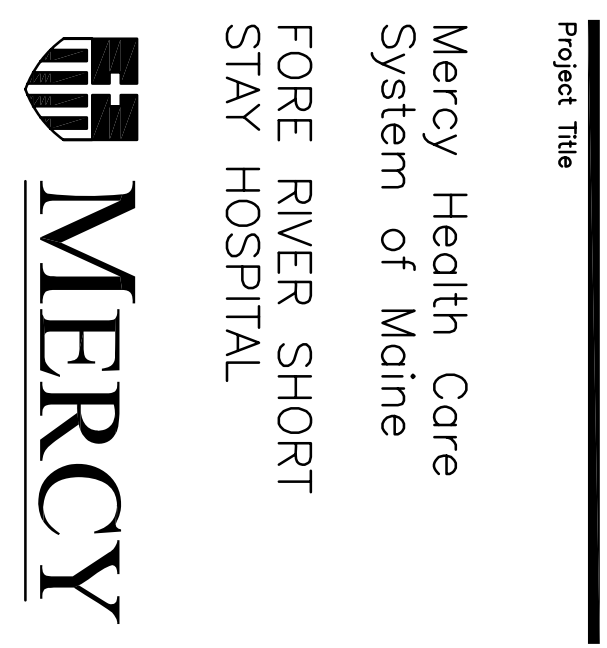

Project Number  
F05-4898  
Drawing Title  
PLUMBING  
LEVEL 3 FLOOR PLAN  
DRAINAGE  
P1.03

