

Consultant
Civil Engineer
Delaney-Hoffmann Associates, Inc.
726 Main Street, Suite 8
Portland, ME 04106
Phone: (207) 775-1121
Fax: (207) 879-0888

Consultant
ASSOCIATE ARCHITECT/STRUCTURAL ENGINEER
SMART
One Grand St., Box 618
Portland, Maine 04104
Phone: (207) 772-3846
Fax: (207) 772-1070

Consultant
MECHANICAL/ELECTRICAL ENGINEER
BIRD, BOG & AUSTON Consulting Engineers, LLC
1100 North Street, Suite 200
311 Aerial Street
Portland, ME 04101
Phone: (207) 724-6011
Fax: 617/924-9339

Consultant
EQUIPMENT PLANNING
LAW
183 General George Patton Drive
Franklin, Tennessee 37067
Phone: (615) 376-3114
Fax: (615) 376-3114

Consultant
CONSTRUCTION MANAGER
7 Johnson Way
Portland, ME 04106
Phone: (401) 486-8998
Fax: (401) 486-5516

Consultant
Iron Solutions, LLC
1808 West End Ave. Suite 1400
Portland, ME 04102
Phone: (615) 321-5591
Fax: (615) 321-5889

It is the responsibility of the Commissioning Manager/Control Contractor and all other accept conditions of prior work by related trades before proceeding with any work.

Date: 11/10/06 Final-Issued for Construction

Drawn By: NLP

Scale: 1/8" = 1'-0"

Francis


Cauffman

Foley

Hoffmann

Project: 2129 Ash Street
Philadelphia, PA 19103
215-588-8250
Architect Ltd.

Project Title: Mercy Health Core
System of Maine
FORE RIVER SHORT
STAY HOSPITAL

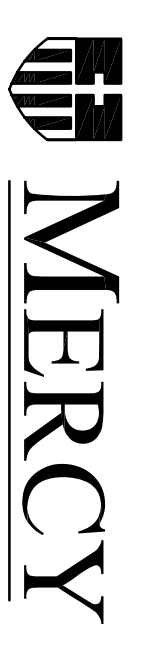

Project Number: F05-4898

Drawing Title: Drawing the end Number
PLUMBING
LEVEL 4 FLOOR PLAN
SUPPLY
P2.04

