
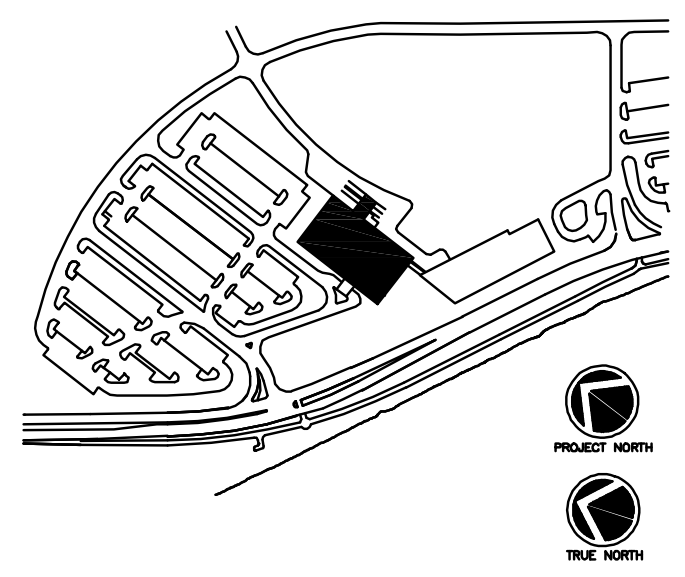


**KEY NOTES:**

- IN ADDITION TO THE POWER INDICATED IN THESE ROOMS, ELECTRICAL CONTRACTOR SHALL REFER TO MANUFACTURERS' INSTALLATION DRAWINGS FOR EQUIPMENT INCLUDING BUT NOT LIMITED TO WIREWAYS, LIGHTS, DOOR INTERLOCKS, EPO'S, POWER AND CONTROL WIRING, CONDUIT, ETC. FOR A COMPLETE INSTALLATION.
- PROVIDE A JUNCTION BOX WITH EMERGENCY CIRCUITS FOR USE BY THE ATC CONTRACTOR. COORDINATE LOCATION WITH ATC.

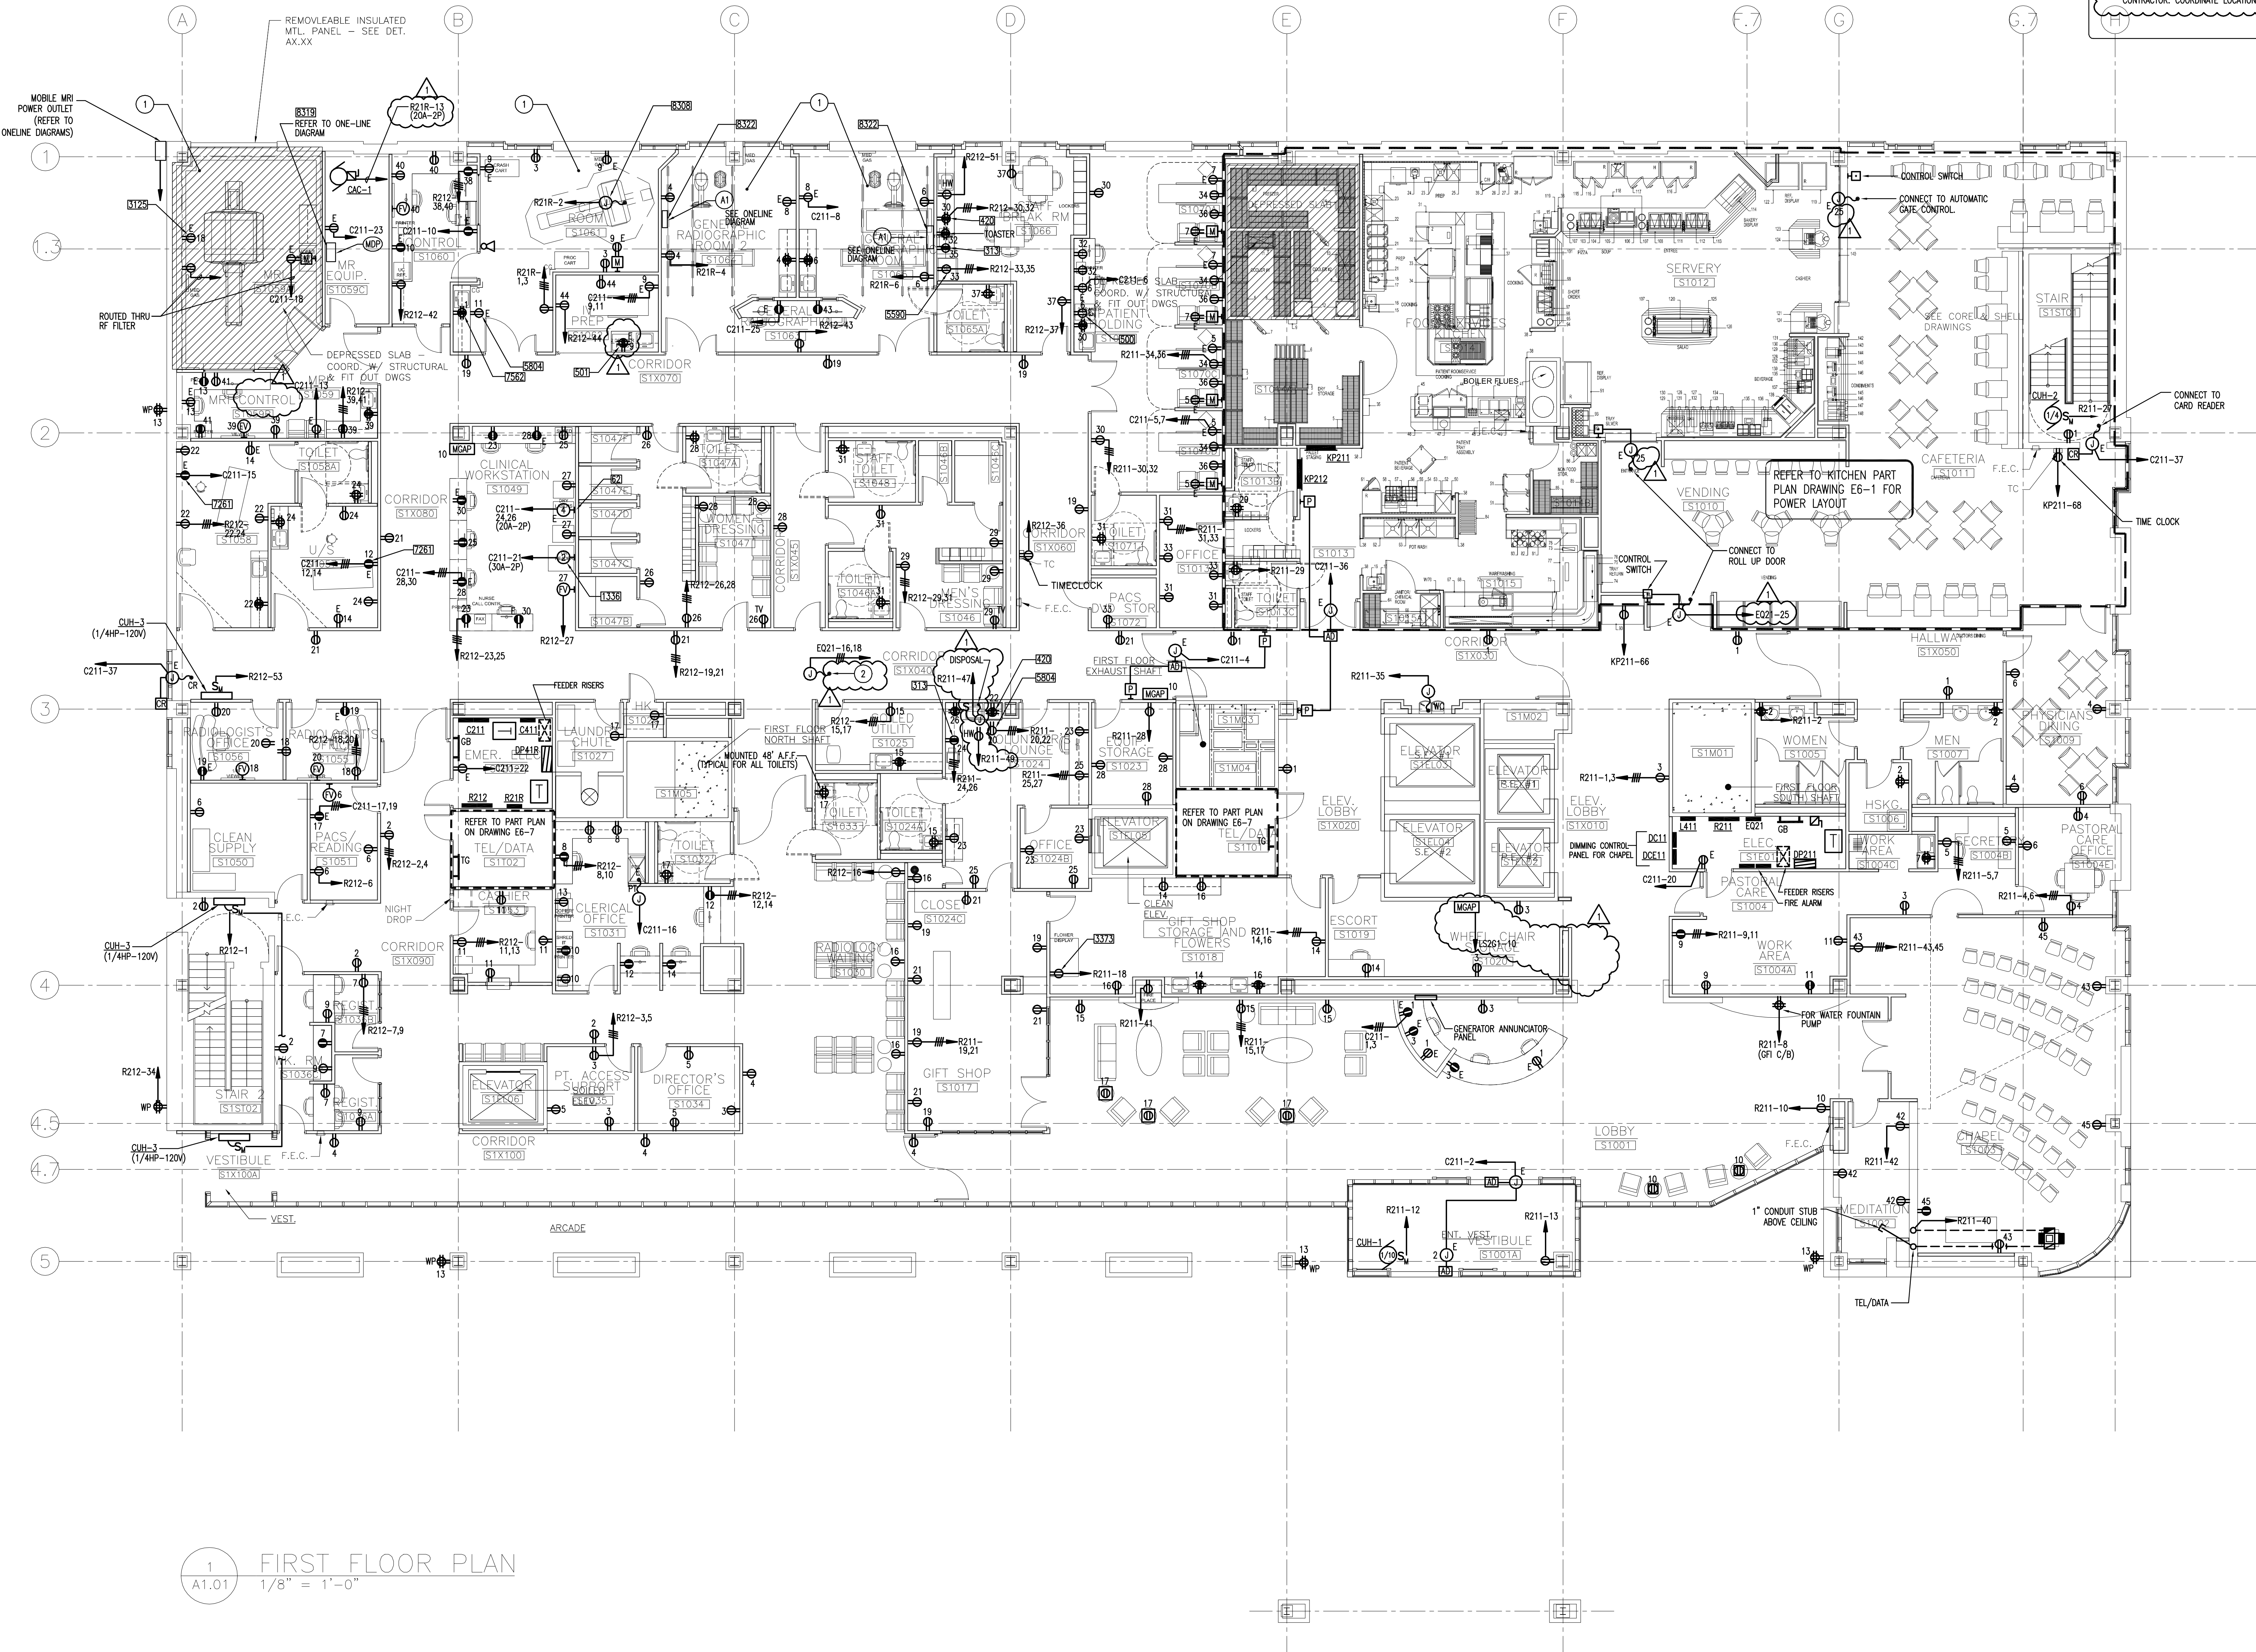

- Consultant  
 CIVIL ENGINEER  
 DeLucco-Hoffman Associates, Inc.  
 778 Main Street, Suite 8  
 South Portland, ME 04106  
 Phone: (207) 775-1121  
 Fax: (207) 772-0896
- Consultant  
 ASSOCIATE ARCHITECT/STRUCTURAL ENGINEER  
 SMRT  
 144 Fore Street P.O. Box 618  
 Portland, Maine 04104  
 Phone: (207) 772-3846  
 Fax: (207) 772-1070
- Consultant  
 MECHANICAL/ELECTRICAL ENGINEER  
 Bord, Rao + Athanas Consulting Engineers, LLC  
 The Arsenal on the Charles  
 311 Arsenal Street  
 Watertown, MA 02472-5789  
 Phone: 617.254.0016  
 Fax: 617.924.9339
- Consultant  
 EQUIPMENT PLANNING  
 Gene Burton & Associates  
 1893 General George Patton Drive  
 Franklin, Tennessee 37067  
 Phone: (615) 376-3100  
 Fax: (615) 376-3114
- Consultant  
 CONSTRUCTION MANAGER  
 Gilbane Building Company  
 7 Jackson Walkway  
 Providence, Rhode Island 02903  
 Phone: (401) 456-5905  
 Fax: (401) 456-5516
- Consultant  
 FOOD SERVICE  
 Inman Foodservice, LLC  
 1808 West End Ave. Suite 1400  
 Nashville, TN 37203  
 Phone: (615) 321-5591  
 Fax: (615) 321-5689
- It is the responsibility of the Construction Manager/General Contractor and all Sub-Contractors to verify all dimensions and accept conditions of prior work by related trades before proceeding with any work.

Date  
 11/10/06 Final-Issued for Construct  
 Drawn By

Scale  
 1/8" = 1'-0"

Francis  
 Cauffman  
 Foley  
 Hoffmann

Francis Cauffman 2120 Arch Street  
 Foley Hoffmann Philadelphia, PA 19103  
 Architects Ltd. 215-568-8250

Project Title  
 Mercy Health Care  
 System of Maine  
 FORE RIVER SHOT  
 STAY HOSPITAL



Project Number  
 F05-4898  
 Drawing Title and Number  
 ELECTRICAL  
 POWER PLAN  
 LEVEL 1

J:\JOBS\2523000\DWG\ELEC\ONE-PWR-LEVEL 1.DWG 11-16-2006 15:37:35 - .lwd

1 FIRST FLOOR PLAN  
 A1.01 1/8" = 1'-0"