

- Consultant  
 CIVIL ENGINEER  
 DeLuca-Hoffman Associates, Inc.  
 778 Main Street, Suite 8  
 South Portland, ME 04106  
 Phone: (207) 775-1121  
 Fax: (207) 879-0896
- Consultant  
 ASSOCIATE ARCHITECT/STRUCTURAL ENGINEER  
 SMRT  
 144 Fore Street P.O. Box 618  
 Portland, Maine 04104  
 Phone: (207) 772-3846  
 Fax: (207) 772-1070
- Consultant  
 MECHANICAL/ELECTRICAL ENGINEER  
 Bord, Rao + Athanas Consulting Engineers, LLC  
 The Arsenal on the Charles  
 311 Arsenal Street  
 Watertown, MA 02472-5789  
 Phone: 617.254.0016  
 Fax: 617.924.9339
- Consultant  
 EQUIPMENT PLANNING  
 Gene Burton & Associates  
 1893 General George Patton Drive  
 Franklin, Tennessee 37067  
 Phone: (615) 376-3100  
 Fax: (615) 376-3114
- Consultant  
 CONSTRUCTION MANAGER  
 Gilbane Building Company  
 7 Jackson Walkway  
 Providence, Rhode Island 02903  
 Phone: (401) 456-5905  
 Fax: (401) 456-5516
- Consultant  
 FOOD SERVICE  
 Inman Foodservice, LLC  
 1808 West End Ave, Suite 1400  
 Nashville, TN 37203  
 Phone: (615) 321-5591  
 Fax: (615) 321-5688
- It is the responsibility of the Construction Manager/General Contractor and all Sub-Contractors to verify all dimensions and accept conditions of prior work by related trades before proceeding with any work.

Date  
 11/10/06 Final-Issued for Construction  
 Drawn By

Scale  
 1/8" = 1'-0"

Francis  
 Cauffman  
 Foley  
 Hoffmann

Francis Cauffman 2120 Arch Street  
 Foley Hoffmann Philadelphia, PA 19103  
 Architects Ltd. 215-568-8250


Project Title  
 Mercy Health Care  
 System of Maine  
 FORE RIVER SHORT  
 STAY HOSPITAL



Project Number  
 F05-4898  
 Drawing Title and Number  
 ELECTRICAL  
 POWER PLAN  
 LEVEL 4

E1-4

FOOD SERVICE S4036--SCHEDULE OF EQUIPMENT							
ITEM	DESCRIPTION	LOAD HP KW	AMP	VOLTAGE	CIRCUIT BREAKER	CONNECTION PLUG-IN DIRECT	NOTES
E1	REFRIGERATOR/FREEZER	1/5-1/3	14A	120V	20A-1P	●	C241-76 2#12 & 1#12G-3/4°C
E2	ICE/WATER DISPENSER	-	12A	120V	20A-1P	●	C241-78 2#12 & 1#12G-3/4°C
E3	ICED TEA BREWER	-	15A	120V	20A-1P	●	KP24-1 2#12 & 1#12G-3/4°C
E4	COFFEE BREWER	-	30A	120/208-1P	30A-2P	●	KP24-2,4 3#10 & 1#10G-3/4°C
E5A	CONVENIENCE OUTLET	-	16A	120V	20A-1P	●	KP24-3 2#12 & 1#12G-3/4°C
E5B	CONVENIENCE OUTLET	-	16A	120V	20A-1P	●	KP24-5 2#12 & 1#12G-3/4°C
E6	MICROWAVE OVEN	1.2	10.0A	120V	20A-1P	●	KP24-7 2#12 & 1#12G-3/4°C
E7	SODA DISPENSER	-	10A	120V	20A-1P	●	KP24-9 2#12 & 1#12G-3/4°C
E8	AMBIENT CARBONATOR	-	7A	120V	20A-1P	●	KP24-11 2#12 & 1#12G-3/4°C
E9A	REFER TO COMMUNICATION DRAWINGS	-	-	-	-	-	-
E10A	CONVENIENCE OUTLET	-	16A	120V	20A-1P	●	KP24-6 2#12 & 1#12G-3/4°C
E10B	CONVENIENCE OUTLET	-	16A	120V	20A-1P	●	KP24-8 2#12 & 1#12G-3/4°C
E11	E.C. TO PROVIDE EMPTY CONDUIT W/JUNCTION BOX FOR OWNER SUPPLIED POS/COMPUTER SYSTEM. VERIFY REQUIREMENTS AND LOCATION WITH OWNER/ARCH.	-	-	-	-	-	-

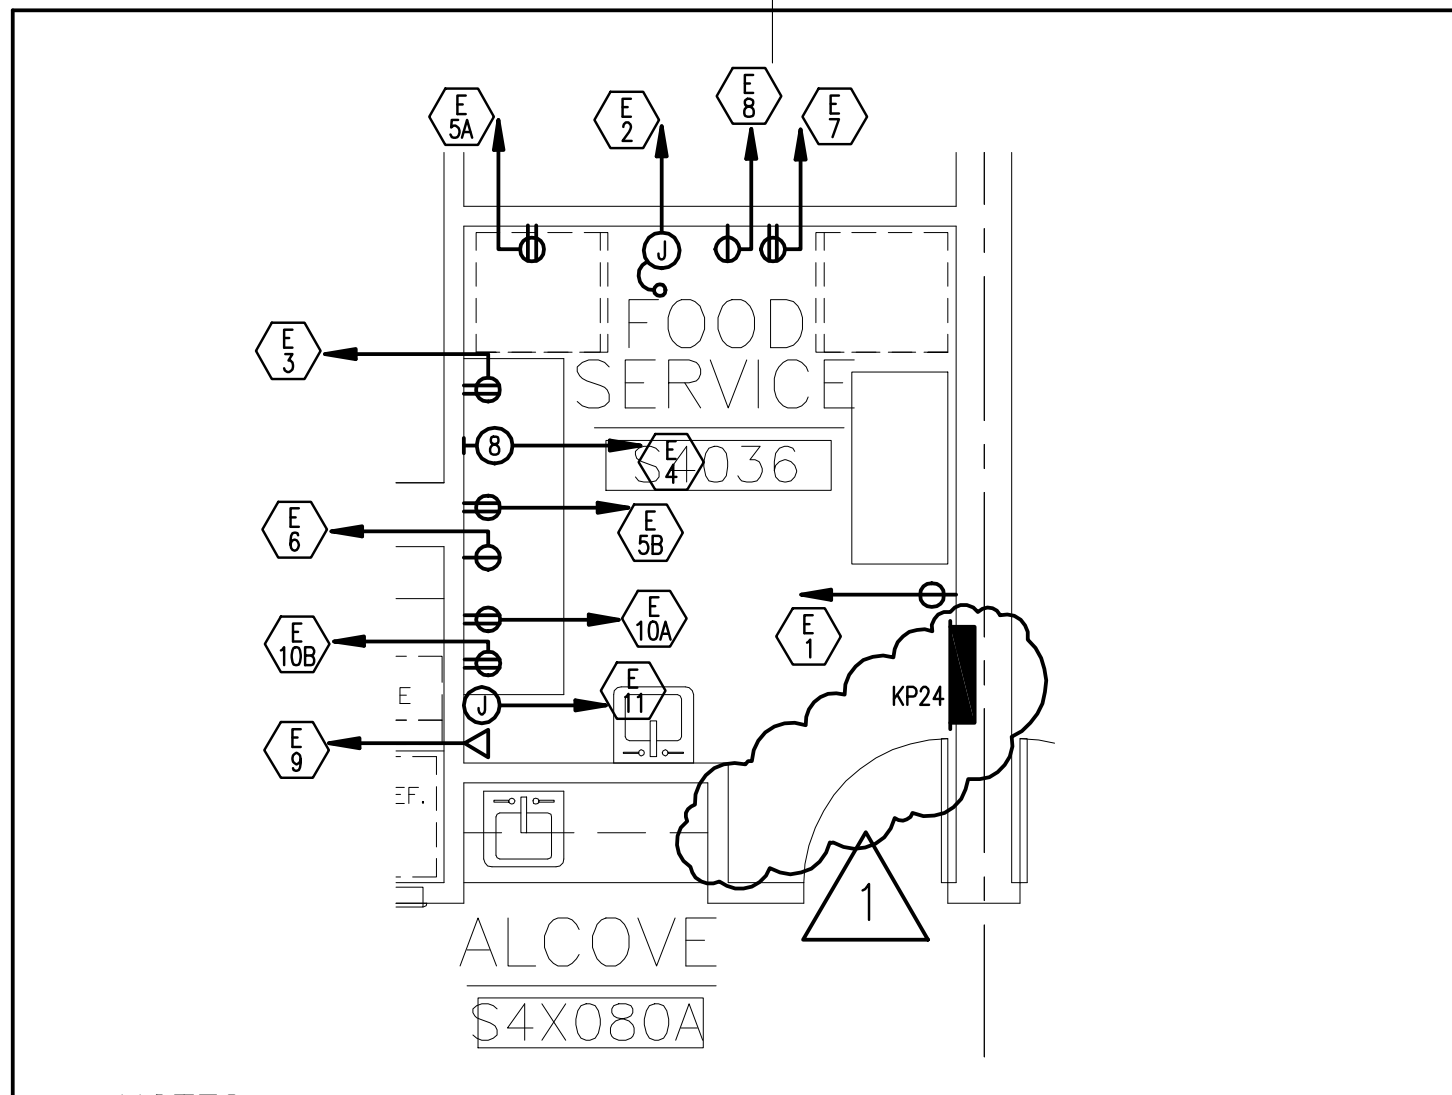

NOTES:  
 1. FOR KITCHEN EQUIPMENT EXACT LOCATION, MOUNTING HEIGHTS AND CONNECTIONS REQUIREMENTS, REFER TO KITCHEN CONSULTANT 'INMAN FOODSERVICES GROUP' DOCUMENTS.

FOOD SERVICE S3041 PART PLAN-POWER 1/4"=1'-0"

KEY NOTES:  
 1. PROVIDE A JUNCTION BOX WITH EMERGENCY CIRCUITS FOR USE BY THE ATC CONTRACTOR. COORDINATE LOCATION WITH ATC.