


**IN-FLOOR ELECTRICAL SERVICE BOXES**

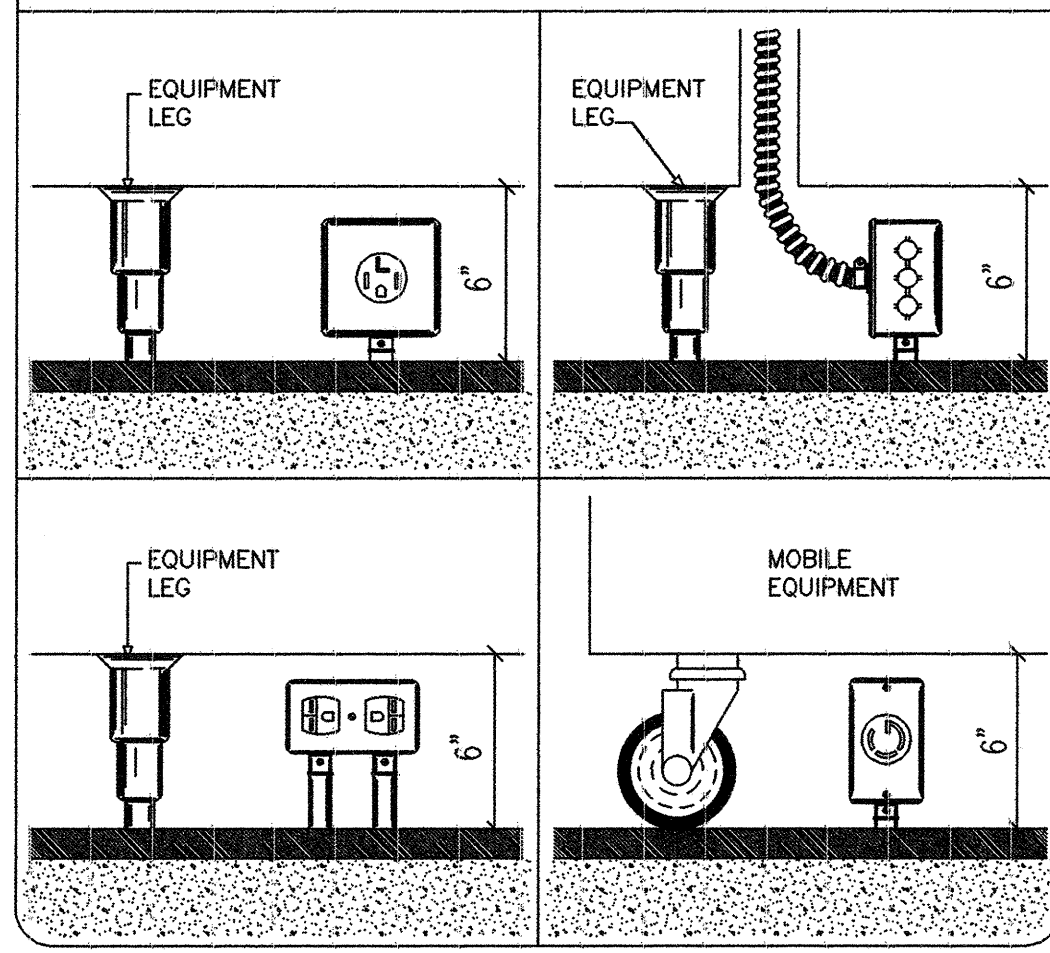

E.C. TO PROVIDE FIVE (5) WIRES AND CONDUIT BETWEEN UNIT BLOWER COIL AND REMOTE COMPRESSOR FOR FAN POWER, DEFROST AND REQUIRED CONTROL WIRING. SIZE WIRE TO HANDLE 22.0 AMPS.

NOTE: E.C. TO PROVIDE ANY INTERCONNECTS FROM THE SUPPLY TO EXHAUST HOODS AS REQUIRED.

NOTE: ELECTRICAL REQUIREMENTS FOR OFFICE TO BE DETERMINED BY ARCHITECT/ENGINEERS.


NOTE: E.C. TO COORDINATE WITH ARCHITECT/OWNER FOR DATA LOCATIONS.

POWER REQUIREMENTS FOR THE VENDING MACHINES ARE TO BE DETERMINED BY THE ARCHITECT/ENGINEERS/VENDOR.

NOTE: THIS DRAWING INDICATES THE GENERAL EXTENT OF THE WORK AND IS NOT INTENDED TO INDICATE OR DESCRIBE ANY AND ALL WORK REQUIRED FOR THE FULL PERFORMANCE AND COMPLETION OF THE REQUIREMENTS OF THE CONTRACT DOCUMENTS.

**FINAL - ISSUED FOR CONSTRUCTION**

**Inman Foodservices Group, LLC**  
 MIAMI  
 1330 Coral Way  
 Miami, Florida  
 33145-3145  
 (305) 559-2025

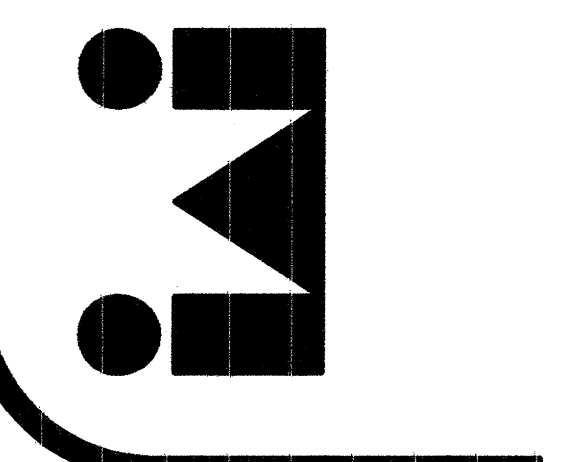

**EMR**  
 Phone (603)-864-2886  
 Fax (603)-864-5100  
 4140 HWY. 30 West  
 Amherst, KY 40402  
 Web Address: emrinc.com

Project:  
**MERCY HEALTH SYSTEM OF MAINE  
 PORTLAND, MAINE**

Revisions:  
 Job Number: 04166  
 Date: 03-19-2007  
 Drawn By: STAFF  
 Checked By: STAFF  
 SCALE: 1/4" = 1'-0"

**ELECTRICAL PLAN**

Sheet **FS-1.3**