

**Francis
Cautfman
Foley
Hoffmann**

Francis Cautfman 2120 Arch Street
Portland, ME 04103
Architects Ltd. 215-588-8250

STRUCTURAL ENGINEERS
FRANCIS CAUTFMAN & ASSOCIATES
195 COLLEGE AVENUE
SUITE 175
PORTLAND, ME 04103
P (603) 645-9572
F (610) 645-9572

M/E/P ENGINEER
FRANCIS CAUTFMAN & ASSOCIATES
1500 MARKET STREET, SUITE 1400
PHILADELPHIA, PA 19102
P 215-252-2106
F 215-252-2106

Revisions
11-20-06 CONSTRUCTION DOCUMENTS ISSUED

Sheet
SECOND FLOOR REFLECTED
CEILING PLAN

Project Title
Landmark Healthcare
Facilities LLC
Fore River Medical
Pavilion
Portland, Maine

Date
NOVEMBER 20, 2006

 
 






 
 


 

 




 



 
 
Project Number
FO6-5103

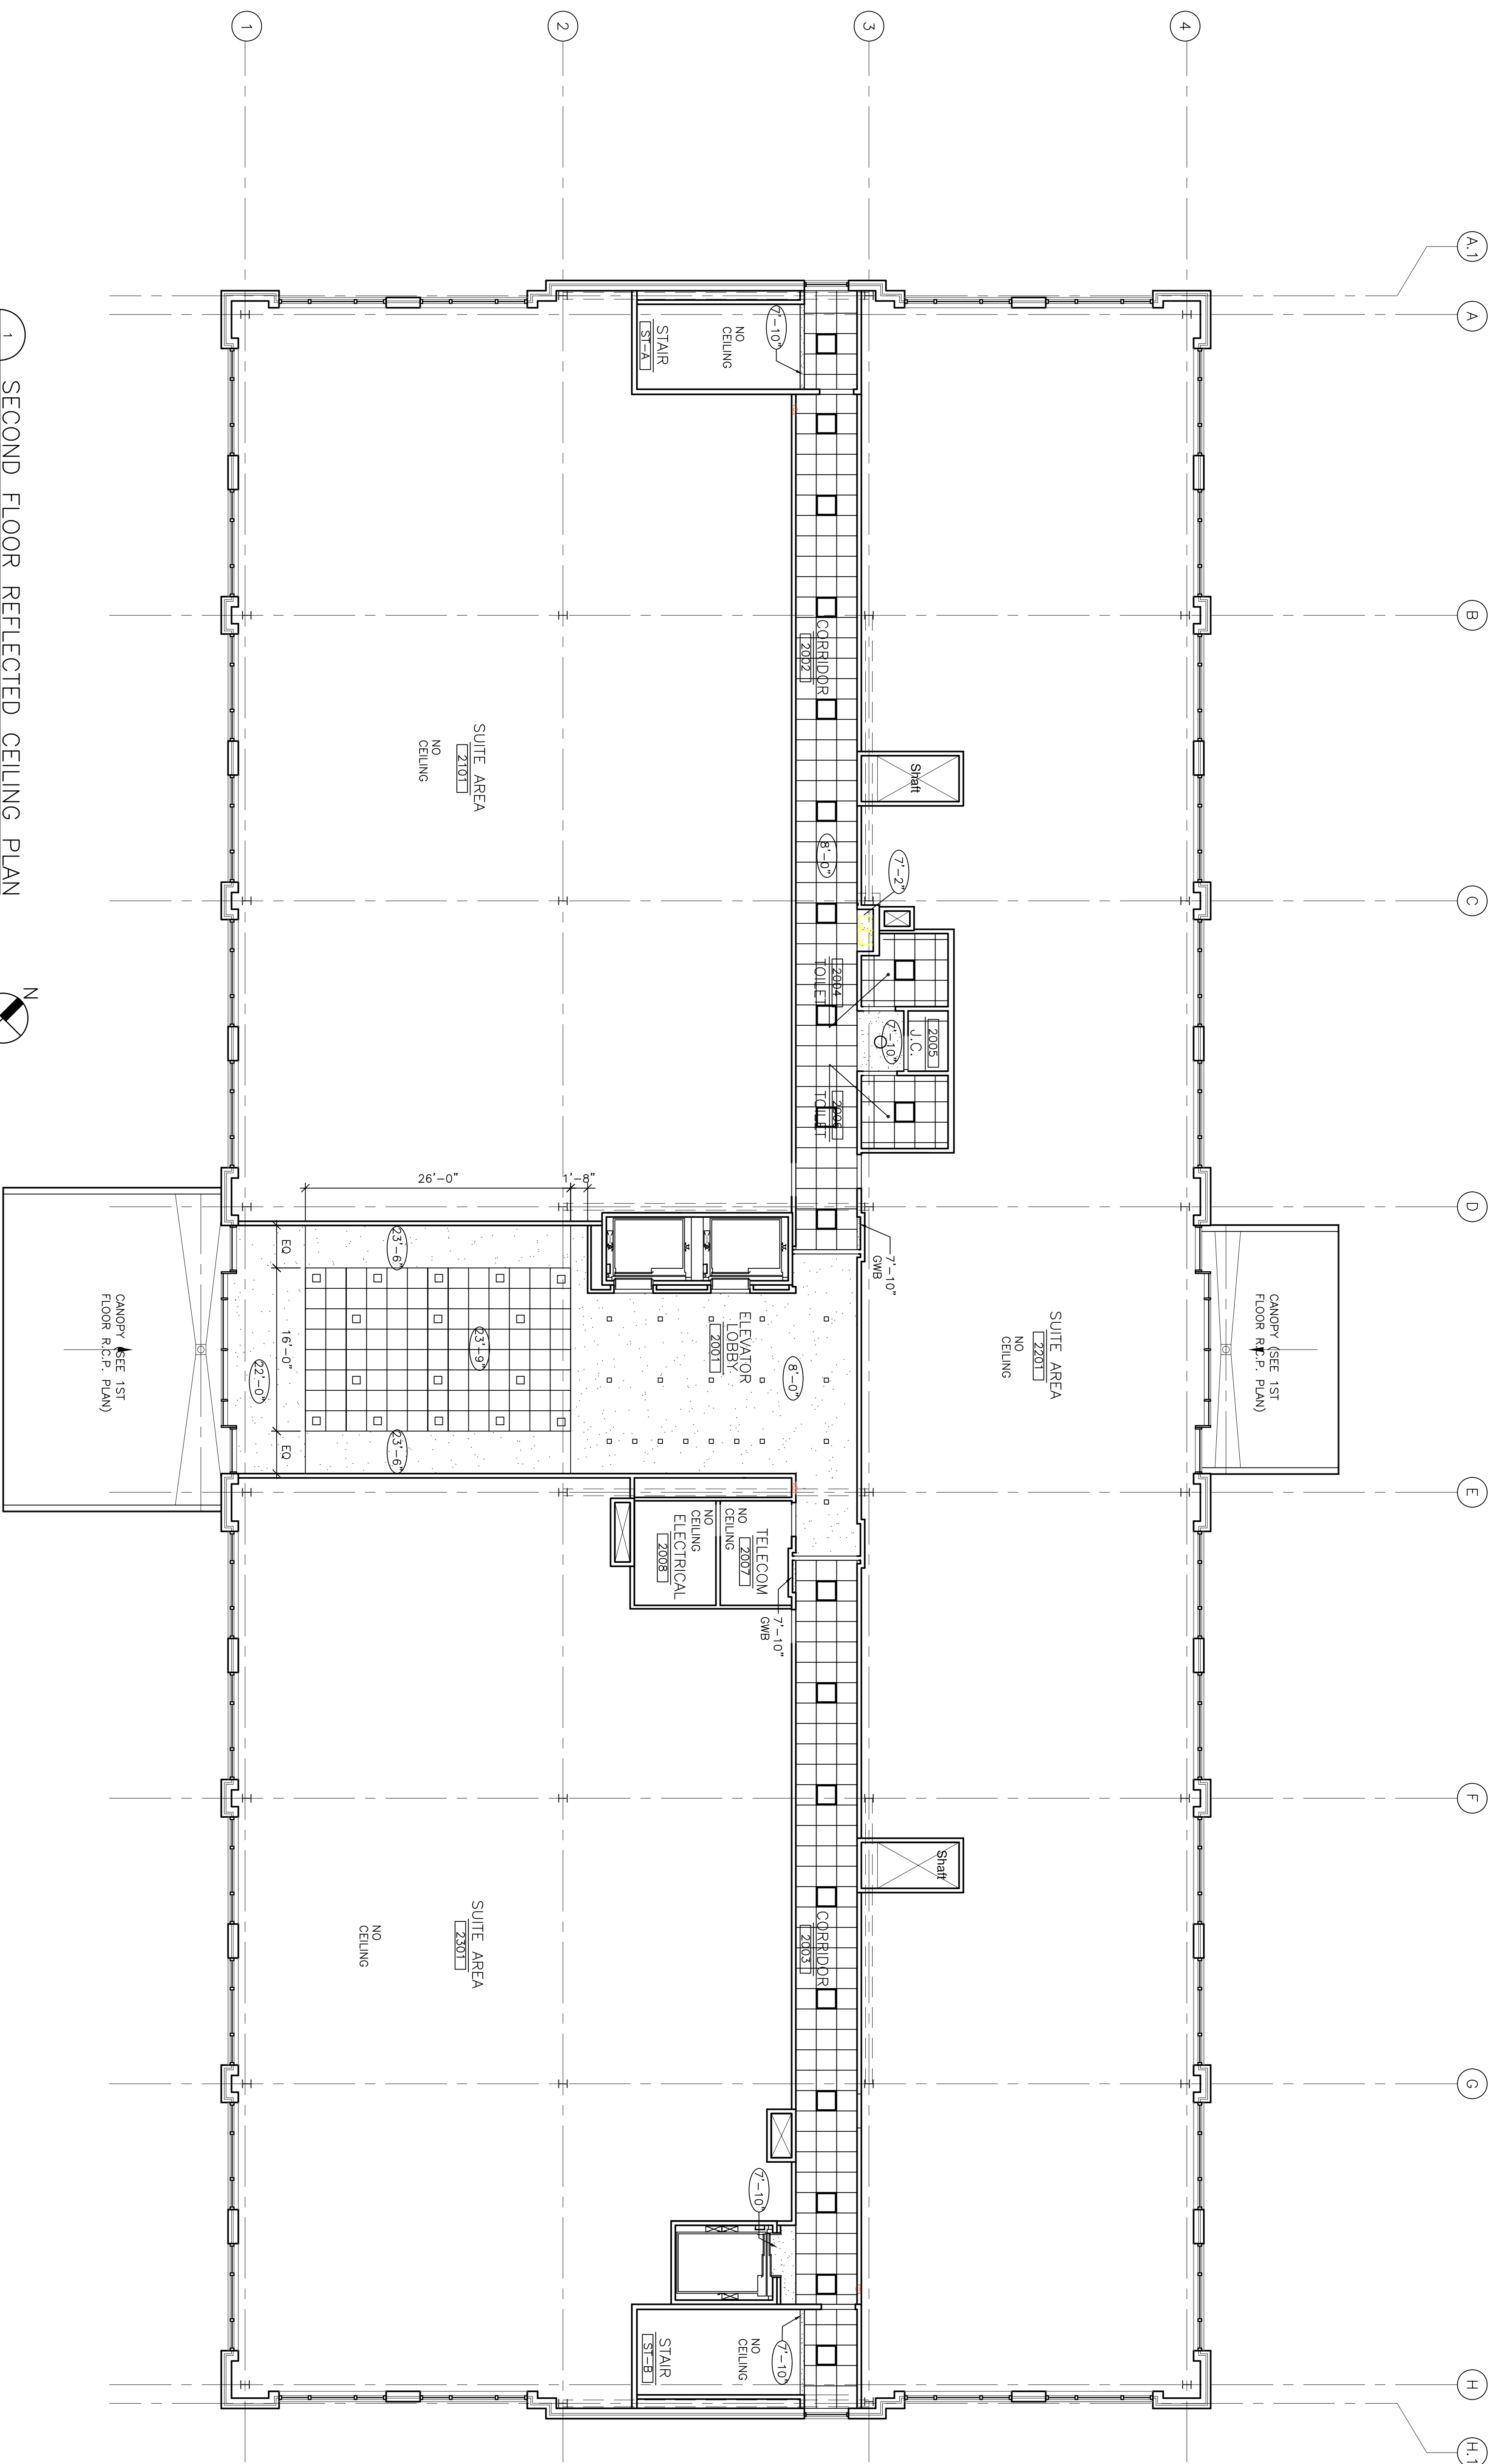
Drawing Number

A5.02

CEILING NOTES

1. CLG HT: 8'-0" AFF UNO.
2. CEILING DEVICES SHOWN ARE FOR INFORMATION AND AESTHETIC PURPOSES ONLY. COORDINATE ALL DEVICES WITH MECHANICAL, ELECTRICAL, AND PLUMBING CONTRACTORS. SPRINKLERS, FIRE ALARM STATIONS & EXT SIGNS WITH MEP DRAWINGS.

CEILING FINISH LEGEND	
	EXP. EXPOSED
	NO FINISH CEILING
	ACT CEILING GRID
	PTD GWB CEILING
CEILING SYMBOL LEGEND	
	2'x4' REC. INDIRECT/DIRECT FLOOR.
	2'x2' REC. INDIRECT/DIRECT FLOOR.
	CUBICAL CURTAIN TRACK
	WALL WASHER
	DOWNLIGHT
	SKY DOME LIGHT
	PENDANT LIGHT
	COVE LIGHT
	SCONCE
	NURSE CALL LANTERN
	CEILING HEIGHT
	6'x4' LINEAR DIFFUSER
	ACCESS PANEL
	SMOKE DETECTOR
	SPEAKER
	EXHAUST FAN
	2'X2' MECH. SUPPLY REGISTER
	2'X2' MECH. RETURN REGISTER
	ACCESS PANEL
	EXIT SIGN
	SPRINKLER HEAD



1 SECOND FLOOR REFLECTED CEILING PLAN
1/8"=1'-0"

