

**Francis
Caufman
Foley
Hoffmann**

Francis Caufman
 2120 Arch Street
 Philadelphia, PA 19103
 Architects Ltd.
 215-566-8250

STRUCTURAL ENGINEER
 RISE CONSULTING ASSOCIATES
 109 COLLEGE AVENUE
 SUITE 175 PA 19023
 PHILADELPHIA, PA 19106
 P (610) 445-8970
 F (610) 845-9572

M/E/P ENGINEER
 RISE CONSULTING ASSOCIATES
 1500 MARKET STREET, SUITE 1400
 PHILADELPHIA, PA 19102
 P 215-252-2106
 F 215-252-2106

Revisions
 11-20-08 CONSTRUCTION DOCUMENTS ISSUED

Sheet
 THIRD FLOOR REFLECTED CEILING PLAN

Project Title
**Landmark Healthcare
Facilities LLC**
 Fore River Medical
 Pavilion
 Portland, Maine

Date
 NOVEMBER 20, 2008

 
 
 
 



 
 
 

 
 
 
 
 
 


 
 
 
 
 
Project Number
 F06-5103

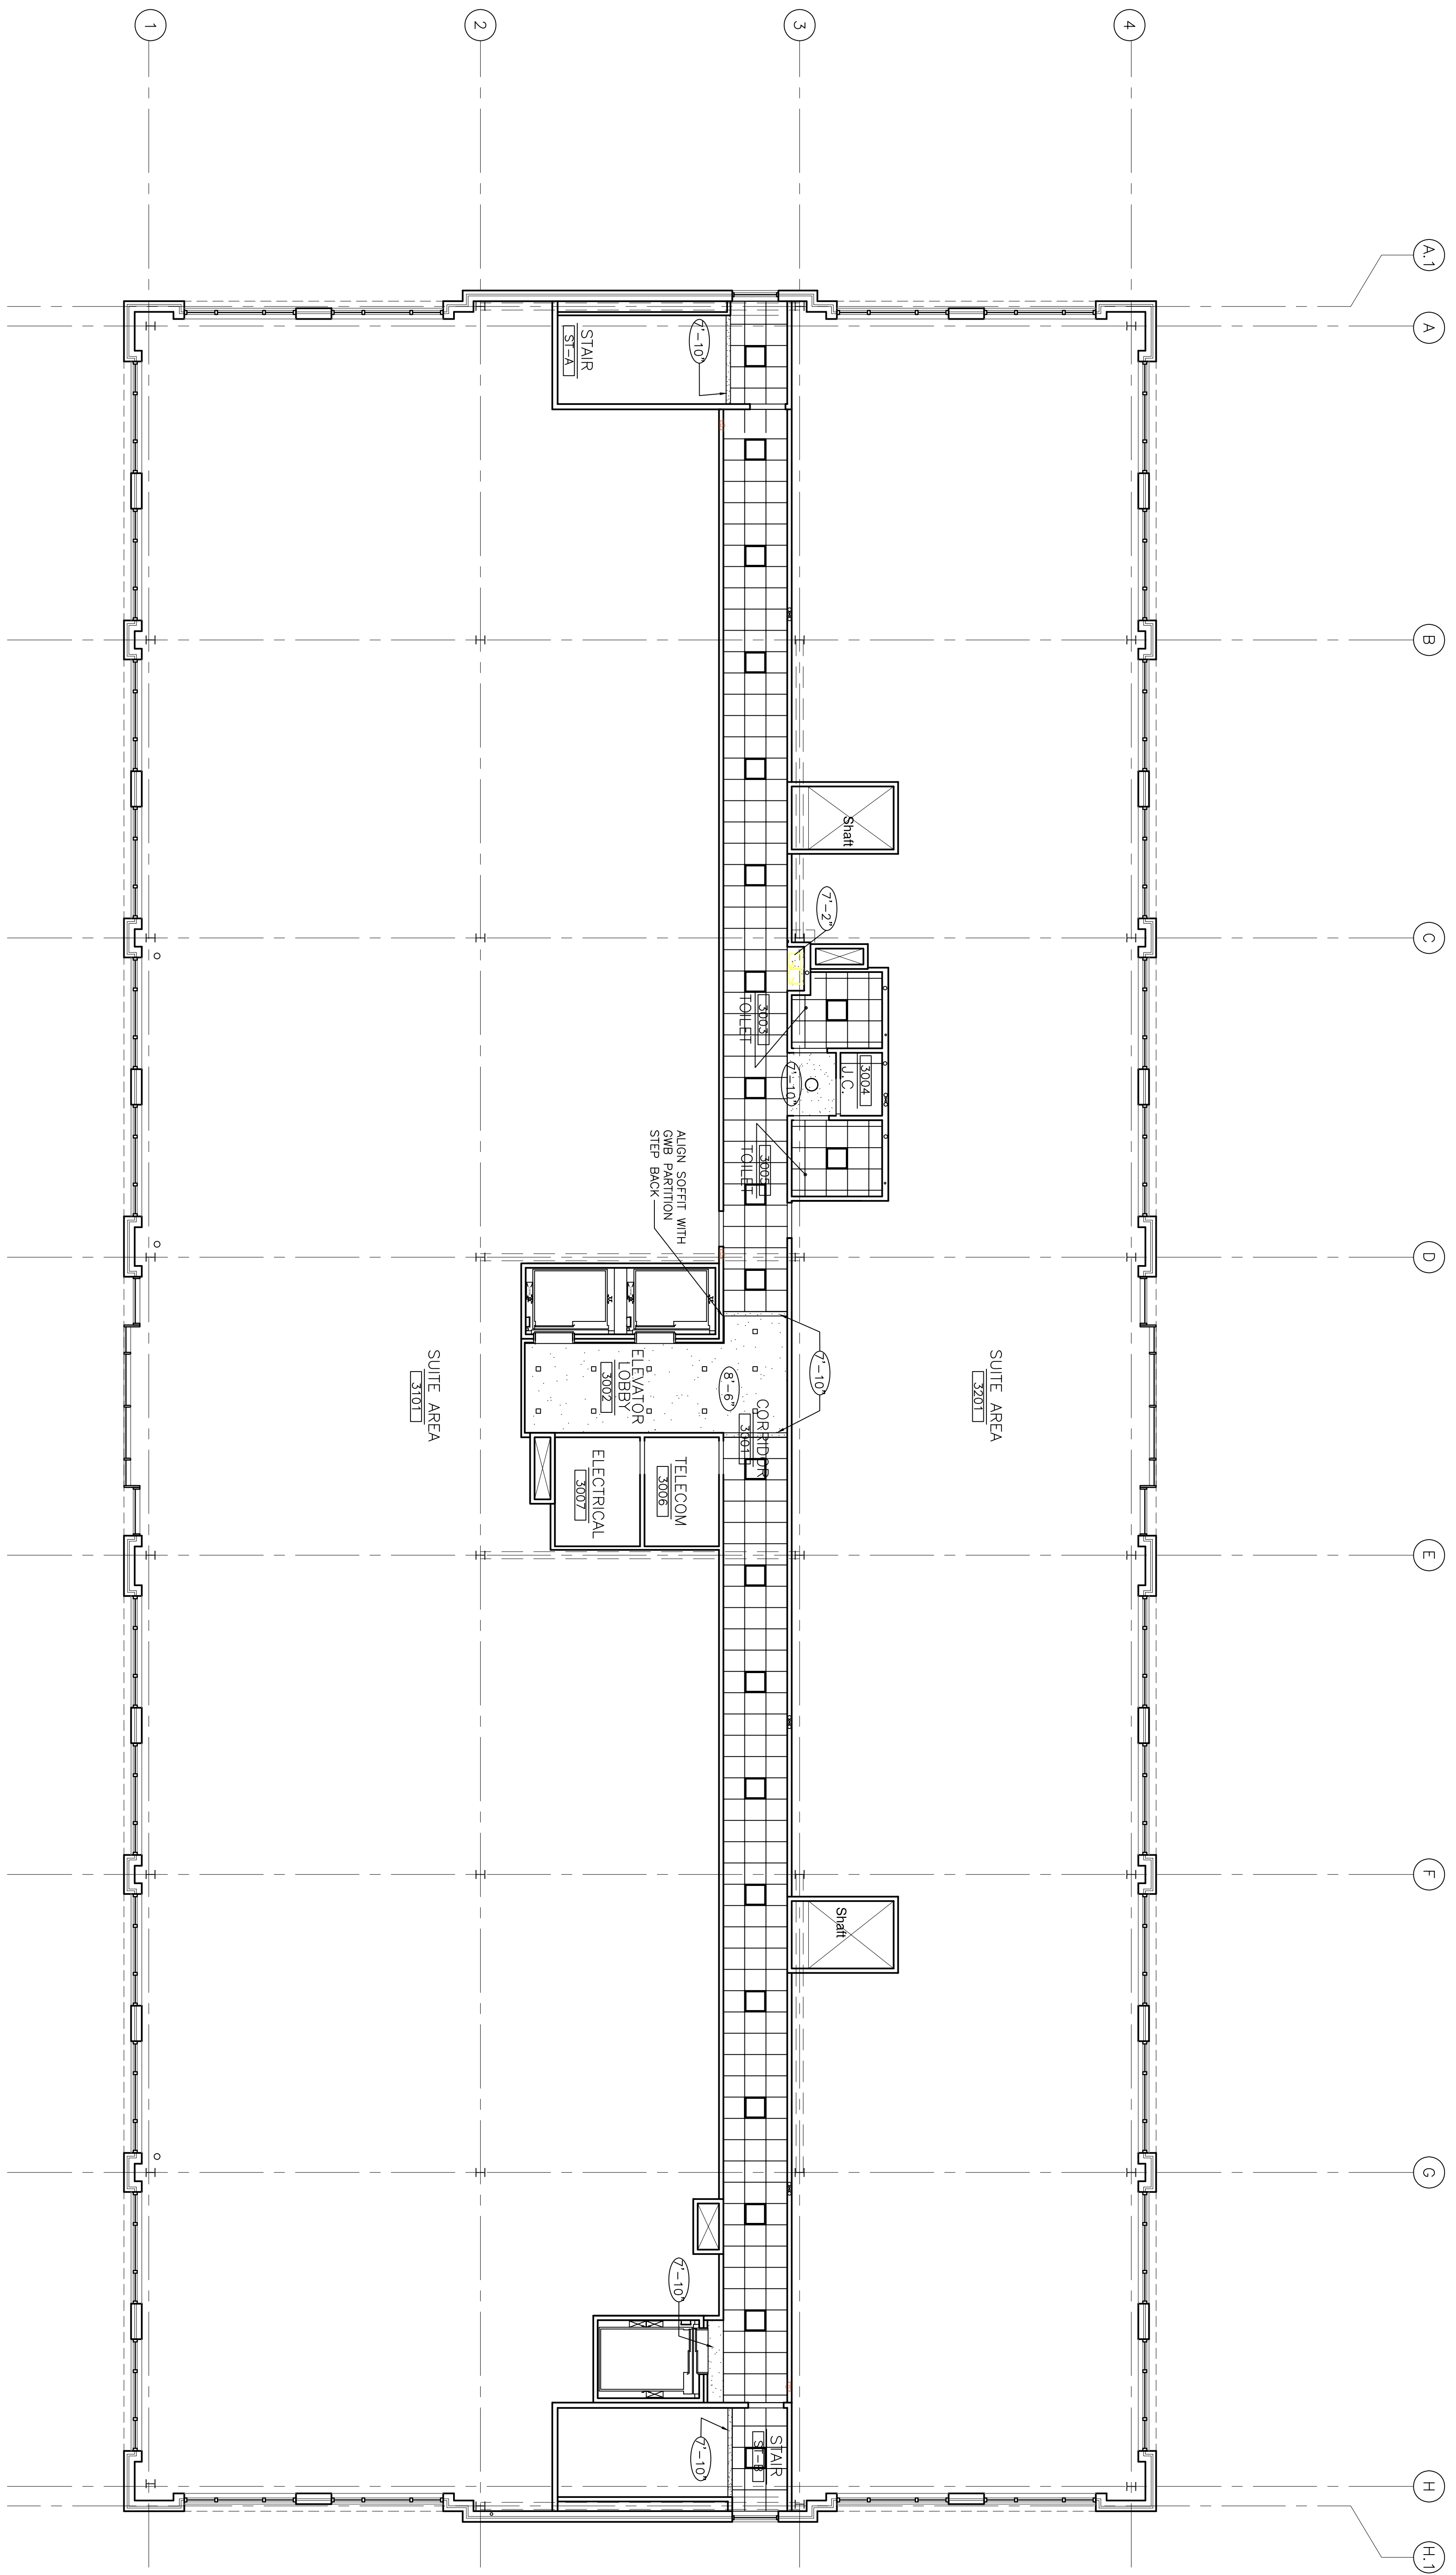
Drawing Number

A5.03

CEILING NOTES

1. CLG HT: 8'-0" AFF UNO.
2. CEILING DEVICES SHOWN ARE FOR INFORMATION AND AESTHETIC PURPOSES ONLY. COORDINATE ALL LIGHTING FIXTURES, DIFFUSERS, SMOKE DETECTORS, SPRINKLERS, FIRE ALARM STATIONS & EXIT SIGNS WITH MEP DRAWINGS.

CEILING FINISH LEGEND	
	NO FINISH CEILING
	ACT CEILING GRID
	PTD GMB CEILING
CEILING SYMBOL LEGEND	
	2"x4" REC. INDIRECT/DIRECT FLUOR.
	2"x2" REC. INDIRECT/DIRECT FLUOR.
	CUBICAL CURTAIN TRACK
	WALL WASHER
	DOWNLIGHT
	SKY DOME LIGHT
	PENDENT LIGHT
	COVE LIGHT
	SCOUCHE
	NURSE CALL LANTERN
	CEILING HEIGHT
	6"x4" LINEAR DIFFUSER
	ACCESS PANEL
	SMOKE DETECTOR
	SPEAKER
	EXHAUST FAN
	2'X2' MECH. SUPPLY REGISTER
	2'X2' MECH. RETURN REGISTER
	ACCESS PANEL
	EXIT SIGN
	SPRINKLER HEAD



1 THIRD FLOOR REFLECTED CEILING PLAN
 A5.03 1/8"=1'-0"

