

Francis

Cauffman

Foley

Hoffmann

Francis Cauffman 2120 Arch Street
Portland, Maine 04103
Telephone: (414) 277-4500
Architects Ltd. 215-588-8260

STRUCTURAL ENGINEER
RICE COLLEGE ENGINEERS ASSOCIATES
100 COLLEGE AVENUE
SUITE 175
PORTLAND, MAINE 04103
P (610) 645-8570
F (610) 645-9572

M/E/P ENGINEER

AKF

engineers
AKF
215 WESTERN BLVD., SUITE 1400
PHILADELPHIA, PA 19103
TEL: (215) 563-1000
FAX: (215) 563-1001
ANNAPOLIS - NEW YORK - PHILADELPHIA
PRINCETON - STAMFORD - WASHINGTON

Revisions
11-20-06 CONSTRUCTION DOCUMENTS ISSUED

Sheet
ELECTRICAL
FIRST FLOOR PLAN - POWER

Project Title


Landmark Healthcare
Facilities LLC
Fore River Medical
Pavilion
Portland, Maine

Date
NOVEMBER 20, 2006

Project Number
FO6-5103

Drawing Number

E2.01

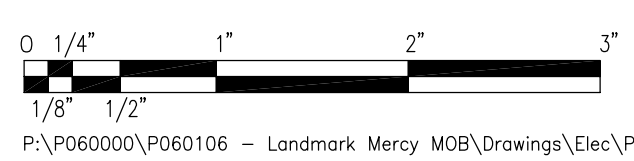

P:\P060000\P060106 - Landmark_Mercy_NDR\Drawings\Elec\P060106.E2.01.dwg 11/17/06 4:23 PM dsamba

1
FIRST FLOOR PLAN
SCALE: 1/8" = 1'-0"

