

**Francis**

**Cauffman**

**Foley**


**Hoffmann**

Francis Cauffman  
Foley Hoffmann  
Architects Ltd. 215-5


**AKF**  
W/E/P ENGINEER

*AKF*  
**AKF**  
150 WALTON STREET, SUITE 1400  
MILWAUKEE, WI 53258  
TEL: 414.353.6600 FAX: 414.353.6606  
A/E/P/NOI/NOI/P/NOI  
ADMINISTRATIVE SERVICES AVAILABLE  
INTERNATIONAL AFFILIATES AVAILABLE

Revision 11-20-06 CONSTRUCTION DOCUMENTS ISSUED

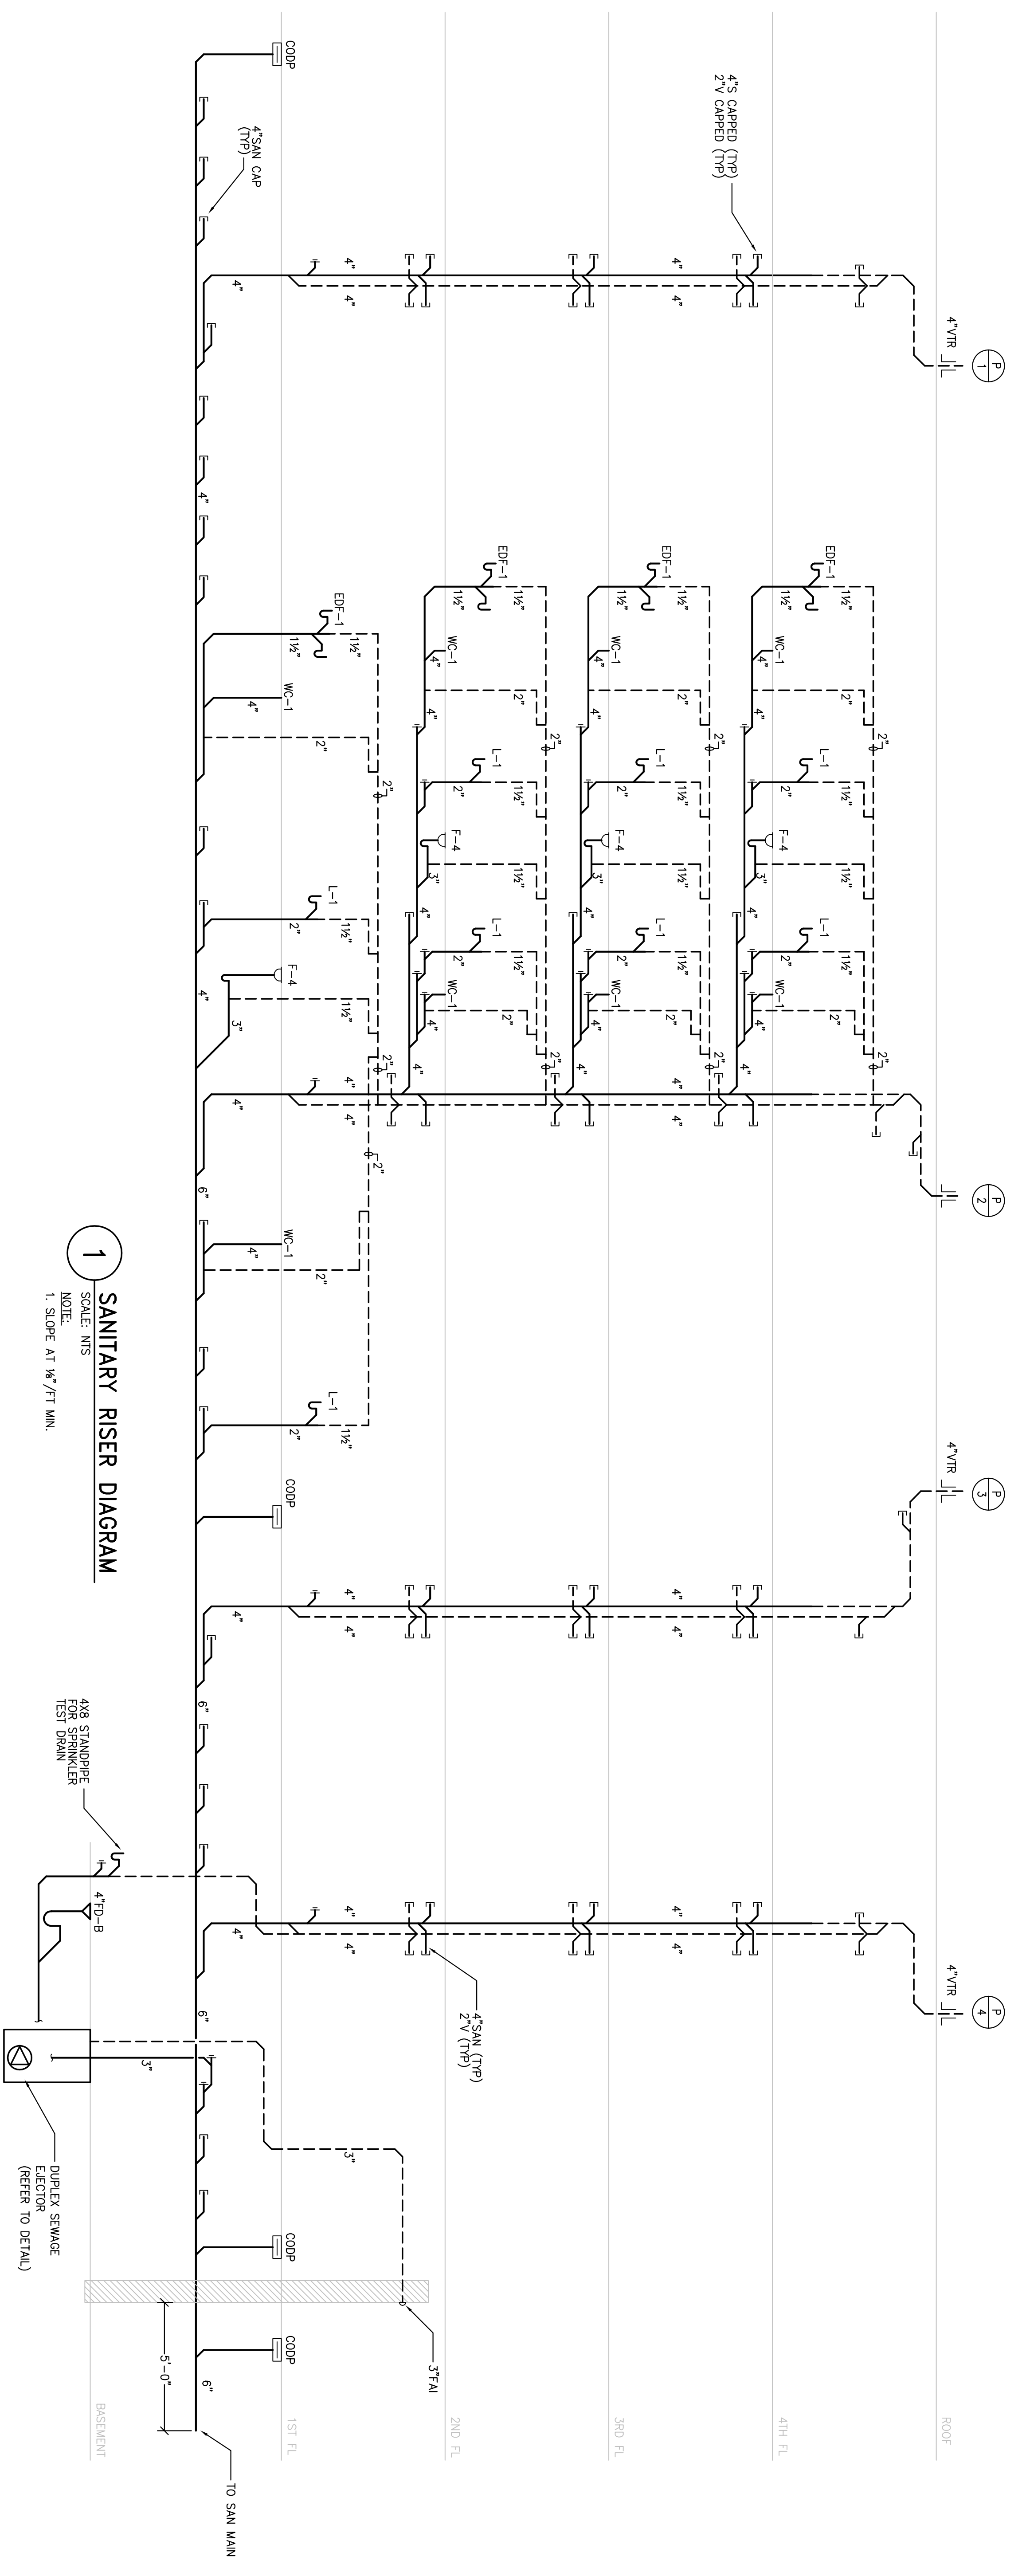

**1 SANITARY RISER DIAGRAM**  
SCALE: N1/S  
NOTE:  
1. SLOPE AT 1/4" / FT MIN.

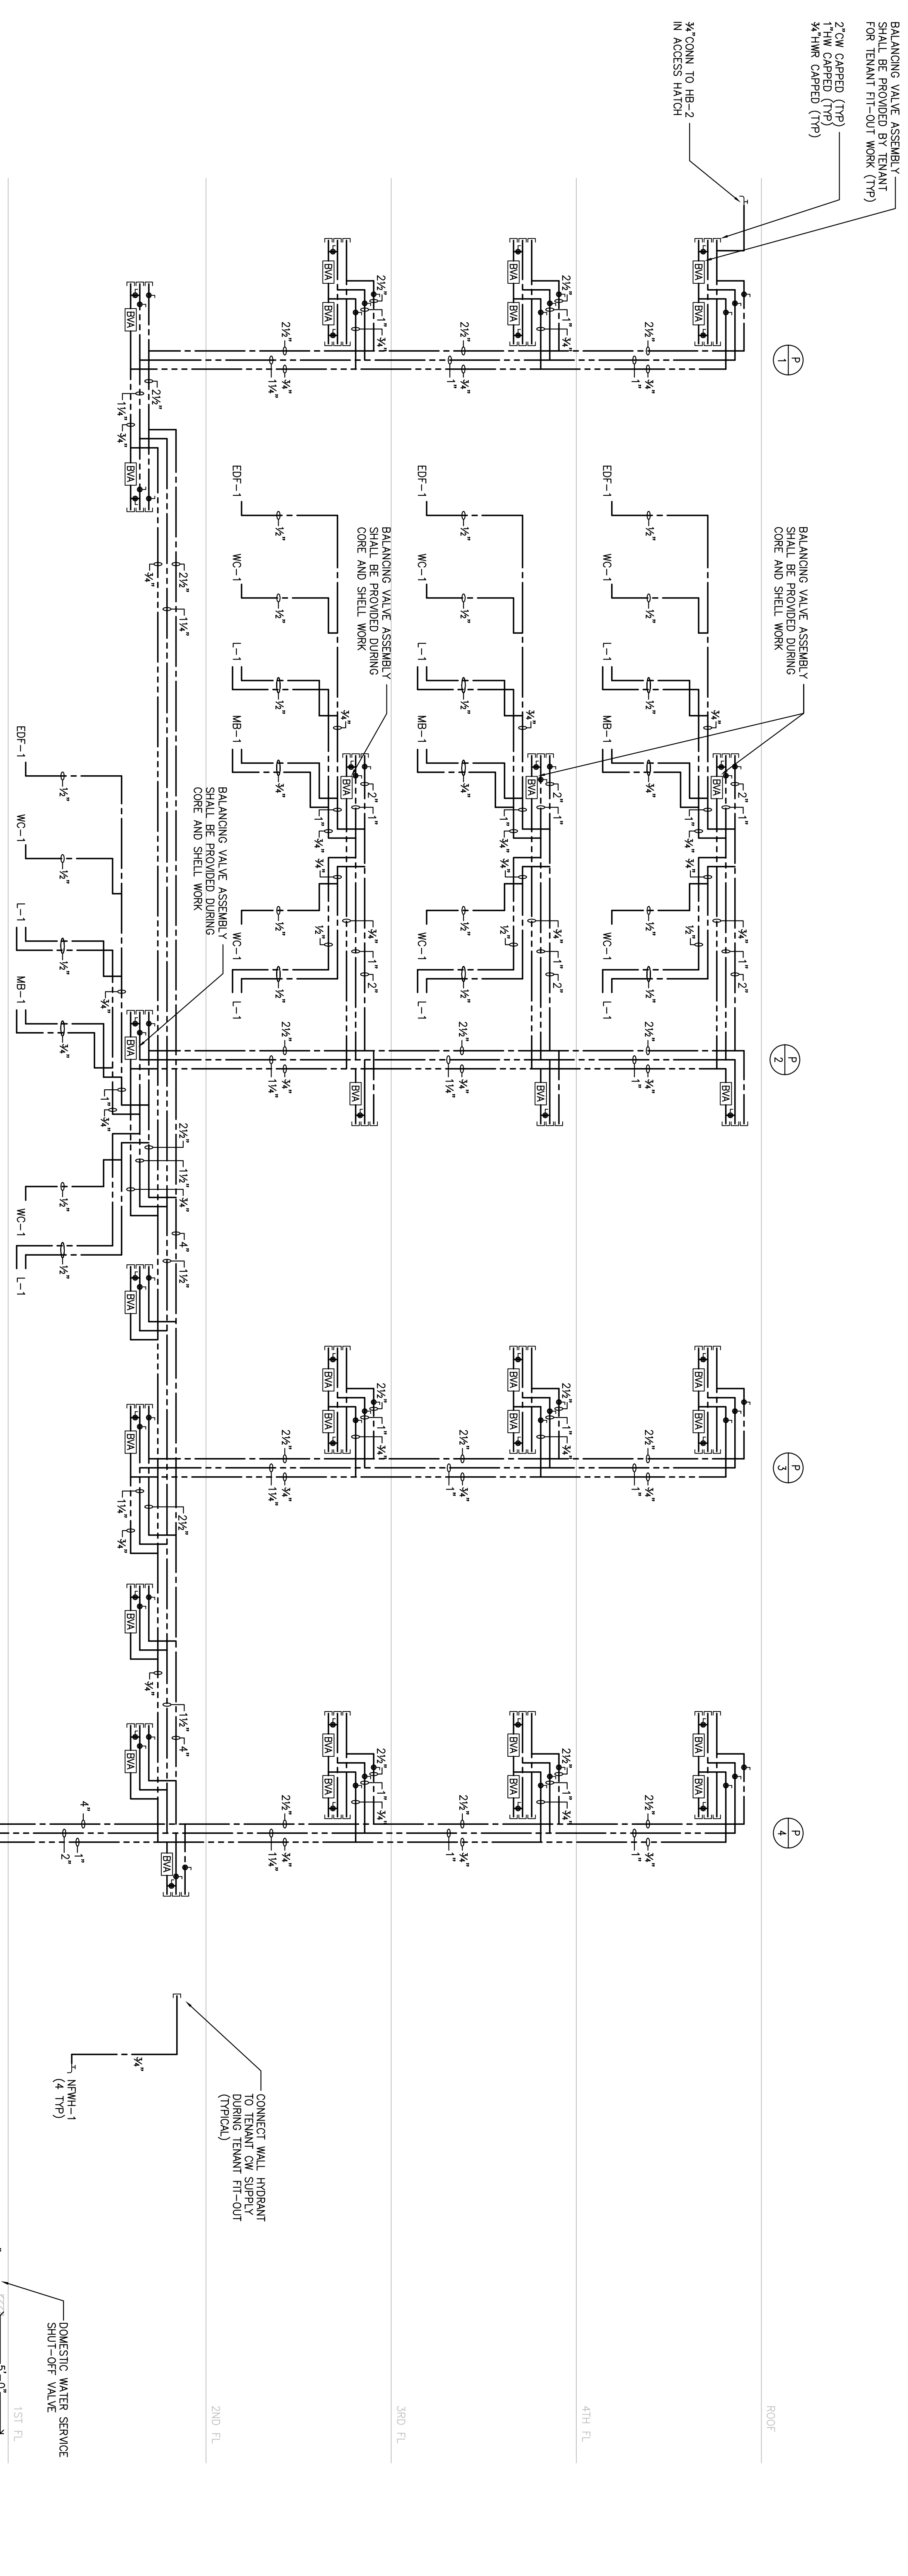

**2 DOMESTIC WATER RISER DIAGRAM**  
SCALE: N1/S



NOB:\Drawings\Plg\F060106\F3.00\_1.dwg 11/17/06 2:48 PM TBlancha

Sheet

PLUMBING  
RISER DIAGRAMS

Project Title

**Landmark Healthcare  
Facilities LLC  
Fore River Medical  
Pavilion  
Portland, Maine**

Date

Project Number  
FO6-5103

Drawing Number

**P3.00**