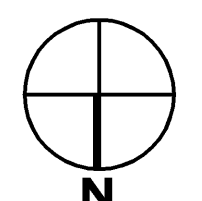
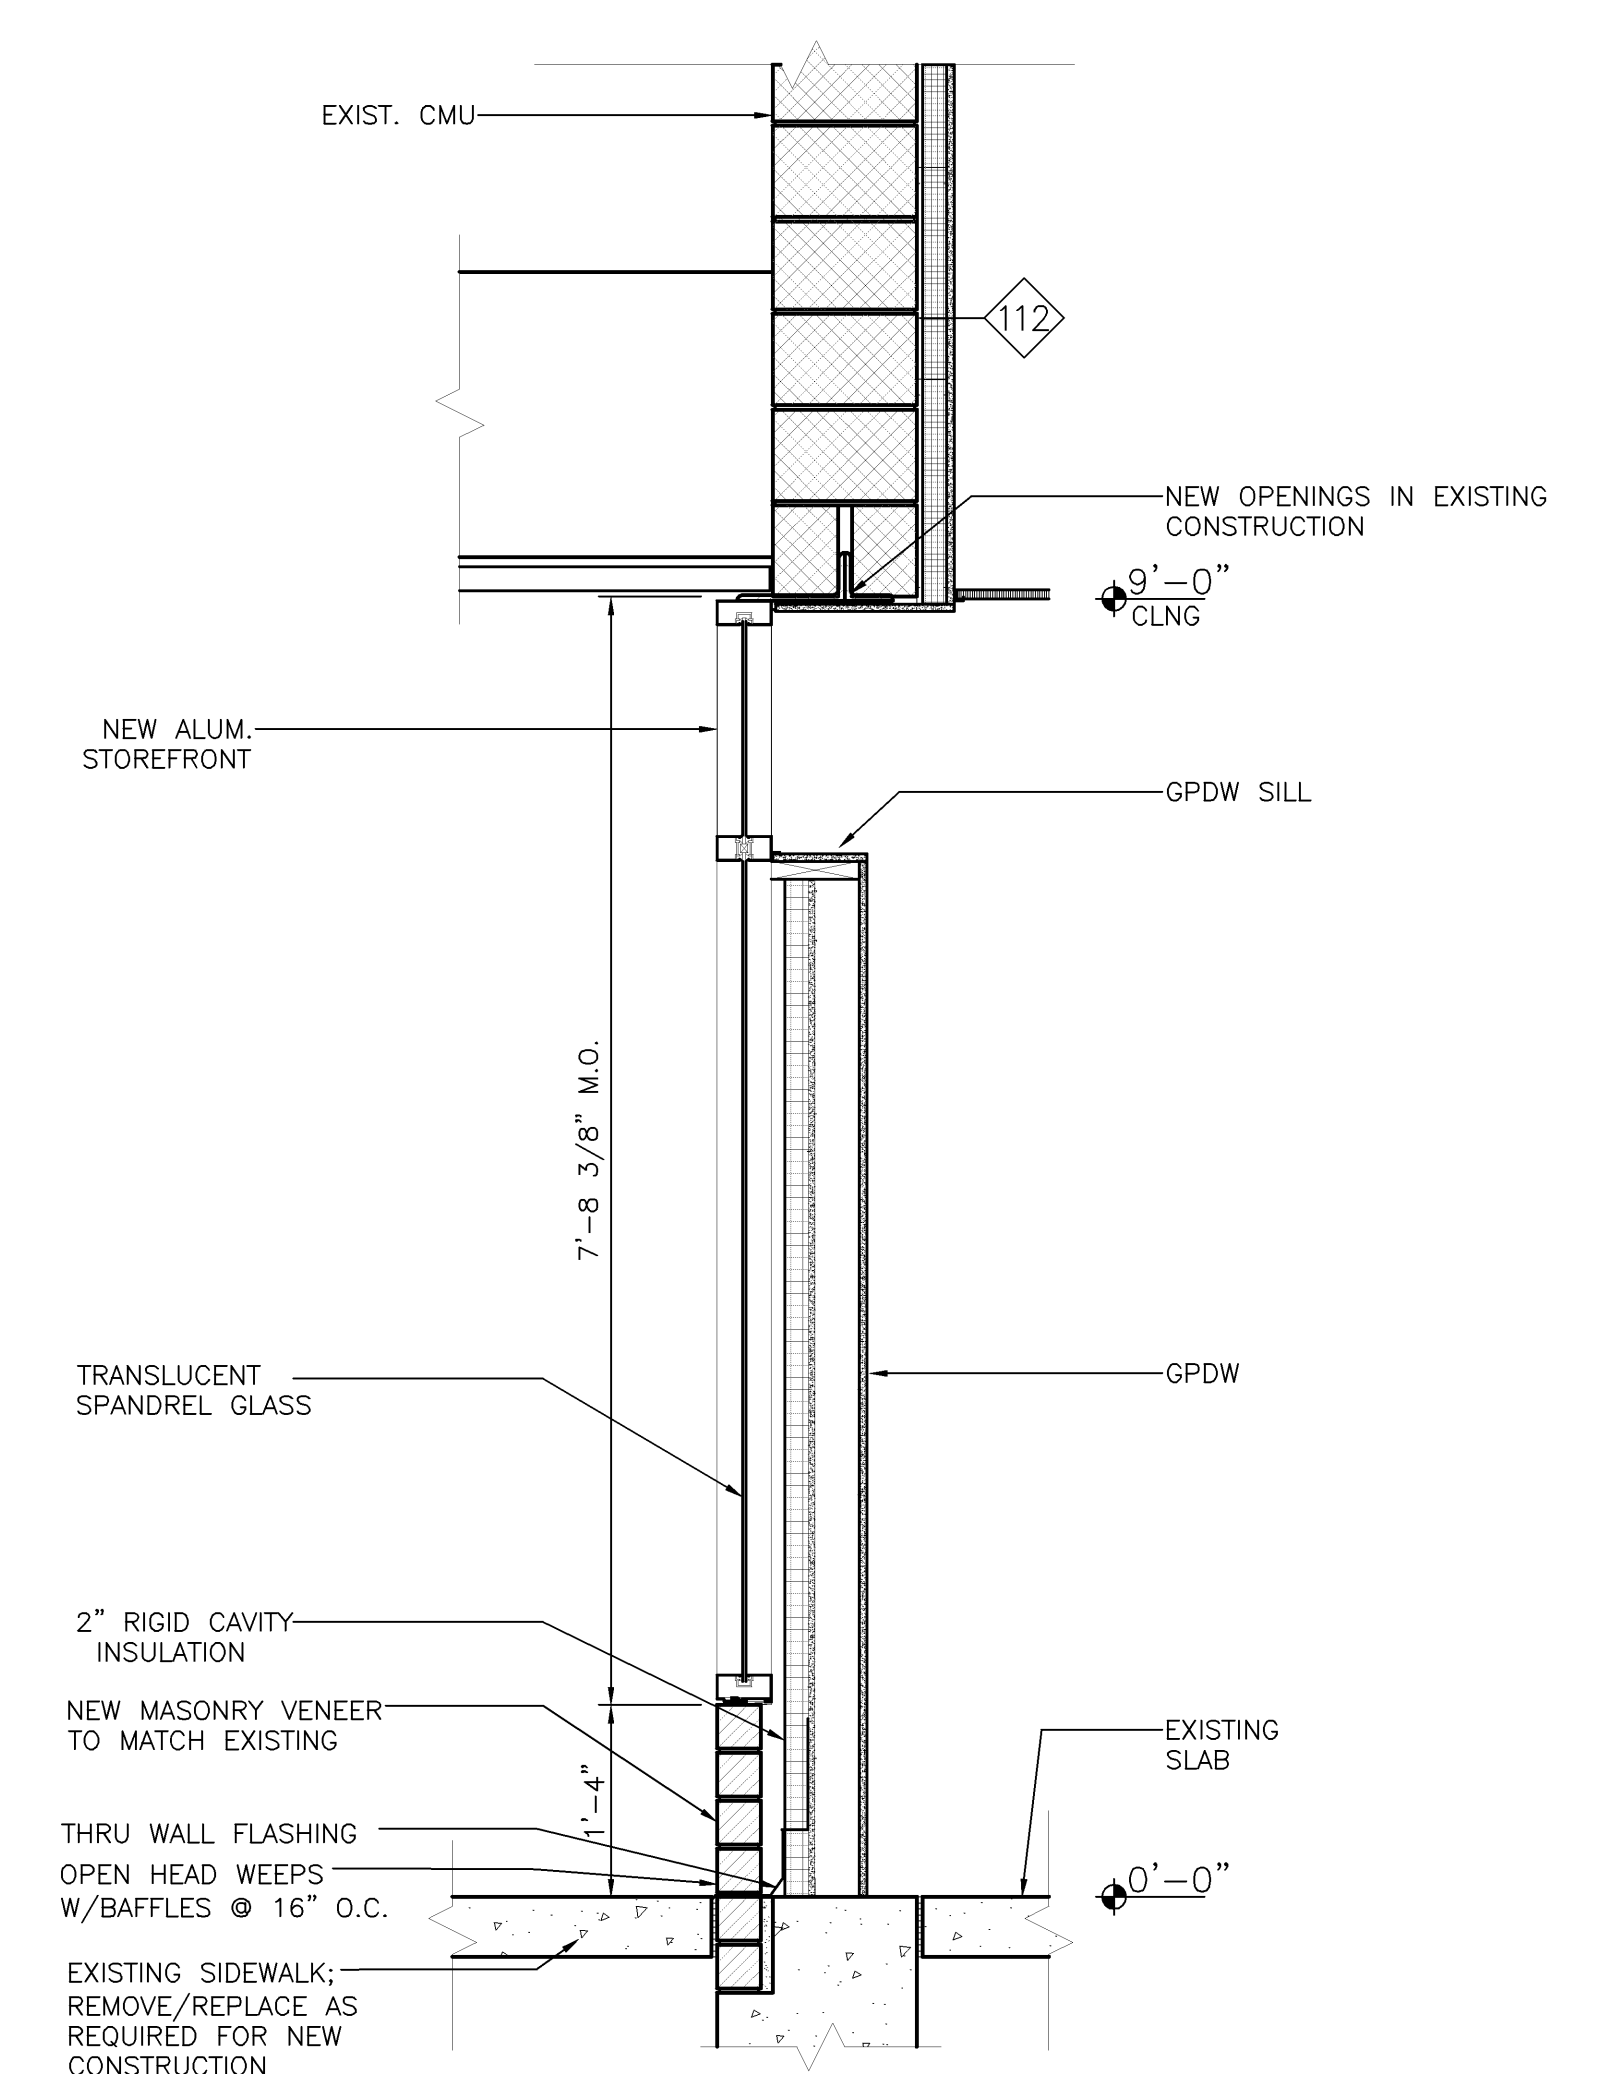


Project Title
**MERCY HEALTH CENTER
WESTGATE PLAZA**
PORTLAND, MAINE

HA Project No. **07182**
Key Plan

WALL SECTION
3/4" = 1'-0" 0 8" 1'-4" 2" REF: -

A1

07/01/08	ISSUED FOR PERMIT	
06/26/08	100% REVIEW SET	
Mark	Date	Description
Issue Dates		

Drawing Status

Drawing Title
WALL SECTIONS
PA / PE: PSC Drawn By: JGJ
Drawing Number
A30.1