



Right End (elev. view)

RTU-3 - RIGHT END ELEVATION		M5
NO SCALE	REF:	

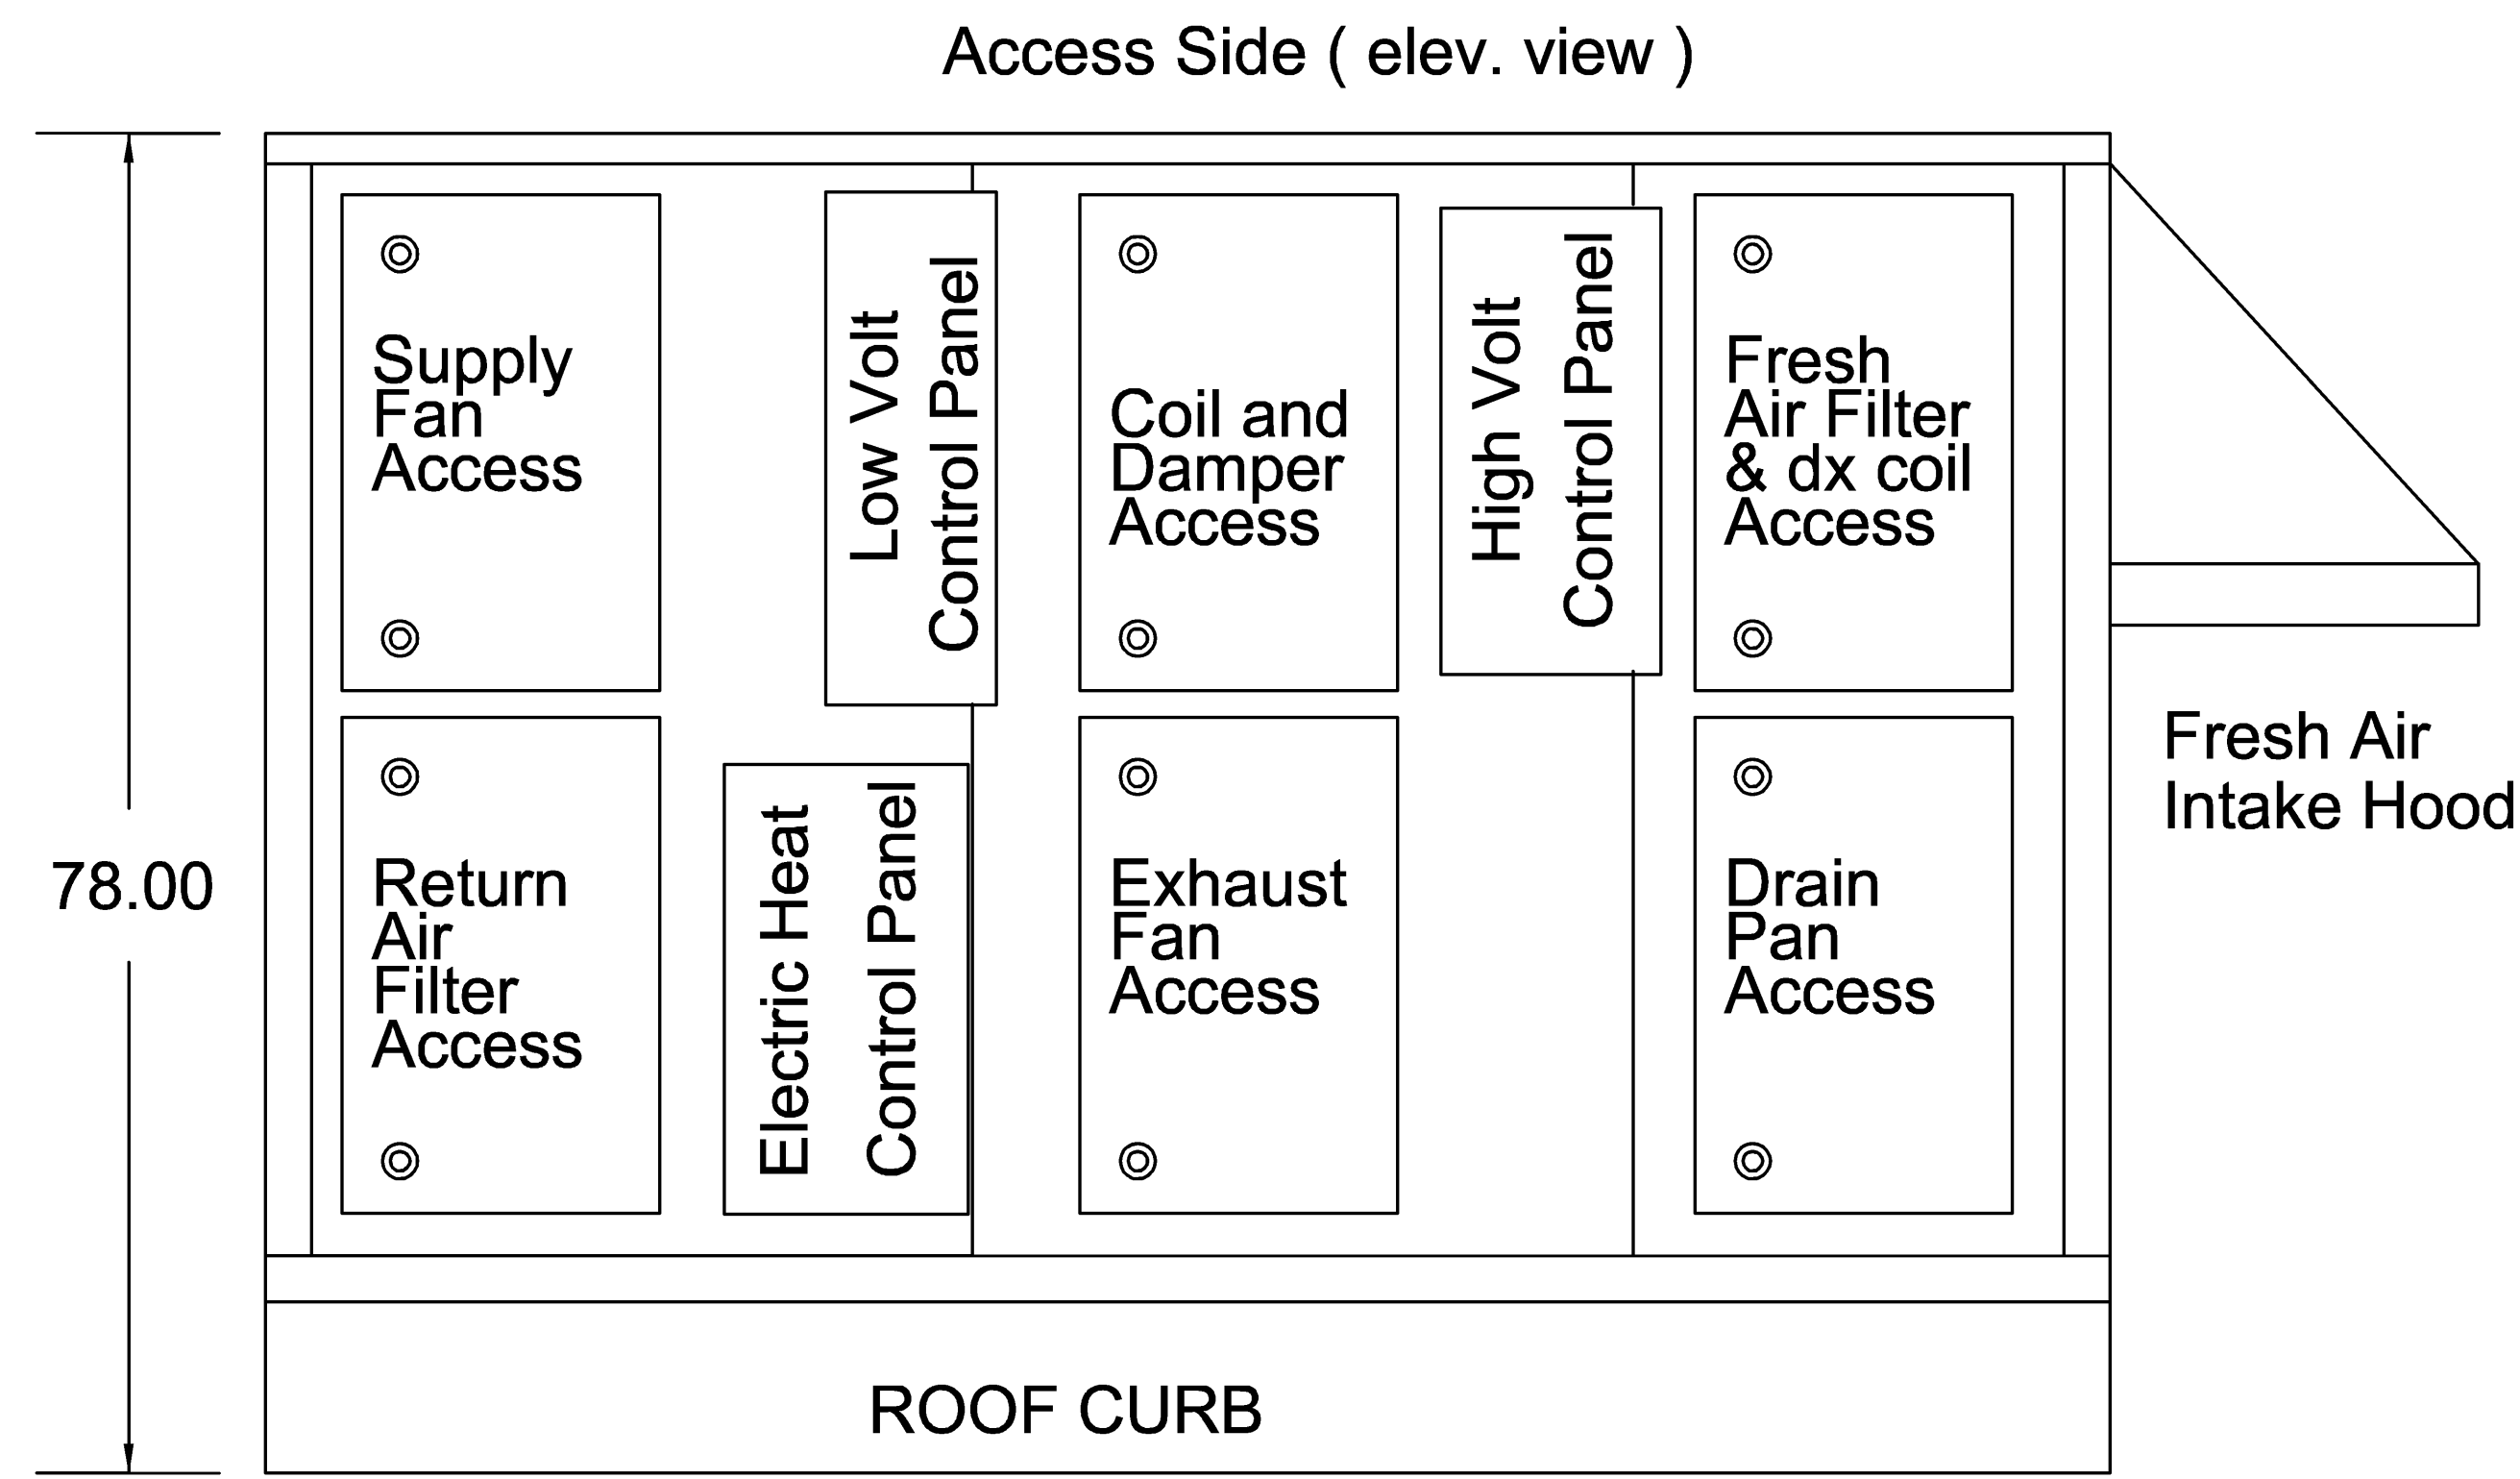


Access Side (elev. view)

RTU-3 - ACCESS SIDE ELEVATION		M4
NO SCALE	REF:	

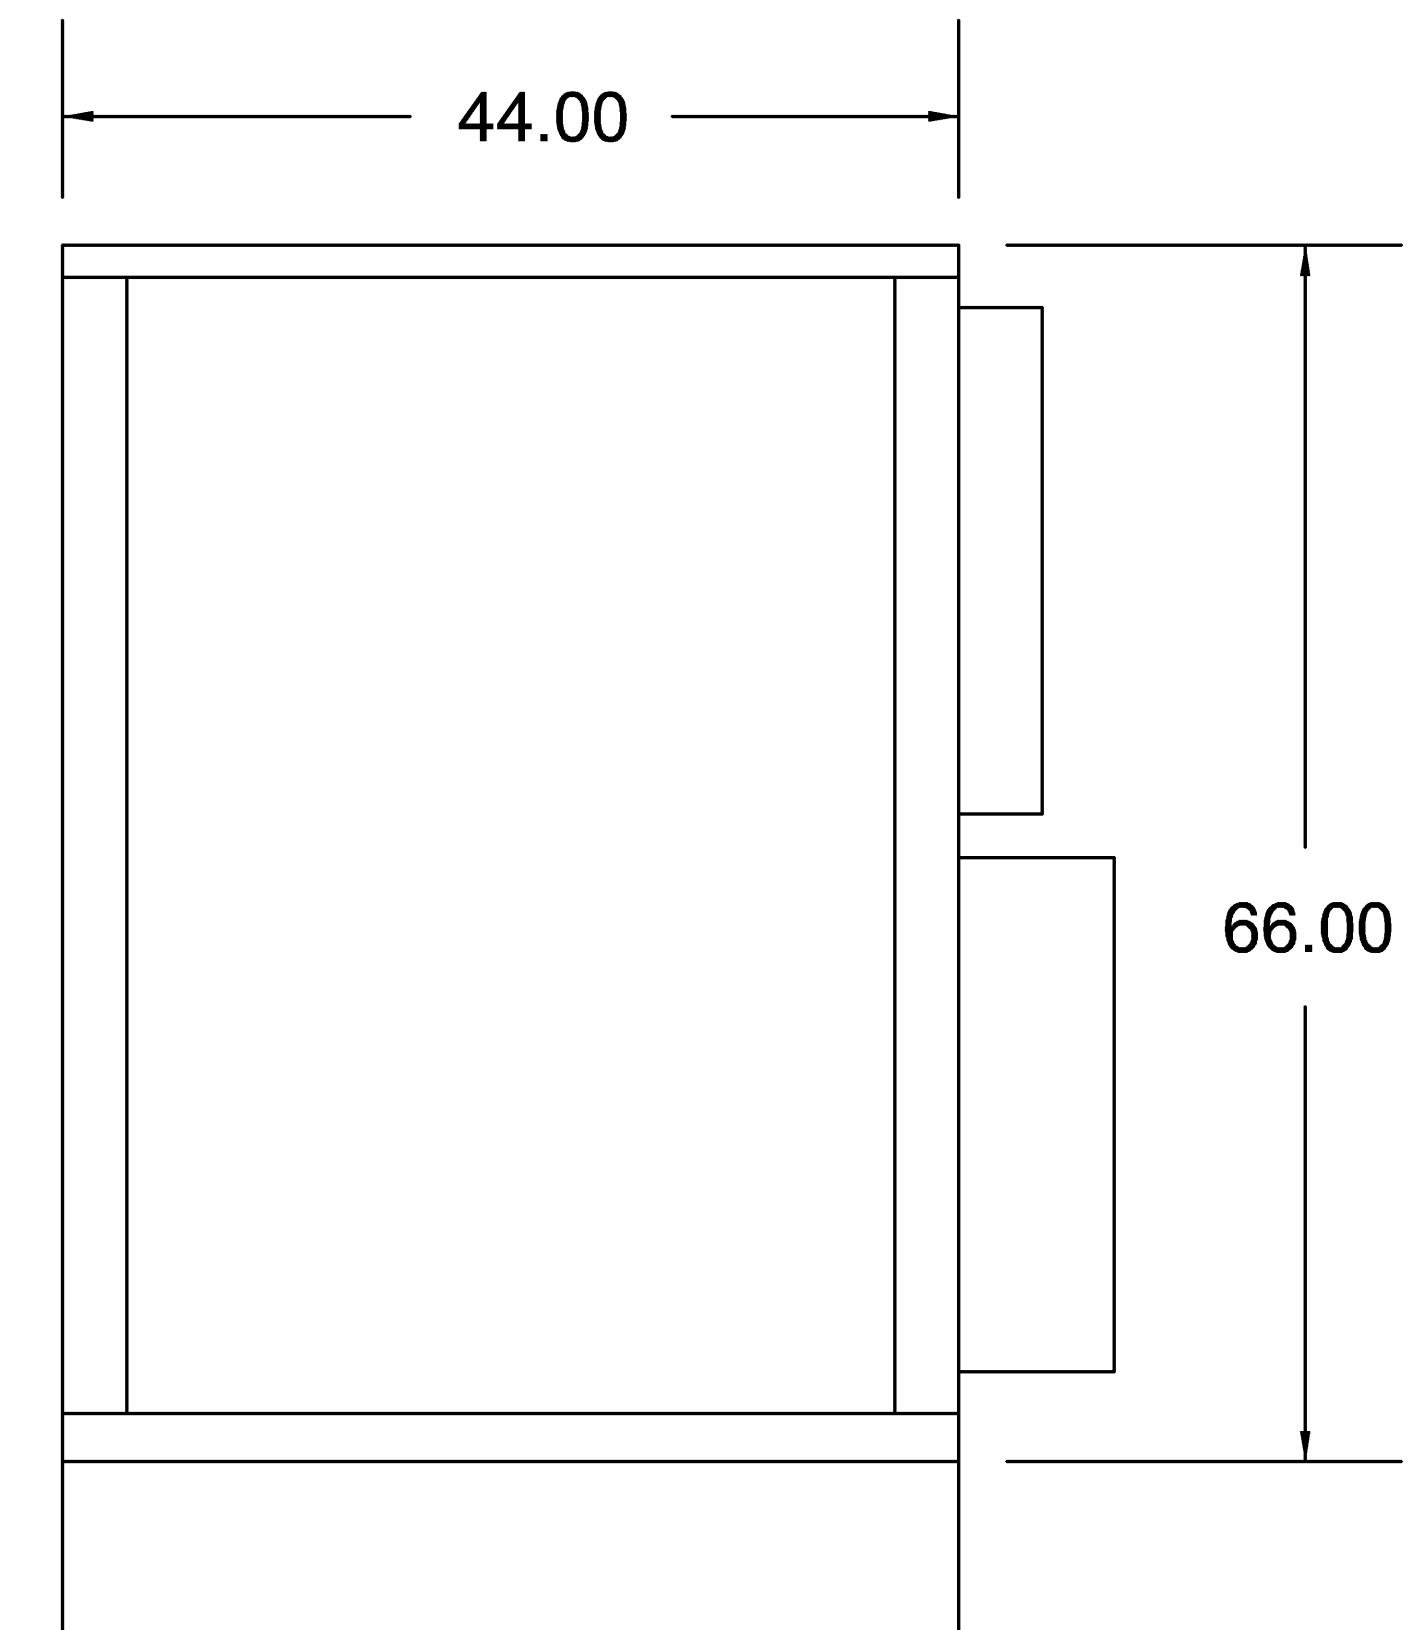


Left End (elev. view)

RTU-3 - LEFT END ELEVATION		M3
NO SCALE	REF:	

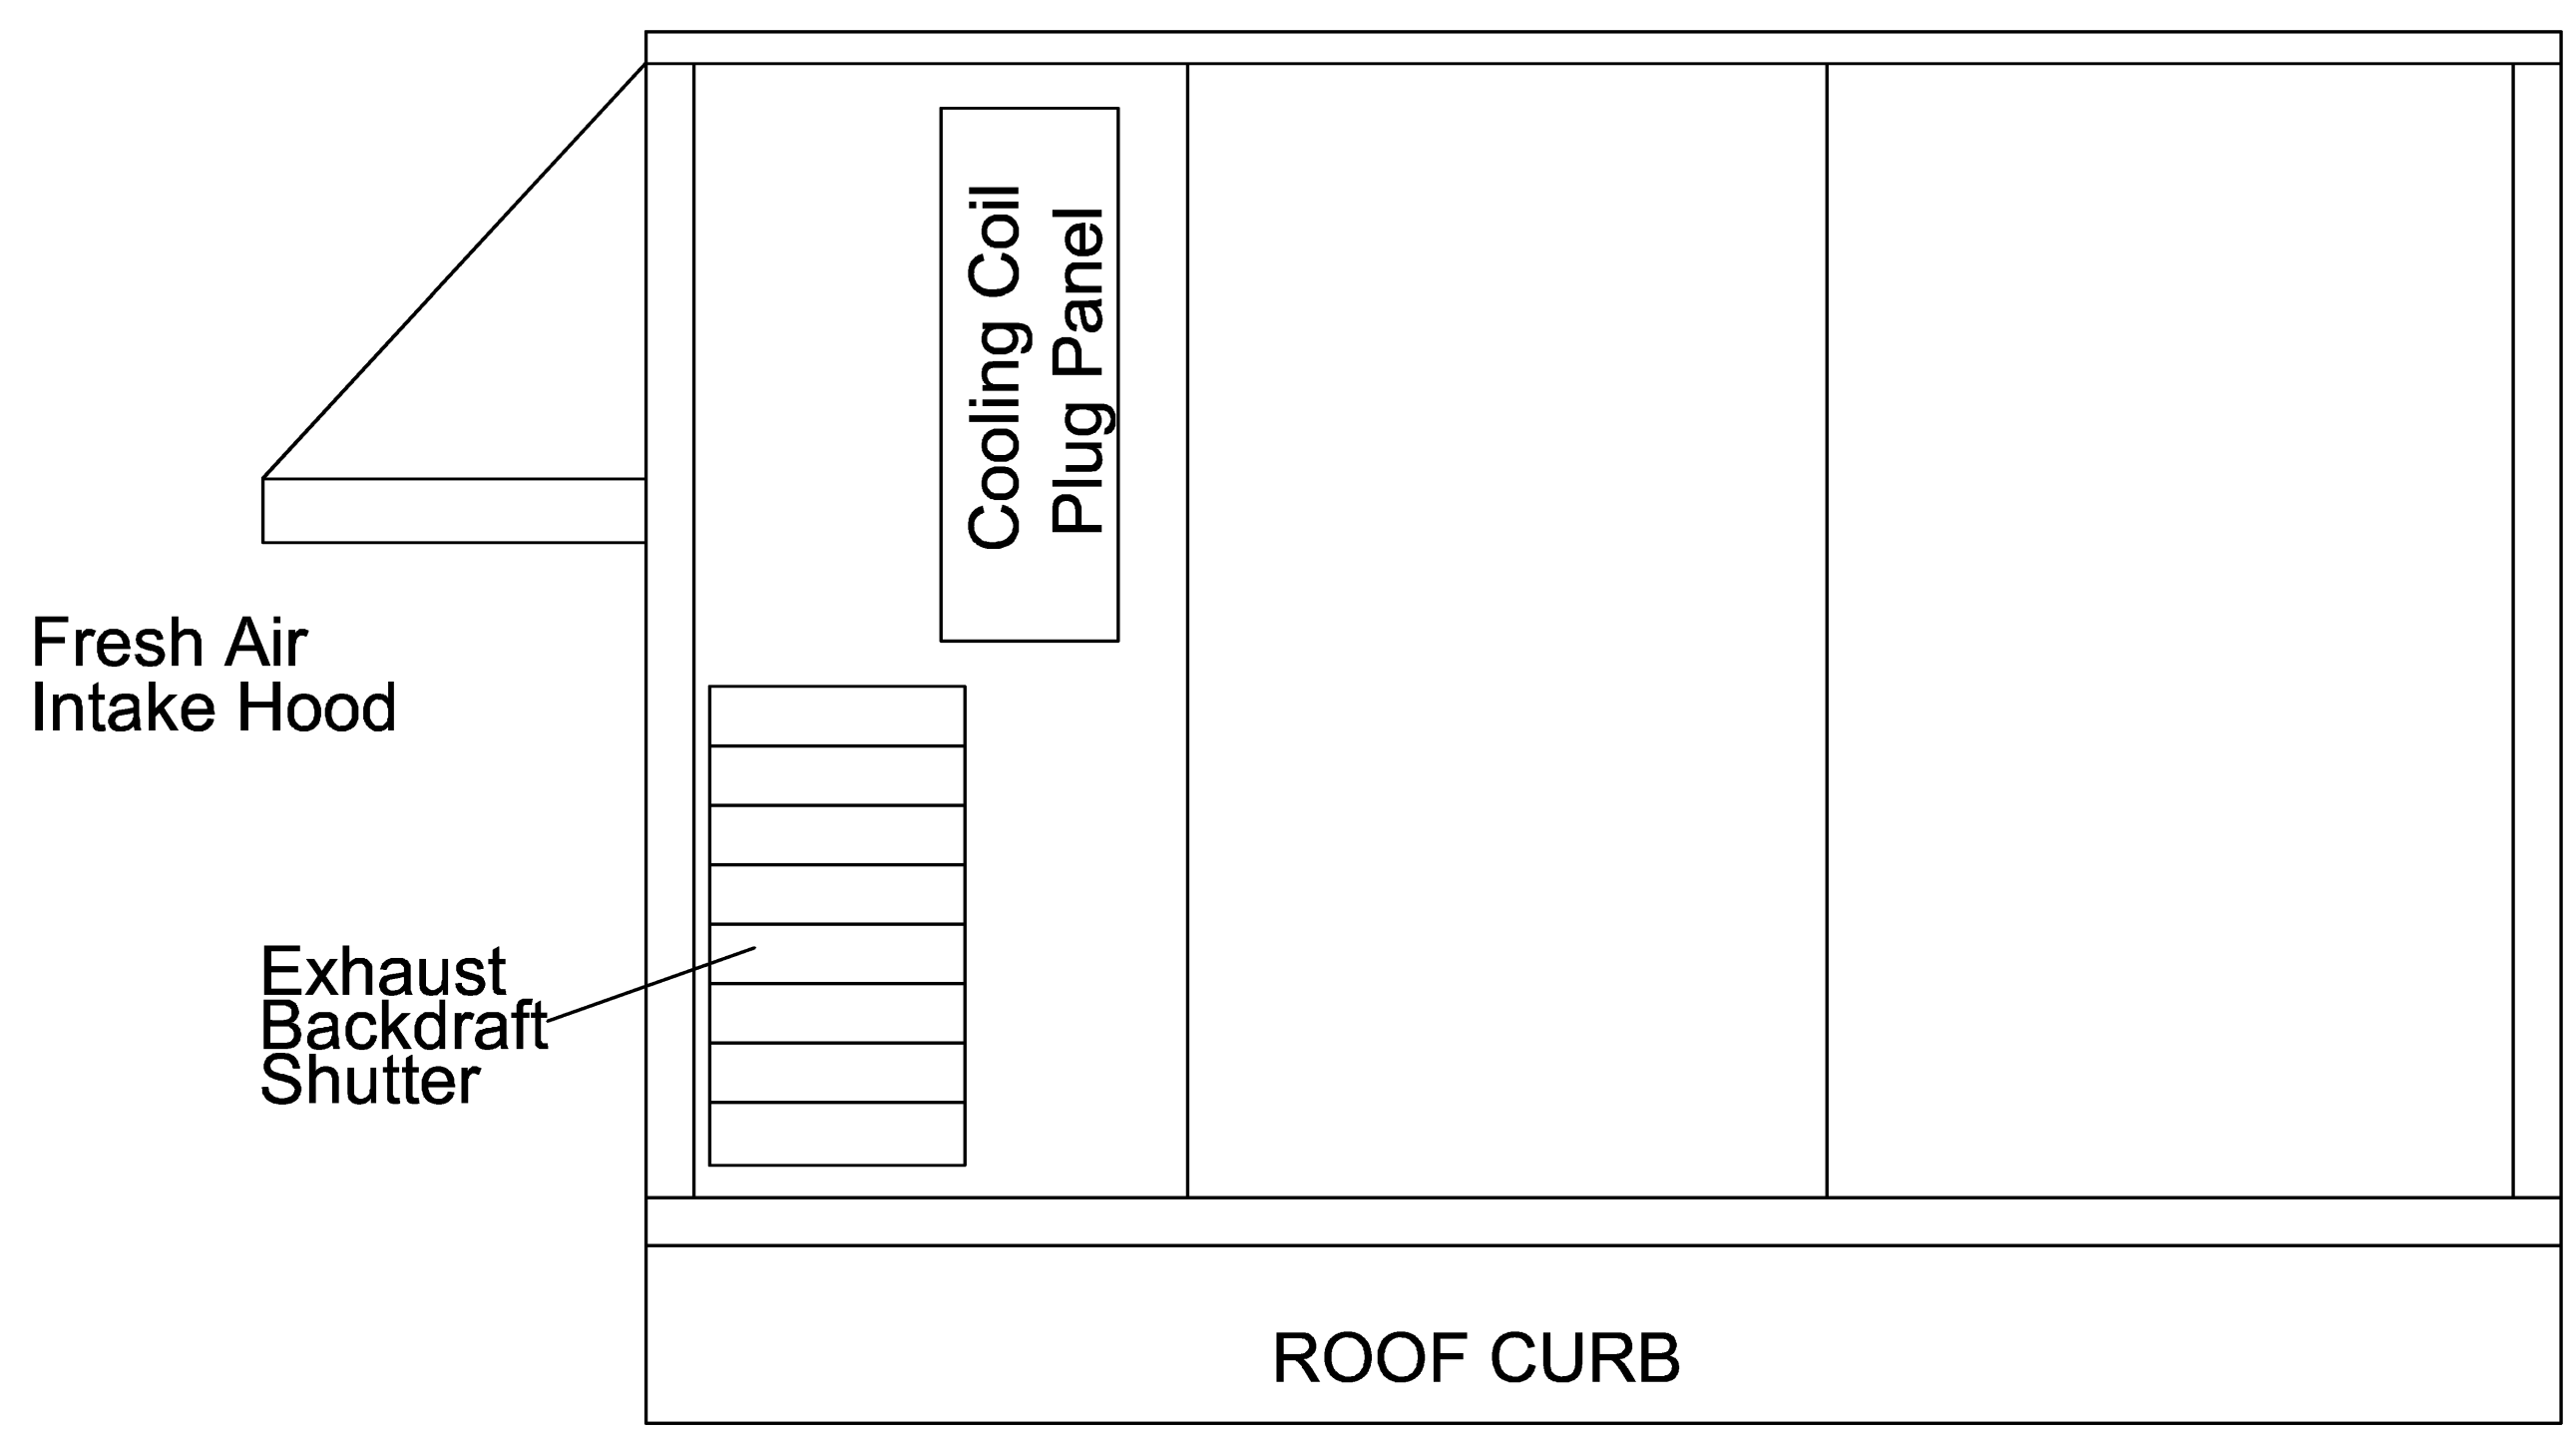

Back Side (elev. view)

RTU-3 - BACKSIDE ELEVATION		M2
NO SCALE	REF:	

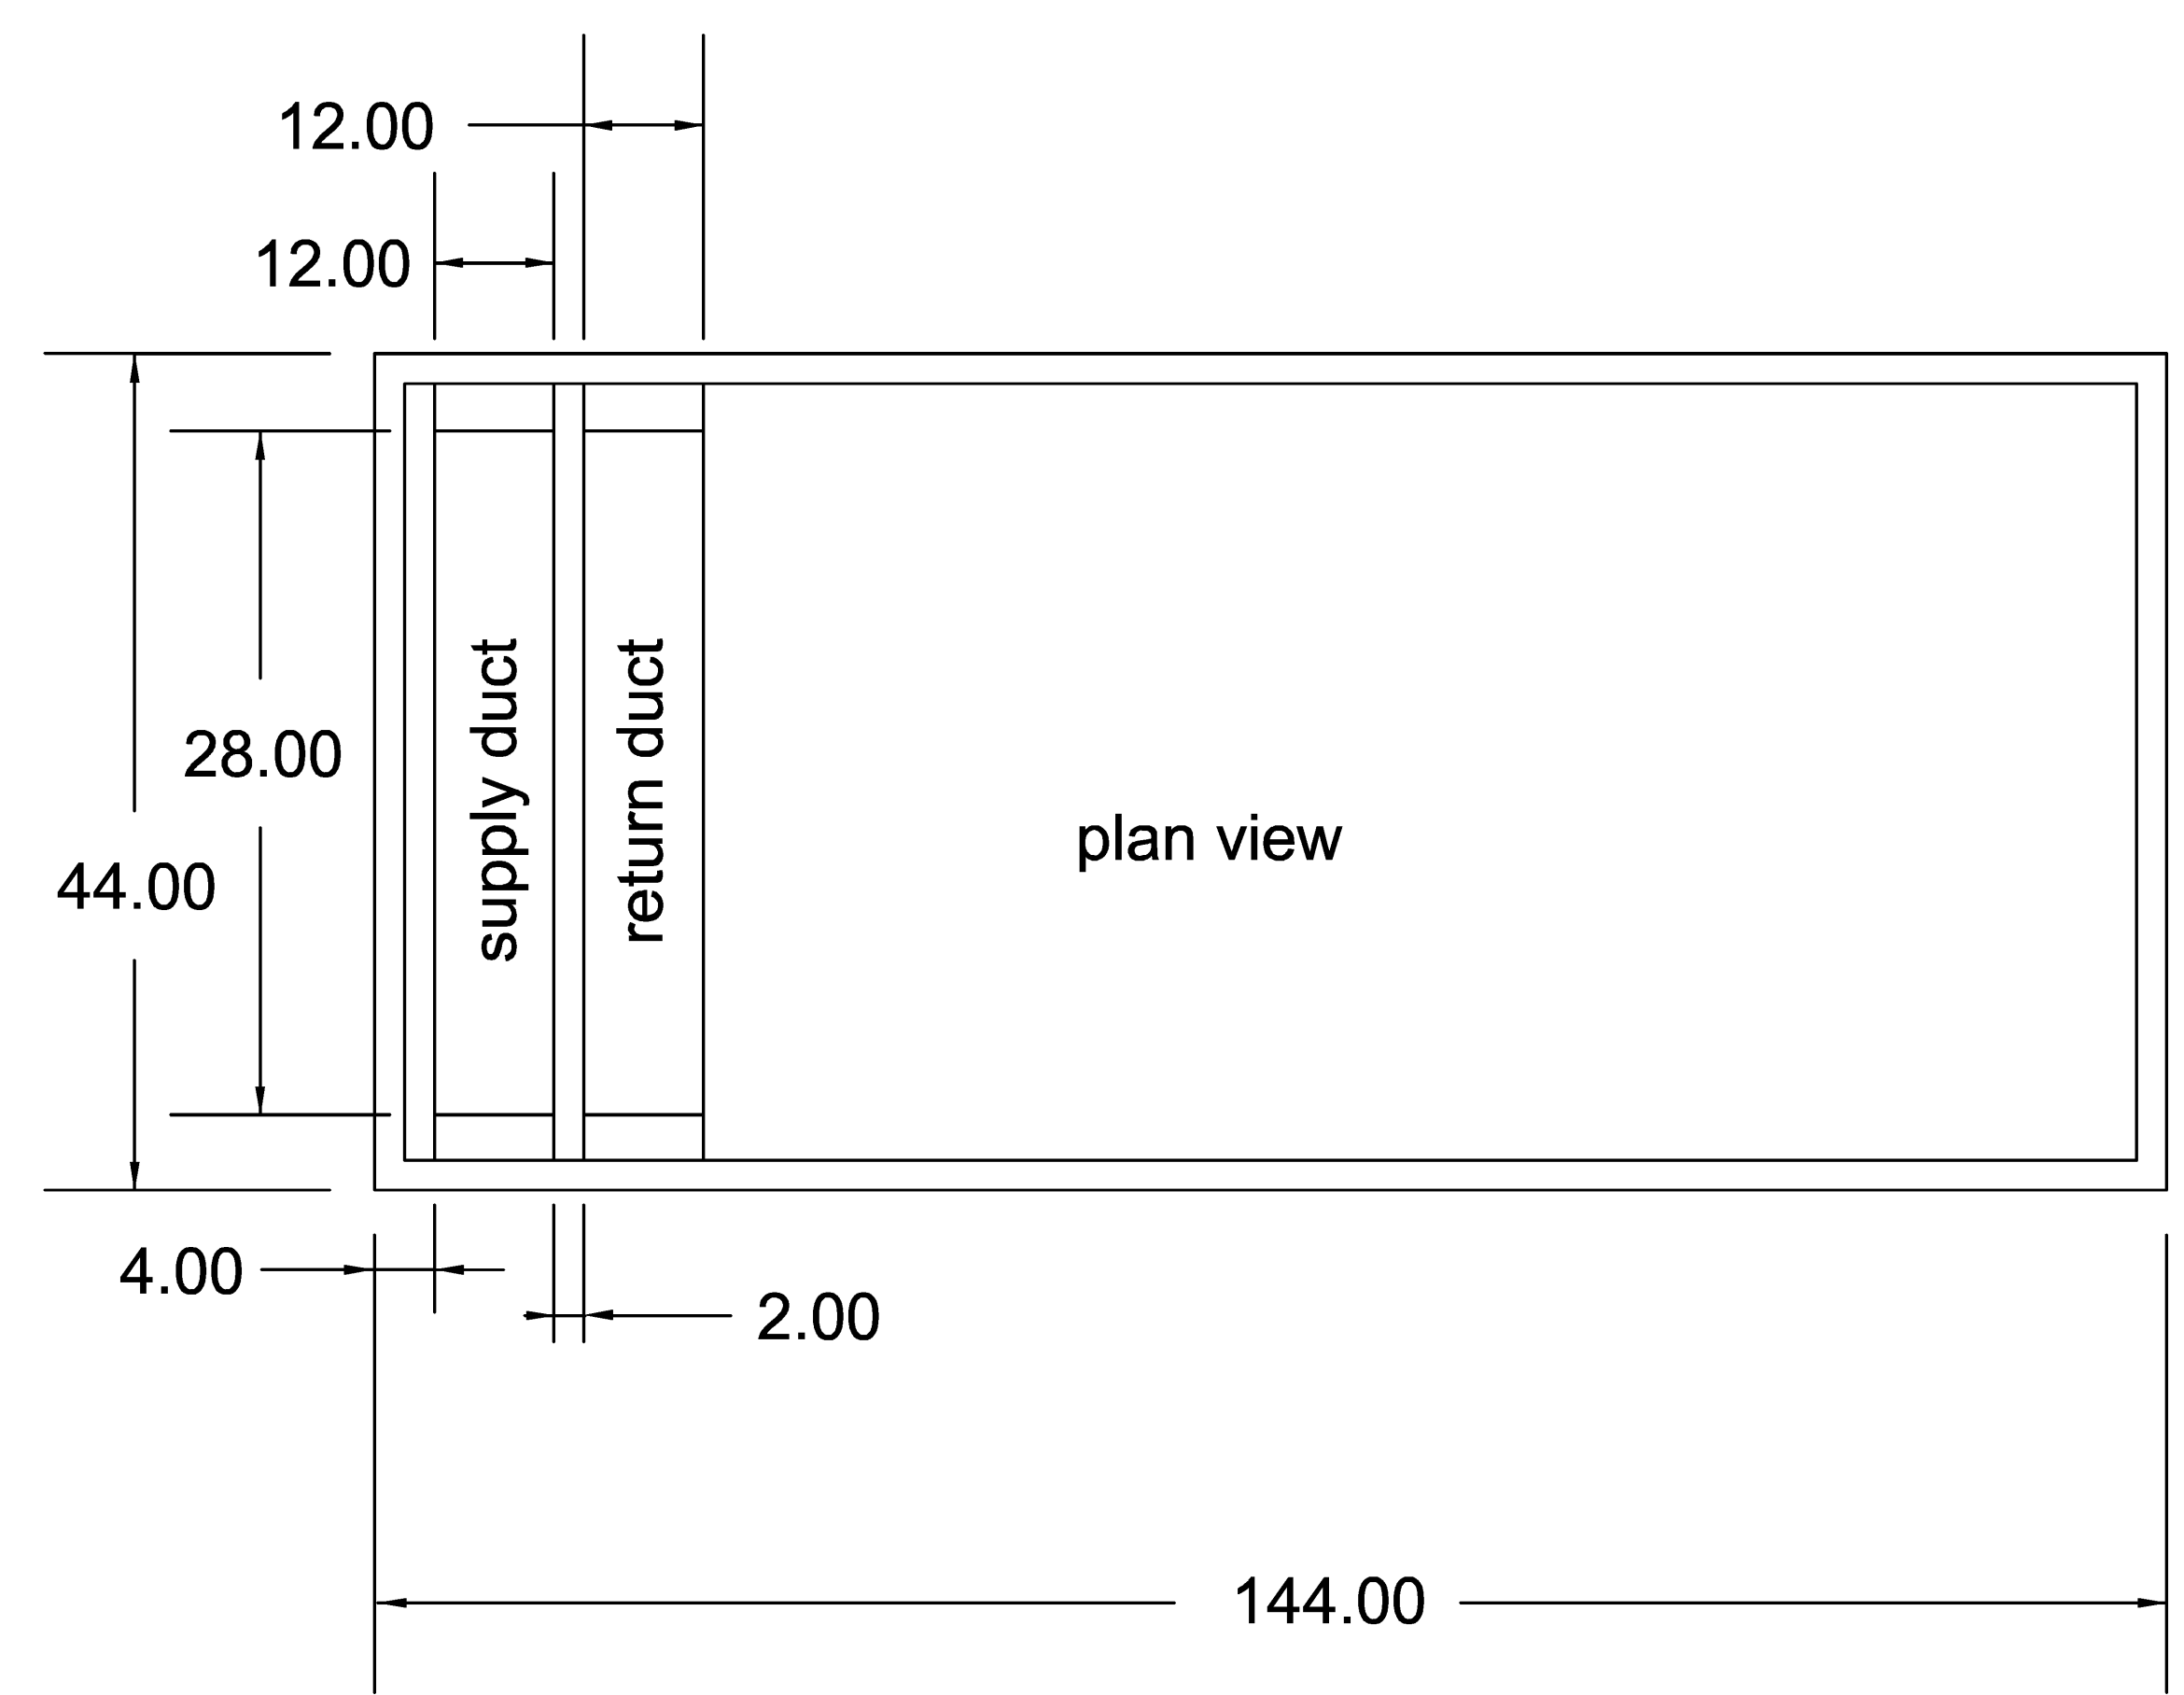

plan view

RTU-3 - PLAN VIEW		M1
NO SCALE	REF:	

HARRIMAN
Architects + Engineers
One Auburn Business Park
Auburn, Maine 04210
207.784.5100 tel
207.782.3017 fax
56 Pearl St., Suite 301
Portland, Maine 04101
207.775.0053 tel
207.775.0469 fax
www.harriman.com
© 2007

Project Title
MERCY HEALTH CENTER
WESTGATE PLAZA
PORTLAND, MAINE
HA Project No. **07182**
Key Plan

07/01/08	ISSUED FOR PERMIT	
06/26/08	100% REVIEW SET	
06/17/08	50% REVIEW SET	
Mark	Date	Description
Issue Dates		

Drawing Status

Drawing Title
MECHANICAL DETAILS
PA / PE: CG Drawn By: DBR
Drawing Number
M30.1