


LIGHTING FLOOR PLAN
Scale: 1/8" = 1'-0"

LIGHTING FIXTURE SCHEDULE									
PROVIDE ALL FIXTURES WITH COMPLETE HARDWARE, LAMPS, HANGERS, FITTINGS, ETC. FOR A COMPLETE AND PROPER MANUFACTURERS RECOMMENDED, UL INSTALLATION.									
TYPE	MANUFACTURER	CATALOG NO.	MTG.	VOLT	LAMPS			REMARKS/BALLAST INFORMATION	NOTES
					NO.	WATT	TYPE		
A2	COLUMBIA	4PS22-317GSA12.125-E277	R	120	3	17	17 WATT - TB - 835	PROVIDE WITH "EFFICIENCY MAINE" BALLAST AND LAMP COMBINATION	①
A3	COLUMBIA	4PS24-332GSA12.125-E277	R	120	3	32	32 WATT - TB - 835	PROVIDE WITH "EFFICIENCY MAINE" BALLAST AND LAMP COMBINATION	①⑤
B4		2"x4" INDIRECT FLOURESCENT 3-LAMP FOCAL POINT FMA2-24-3-TB-1C-120-D-G-WH	R	120	3	32	32 WATT - TB - 835	---	①⑥
C	6" SHOWER DOWNLIGHT PRESCOLITE	TBX-TL89	R	120	1	32	32 WATT - TT CFL	---	⑦
D6	6" LENSED DOWNLIGHT PRESCOLITE	CFT632EB-STF602-MFC-PL-TRG-B24	R	120	1	26	26 WATT - TT CFL	---	⑧
D6D	6" DIMMABLE LENSED DOWNLIGHT PRESCOLITE	CFT632EB-DM-STF602-MFC-PL-TRG-B24	R	120	1	32	32 WATT - TT CFL	---	⑥
D8	8" LENSED DOWNLIGHT PRESCOLITE	CFT832EB-STF802-MFC-PL-TRG-B24	R	120	1	32	32 WATT - TT CFL	---	⑧
E	EXIT LIGHT, SELF-DIAGNOSTICS, SINGLE OR DOUBLE FACE AS NEEDED DUAL-LITE	SE-S/D-R-W-E-I	-	120	-	-	LED	PROVIDE WITH SELF-DIAGNOSTICS SINGLE OR DOUBLE FACE AS NEEDED	④
F	4" DIRECT/INDIRECT LINEAR FLOURESCENT FINELITE	SB-PP-4-2TB-SC-EP-120-FA-RE	W	120	2	32	32 WATT - TB	PROVIDE WITH "EFFICIENCY MAINE" BALLAST AND LAMP COMBINATION	①
G	WALL SURFACE MOUNT WET LOCATION FIXTURE MORLITE (A83 SERIES)	A-R-3-D-W-242-HF-PC-P-1-G-O-P	-	120	2	42	42 WATT - CFL	COORDINATE INSTALLATION LAMP-42W/CFL/835	
H1	EMERGENCY LIGHTING BATTERY PACK/W LAMPHEADS DUAL-LITE	AS360-12V-1-V-6000	-	120	2	7.2W	-	PROVIDE WITH SELF-DIAGNOSTICS MOUNT ON SHELF	
H2	EMERGENCY LIGHTING REMOTE LIGHTS DUAL-LITE	SRH/DW1207	-	12	1/2	7.2W	-	PROVIDE WITH FLUSH JUNCTION BOX AND #12 CONDUCTORS	②
H3	EMERGENCY LIGHT DUAL-LITE	TG50-12V	-	12	2	7.2W	-	PROVIDE WITH SELF-DIAGNOSTICS AND #12 CONDUCTORS	③
J1	1"x4" 2-LAMP DEEP CELL PARABOLIC COLUMBIA	LSL14-232G-LD1x9-S-EP120	R	120	2	32	32 WATT - TB - 835	PROVIDE WITH "EFFICIENCY MAINE" BALLAST AND LAMP COMBINATION	①
J2	2"x2" 3-LAMP DEEP CELL PARABOLIC COLUMBIA	4S22-317G-LD3x3-S-E120	R	120	3	17	17 WATT - TB - 835	PROVIDE WITH "EFFICIENCY MAINE" BALLAST AND LAMP COMBINATION	①
J4	2"x4" 3-LAMP DEEP CELL PARABOLIC COLUMBIA	4S22-332G-LD3x6-S-E120	R	120	3	32	32 WATT - TB - 835	PROVIDE WITH "EFFICIENCY MAINE" BALLAST AND LAMP COMBINATION	①⑤
K	EXTERIOR WALL MOUNT FIXTURE DEVINE LIGHTING	BC018-100MH-120-DBZ-LP	S	120	1	100W	100W - METAL HALIDE	LAMP INCLUDED PHOTOCELL CONTROLLED	
S	SHOWER LIGHT INTEGRAL TO SHOWER STALL FURNISHED BY DIV. 15, INSTALLED BY DIV. 16		-	120	-	-	-	---	
U4	46" UNDERCOUNTER FIXTURE ALKCO	L2F4-120-SWH	S	120	1	28W	28 WATT - T5	---	⑦
W2	WRAPAROUND COLUMBIA	AD2-217-E120	S	120	2	17	17 WATT - TB	PROVIDE WITH "EFFICIENCY MAINE" BALLAST AND LAMP COMBINATION	①
W4	WRAPAROUND COLUMBIA	AD4-232-E120	S	120	2	32	32 WATT - TB	PROVIDE WITH "EFFICIENCY MAINE" BALLAST AND LAMP COMBINATION	①
V2	WALL MOUNT VANITY FIXTURE COLUMBIA	SA2-2-217-E120	S	120	2	17	17 WATT - TB	PROVIDE WITH "EFFICIENCY MAINE" BALLAST AND LAMP COMBINATION	①
V4	WALL MOUNT VANITY FIXTURE COLUMBIA	SAM4-232-E120	S	120	2	32	32 WATT - TB	PROVIDE WITH "EFFICIENCY MAINE" BALLAST AND LAMP COMBINATION	①

- LIGHTING FIXTURE SCHEDULE NOTES**
- ① COORDINATE WITH "EFFICIENCY MAINE".
 - ② PROVIDE DUAL-LITE #04SS/DB1207 PER HEAD SHOWN FOR EXTERIOR, POOL AREA AND SHOWER ROOMS REMOTE EMERGENCY LIGHTING HEADS.
 - ③ PROVIDE FOR LOCAL AREA EMERGENCY LIGHTING.
 - ④ SEE POWER AND SYSTEMS DRAWING E20.1 FOR LOCATIONS OF EXIT SIGNS.
 - ⑤ PROVIDE BALLASTS FOR DIMMING APPLICATIONS WHERE SHOWN.
 - ⑥ PROVIDE BALLAST FOR DINNING.

- NEW LIGHTING KEY NOTES**
- ① MOUNT CENTERED ABOVE DOOR.
 - ② PROVIDE SHELF TO MOUNT EMERGENCY LIGHTING BATTERY PACK. SEE LIGHTING SCHEDULE.
 - ③ MOUNT AT 9'-6" AFG. COORDINATE WITH OWNER FOR FINAL LOCATION.
 - ④ CONNECT TO 3 AND 4-WAY, a/b SWITCHES AT ENTRANCES TO FACILITIES.
 - ⑤ CONNECT TO 3-WAY, SWITCHES AT OPPOSITE ENTRANCES TO RECEPTION AREA.
 - ⑥ PROVIDE DOOR JAMB SWITCH FOR POOL STORAGE ROOM.
 - ⑦ MOUNT CENTERED 24" ABOVE DOOR.
 - ⑧ PROVIDE PUSHBUTTON SWITCH WITH WET LOCATION COVER.

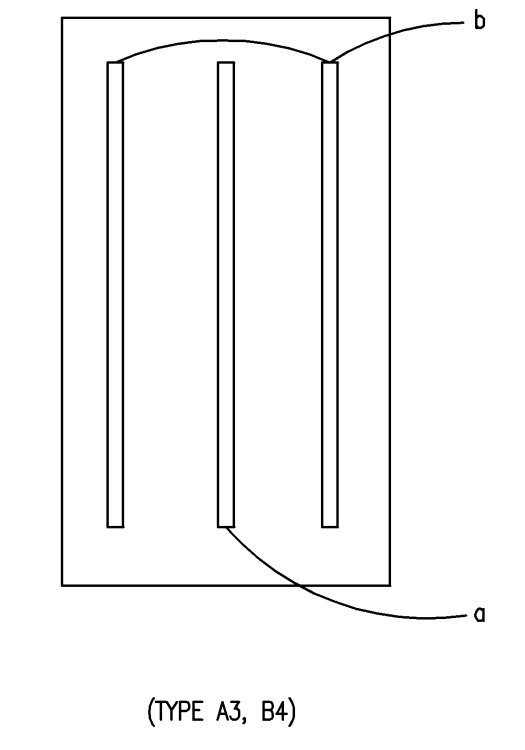

SWITCHING DETAIL - 3-LAMP FIXTURES
Scale: NTS

HARRIMAN
Architects + Engineers
One Auburn Business Park
Auburn, Maine 04210
207.784.5100 tel
207.782.3017 fax
56 Pearl St., Suite 301
Portland, Maine 04101
207.775.0055 tel
207.775.0460 fax
www.harriman.com
© 2007

Project Title
MERCY HEALTH CENTER WESTGATE PLAZA
PORTLAND, MAINE
HA Project No. **07182**
Key Plan

07/08/08	ADDENDUM #1	
07/01/08	ISSUED FOR PERMIT	
06/26/08	100% REVIEW SET	
06/17/08	50% REVIEW SET	
Mark	Date	Description
Issue Dates		

Drawing Title
ELECTRICAL LIGHTING FIRST FLOOR PLAN
PA / PE: WRH Drawn By: RJB
Drawing Number
E10.1