



FIRST FLOOR REFLECTED CEILING PLAN
SCALE: 1/4" = 1'-0"

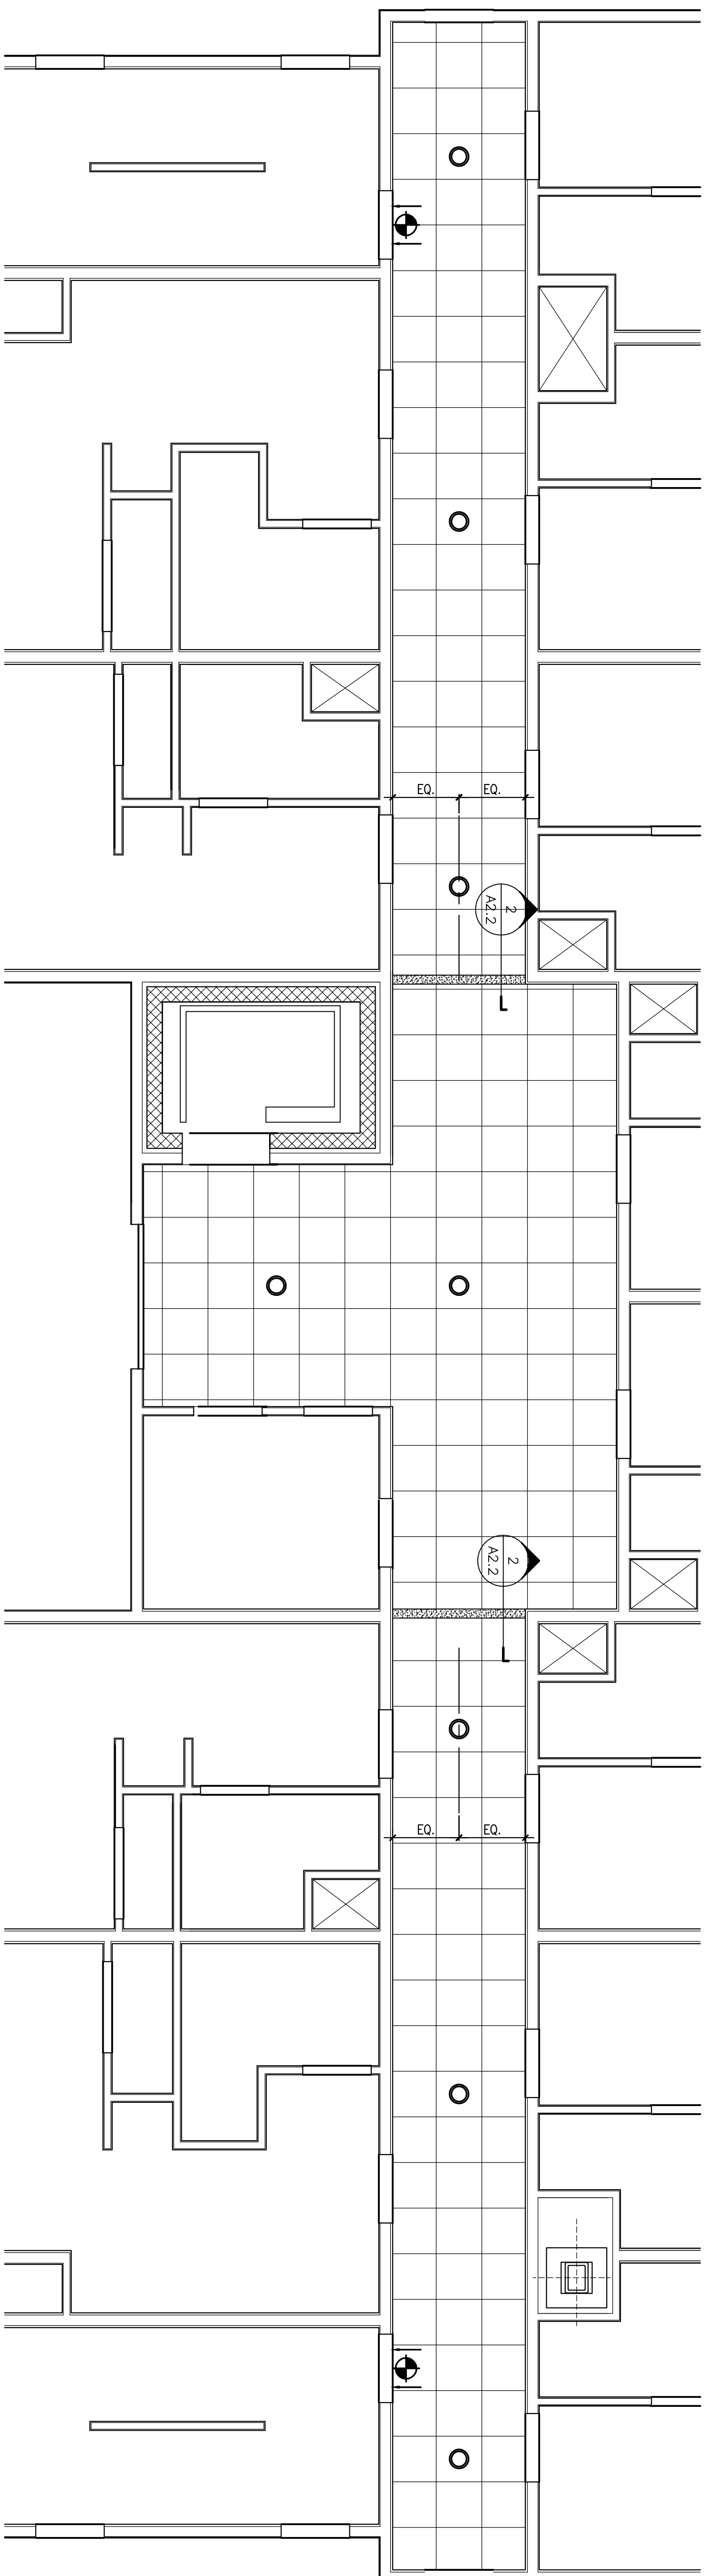

SECOND FLOOR REFLECTED CEILING PLAN
SCALE: 1/4" = 1'-0"

NOTE:
SEE ELECTRICAL DRAWINGS FOR
LIGHTING FIXTURE LOCATION,
COORDINATE IN FIELD.

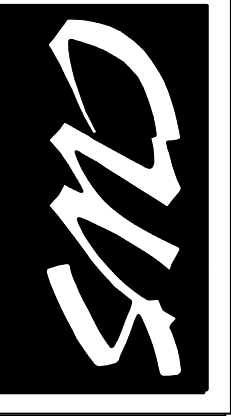

CWS Architects

- Architecture
- Space Planning
- Value Design

434 Cumberland Avenue
Portland, ME 04101
Phone: (207)774-4441
Fax: (207)774-4018
www.CWSArch.com

Client: **YC PORTLAND LP.**
C/O AVESTA
307 CUMBERLAND AVE.
PORTLAND, MAINE 04101
(207) 553-7777

Client: **YORK-CUMBERLAND**
HOUSING DEVELOPMENT

LOGAN PLACE
PORTLAND, MAINE

Project No: 01.09.SPO
Drawing Title: **1ST AND 2ND FLOOR REFLECTED CEILING PLANS**

Scale: 1/4" = 1'-0"
Date: JANUARY 14, 2004

- Revisions:
- ▲
 - ▲
 - ▲
 - ▲
 - ▲

Drawing Number: **A2.1**