


- ▲
- ▲
- ▲
- ▲
- ▲
- ▲

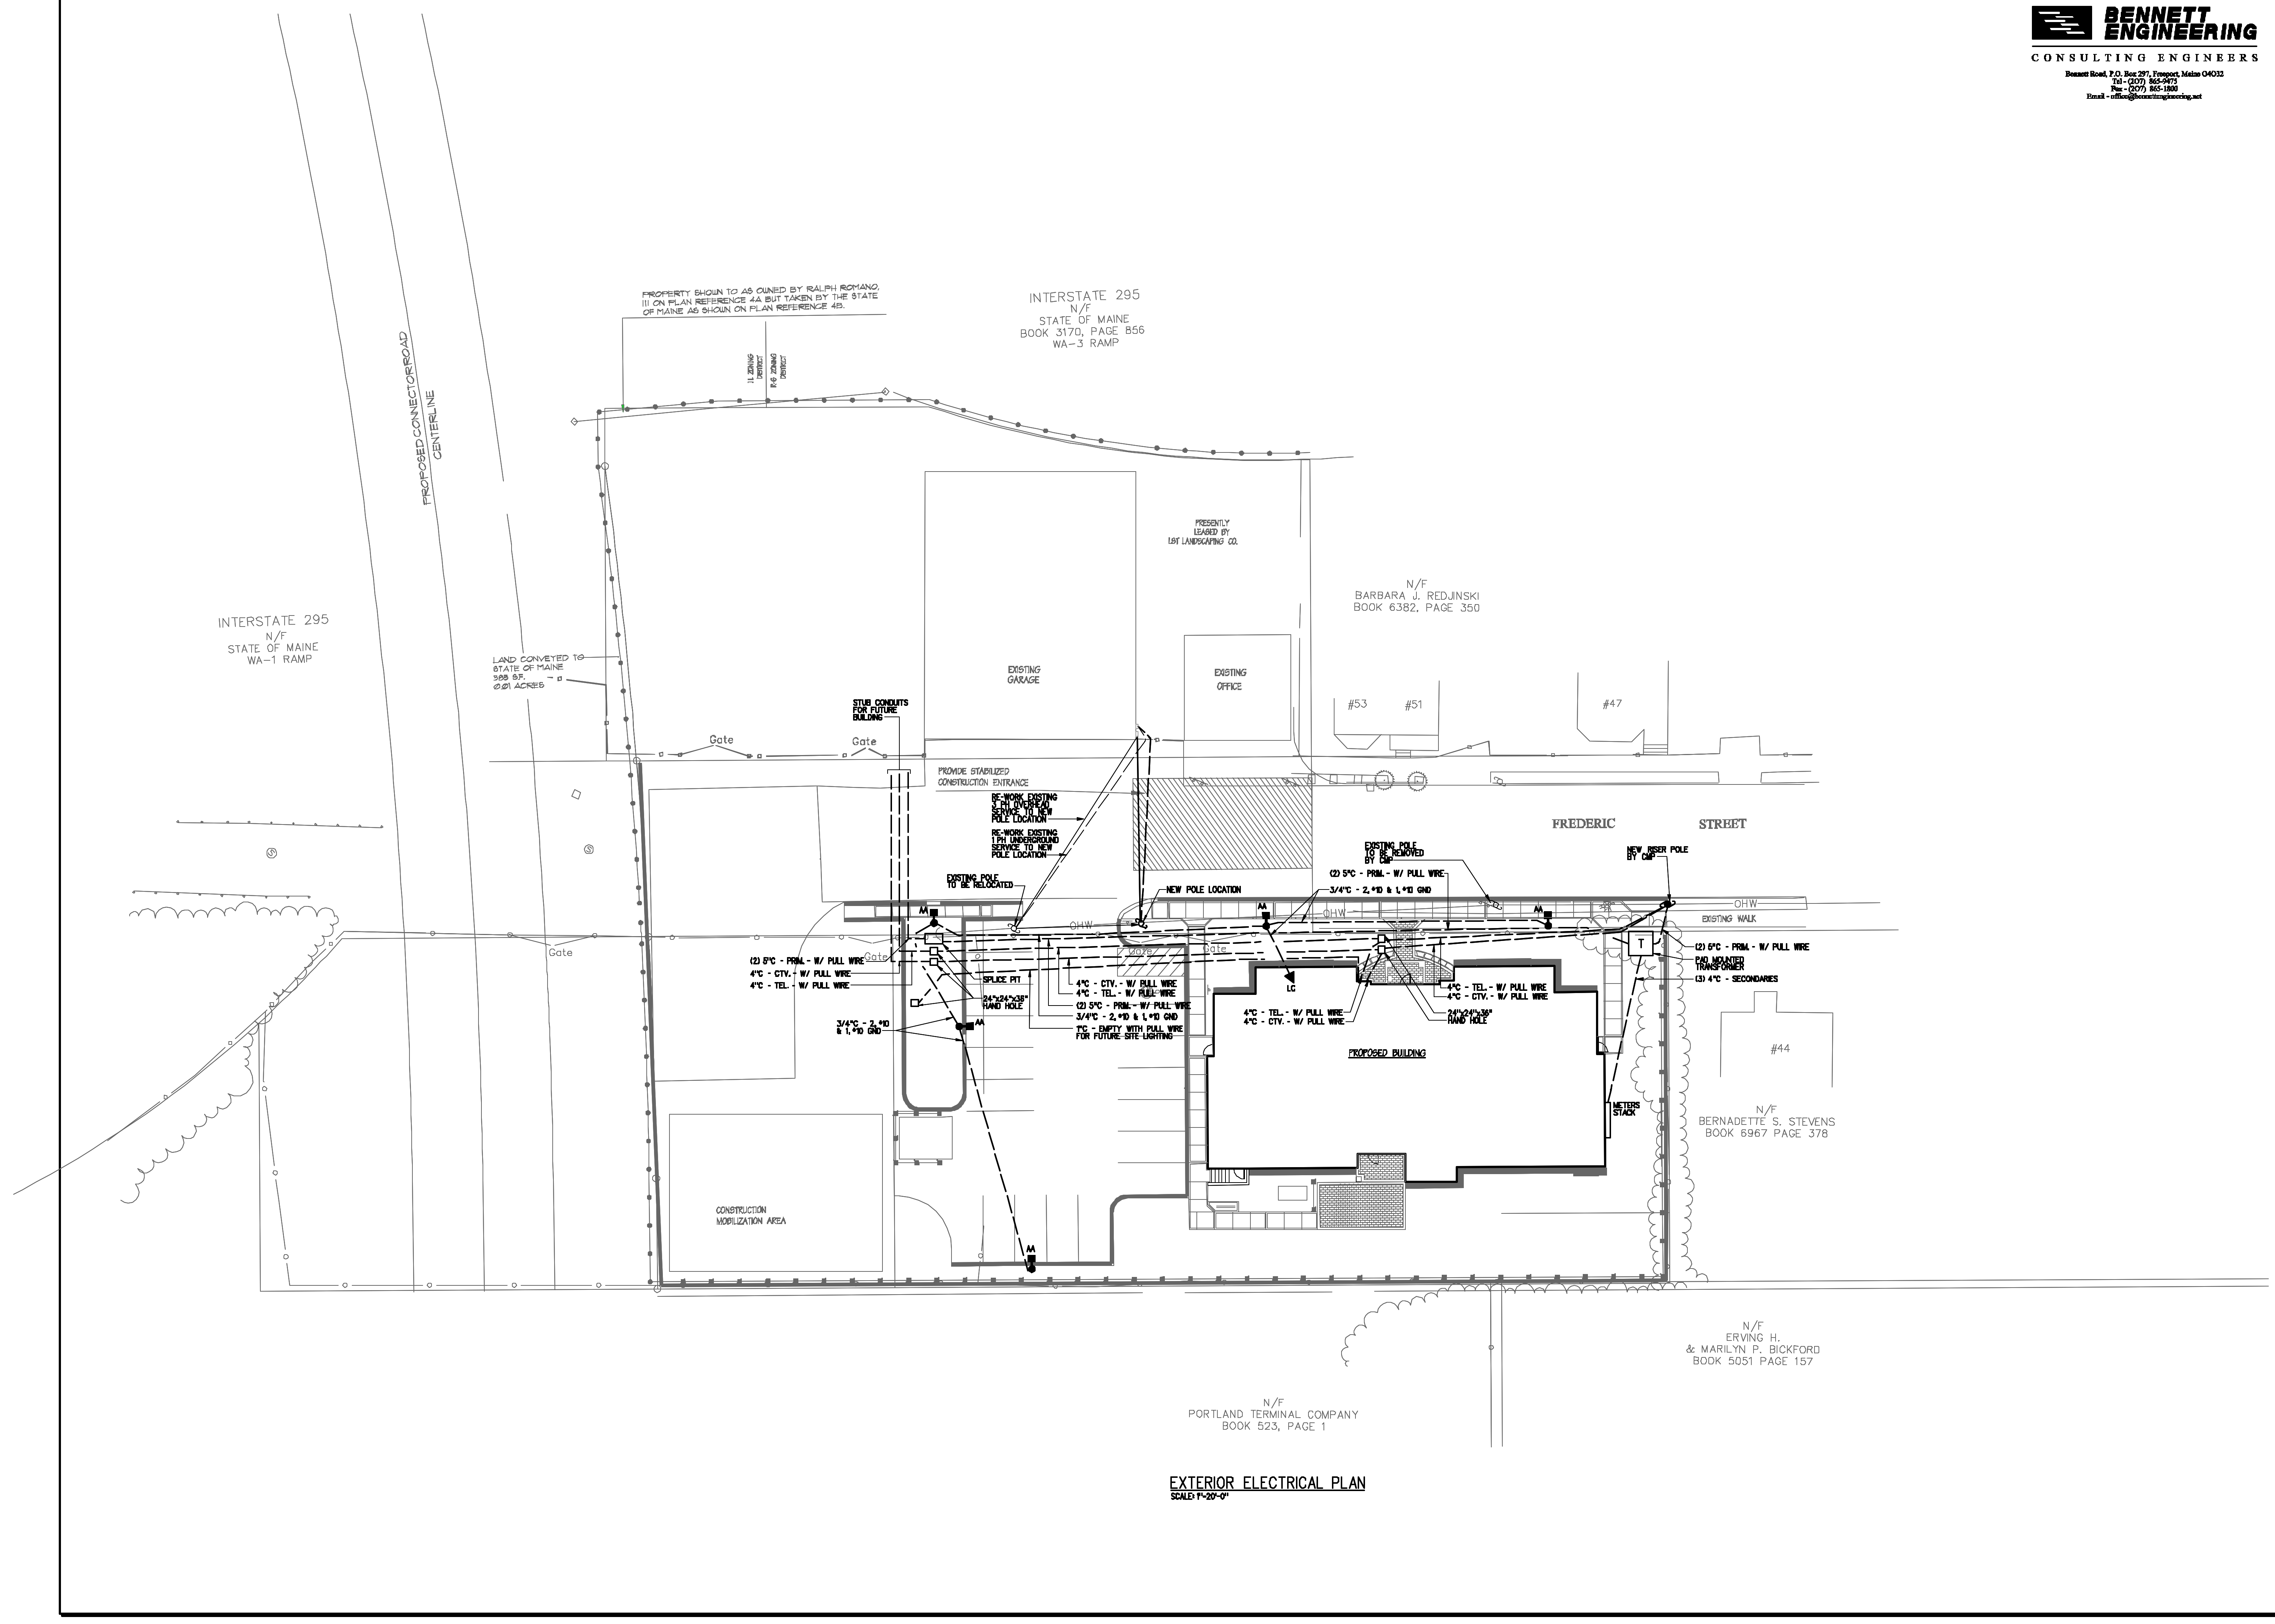

**EXTERIOR ELECTRICAL PLAN**  
 SCALE: 1"=20'-0"