


- ▲
- ▲
- ▲
- ▲
- ▲

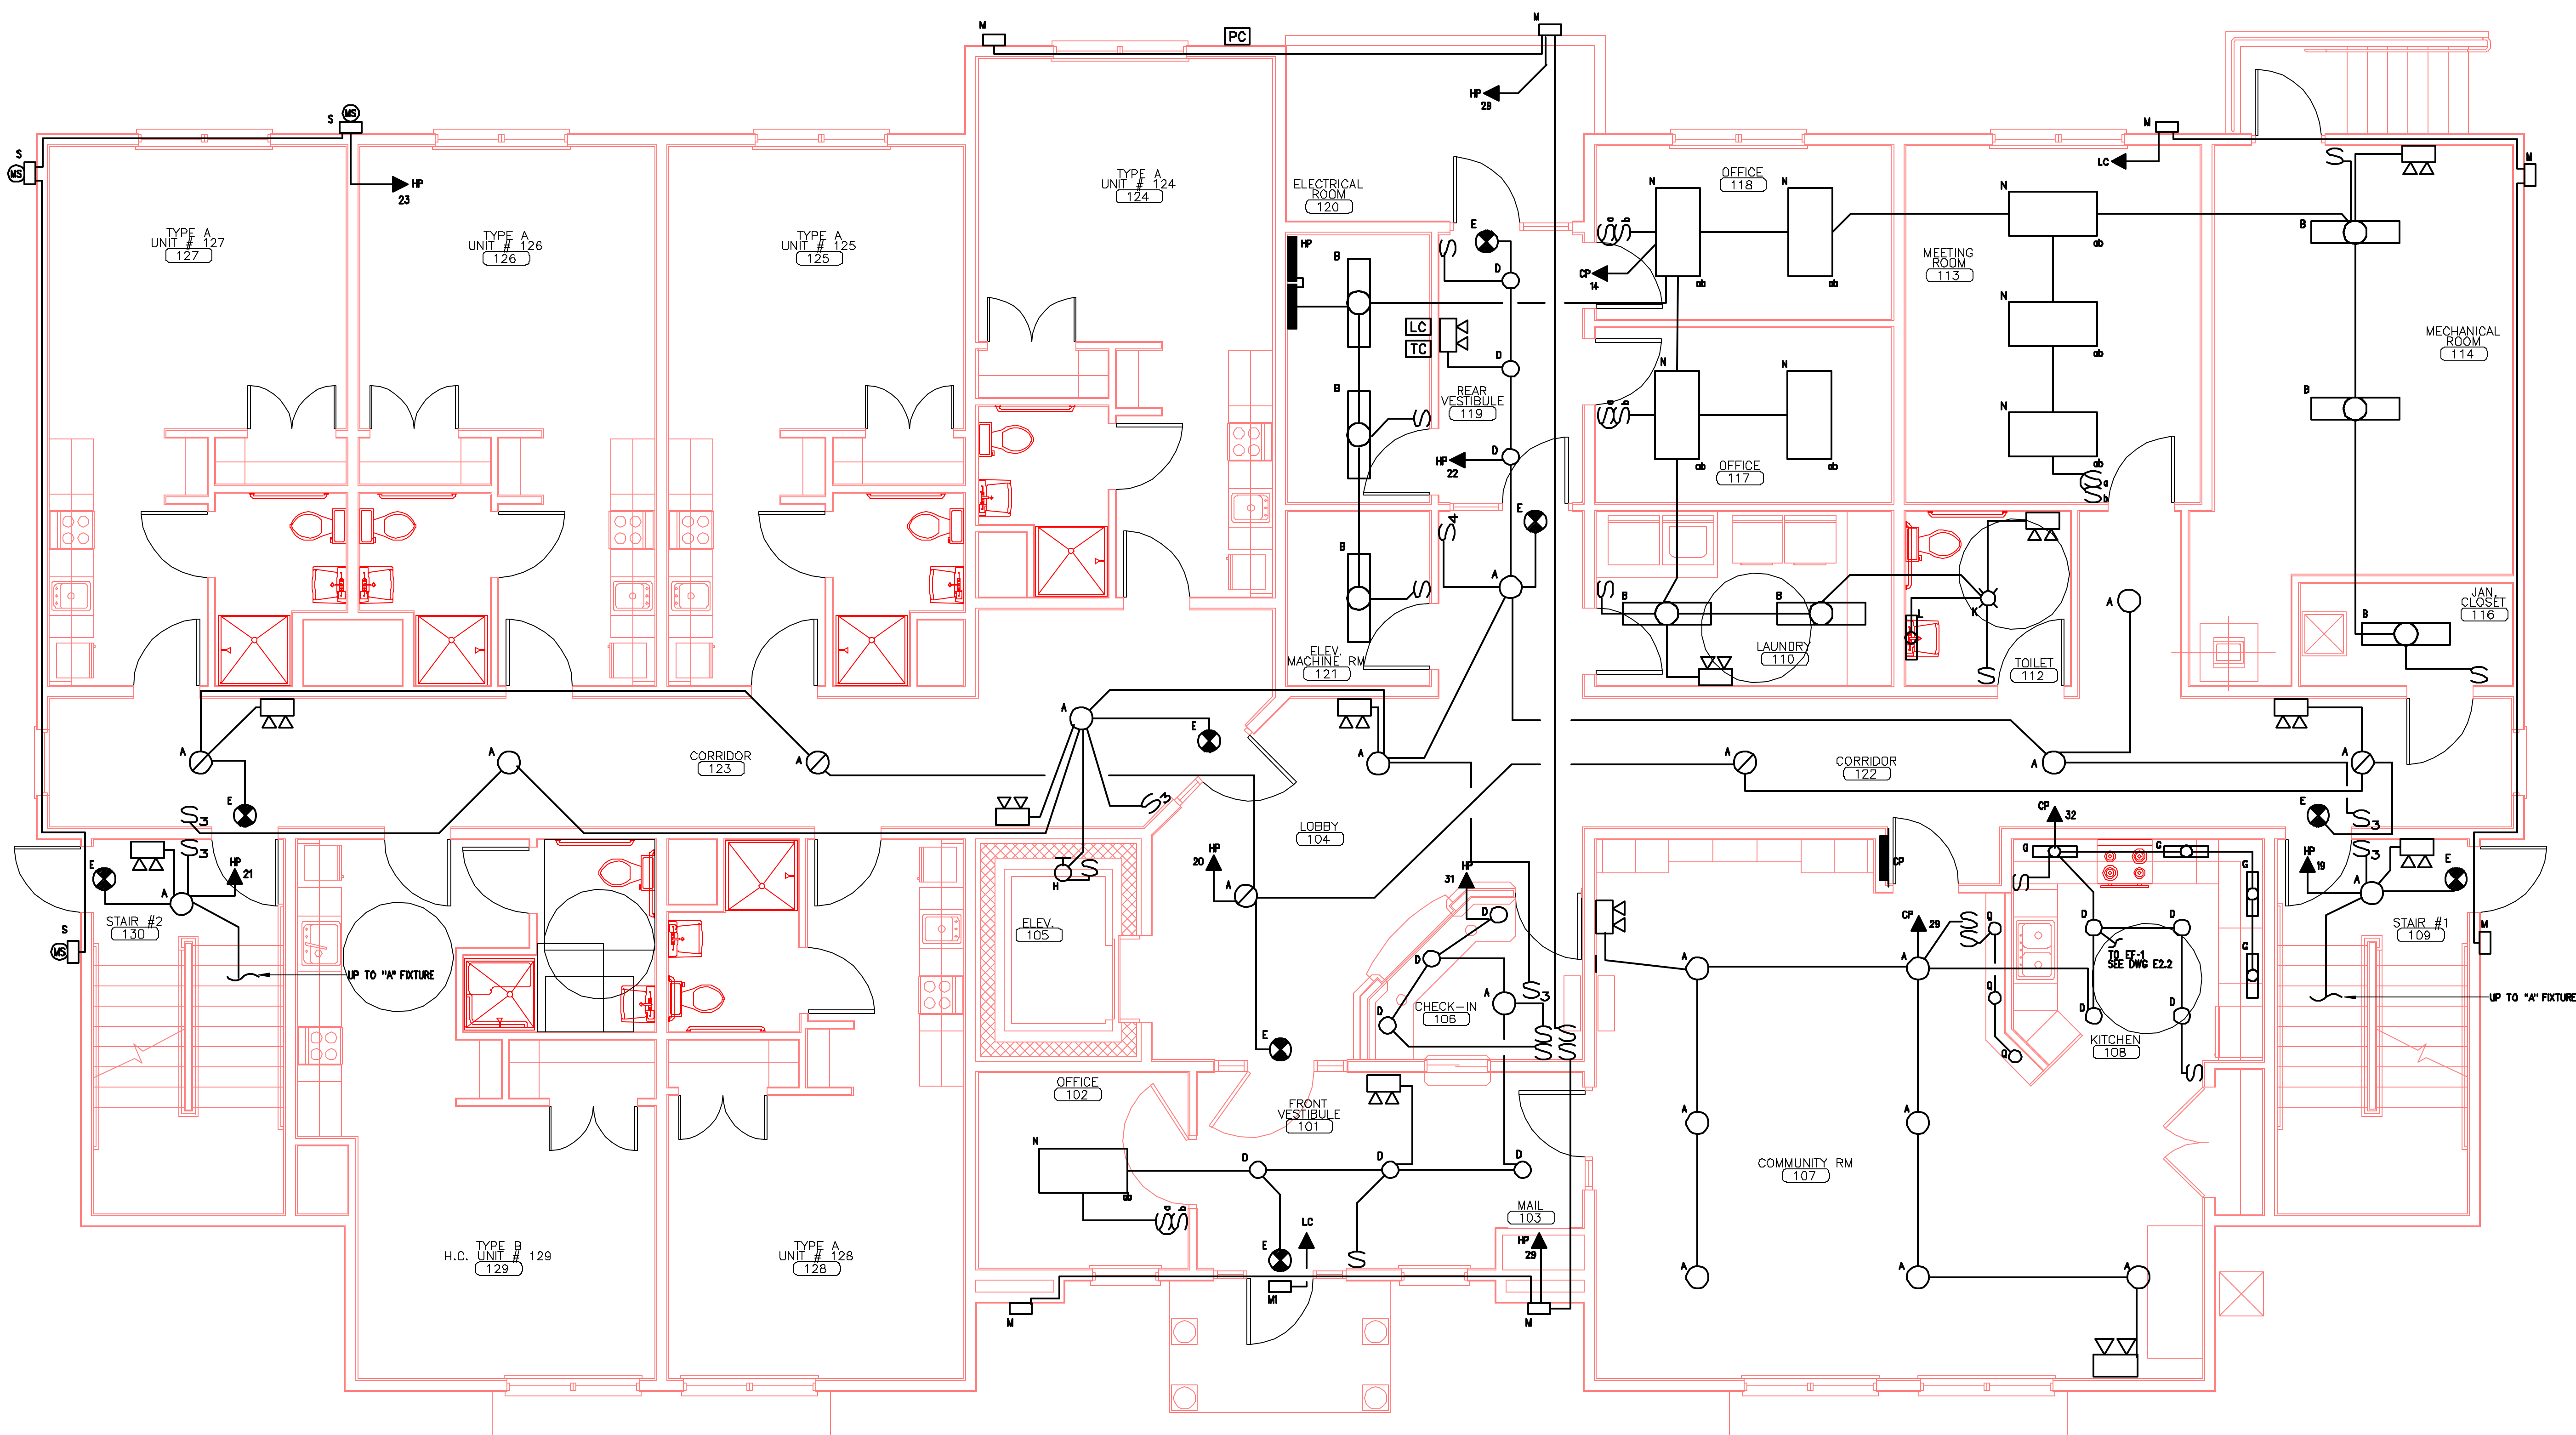

FIRST FLOOR LIGHTING PLAN
 SCALE 1/4"=1'-0"