




**TYPE A ELECTRICAL PLAN**  
 SCALE: 1/4"=1'-0"

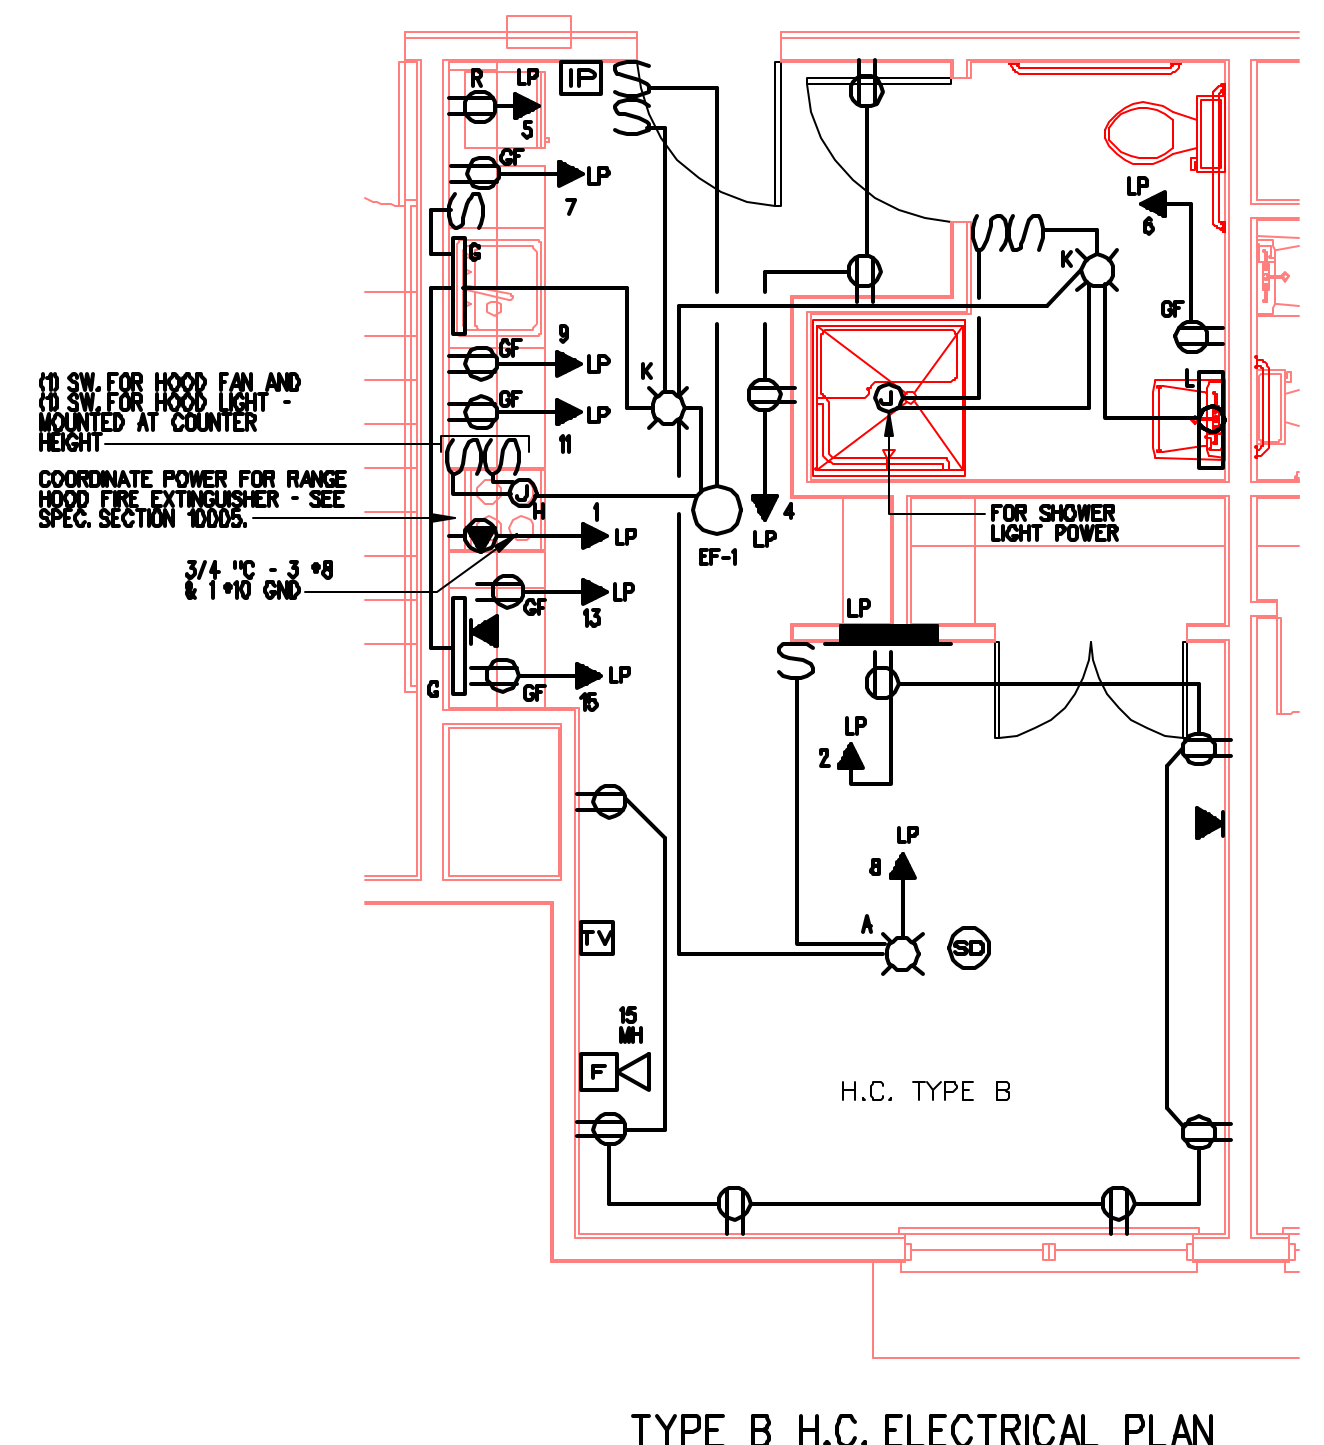

**TYPE B H.C. ELECTRICAL PLAN**  
 SCALE: 1/4"=1'-0"

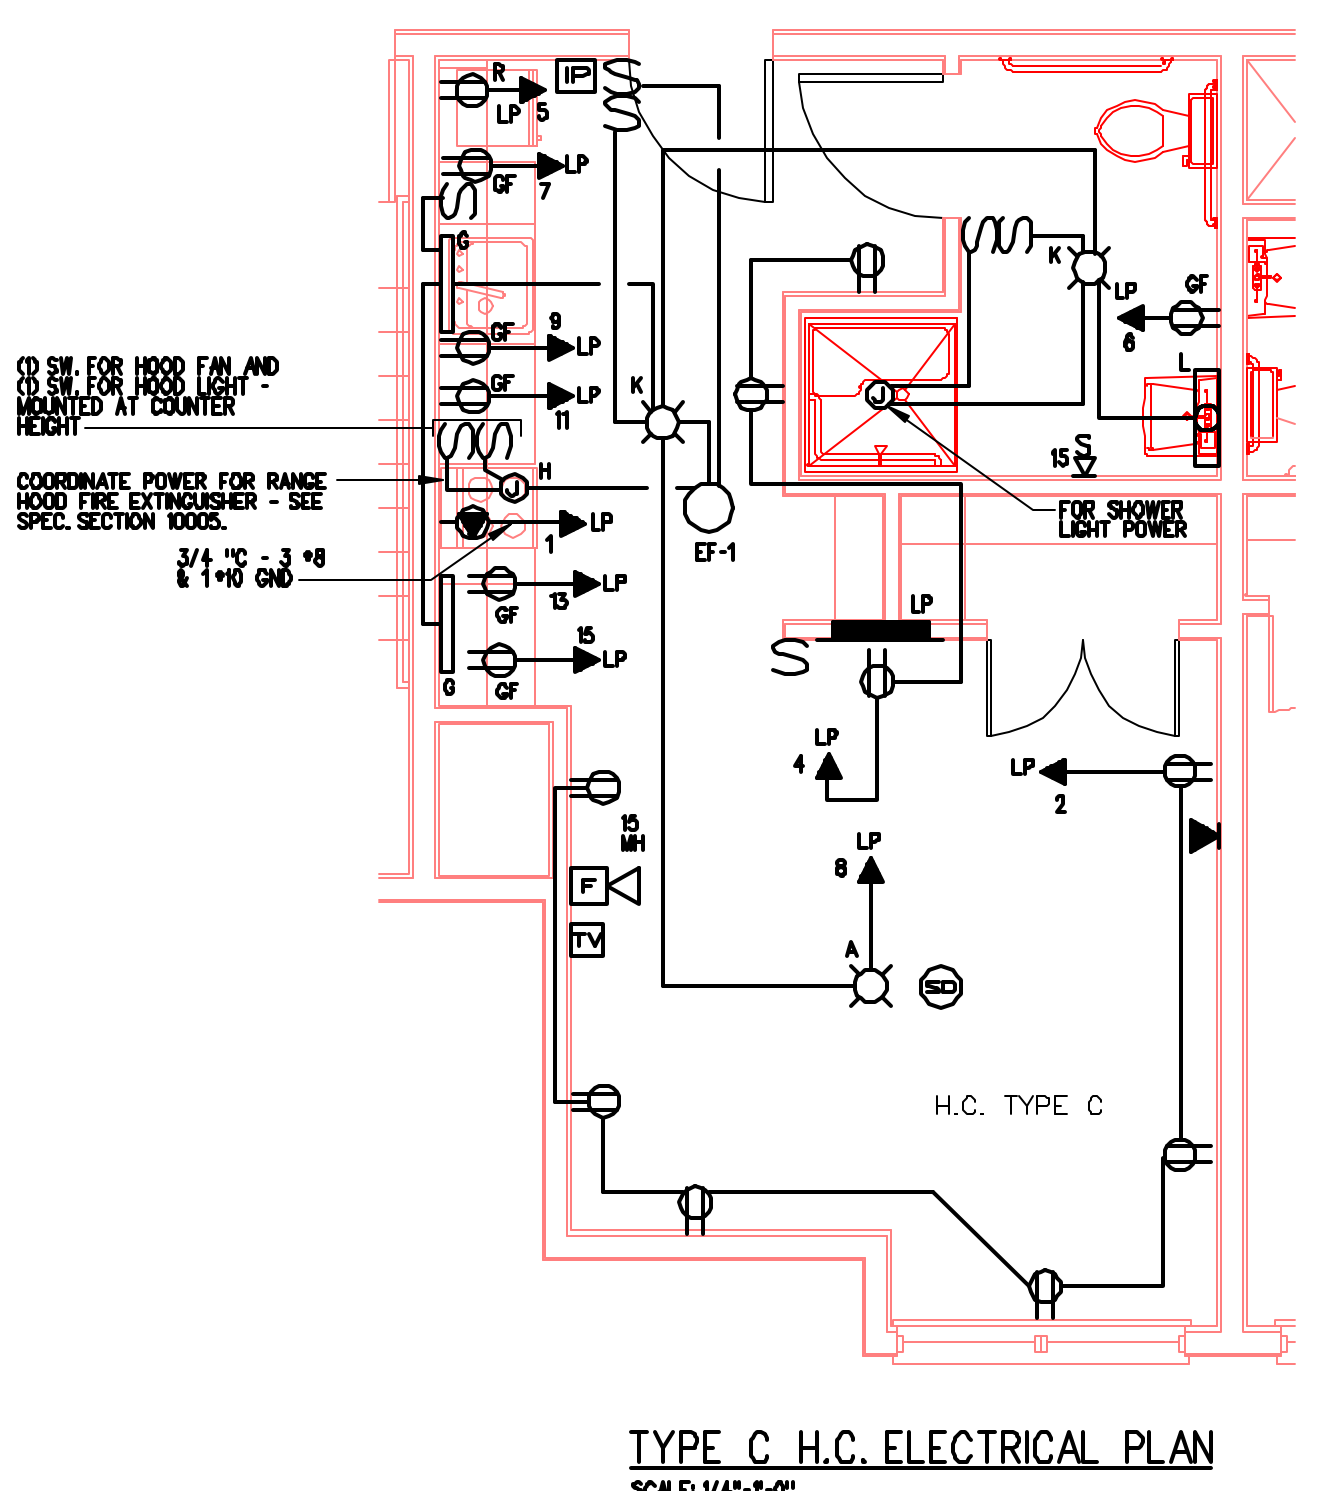

**TYPE C H.C. ELECTRICAL PLAN**  
 SCALE: 1/4"=1'-0"

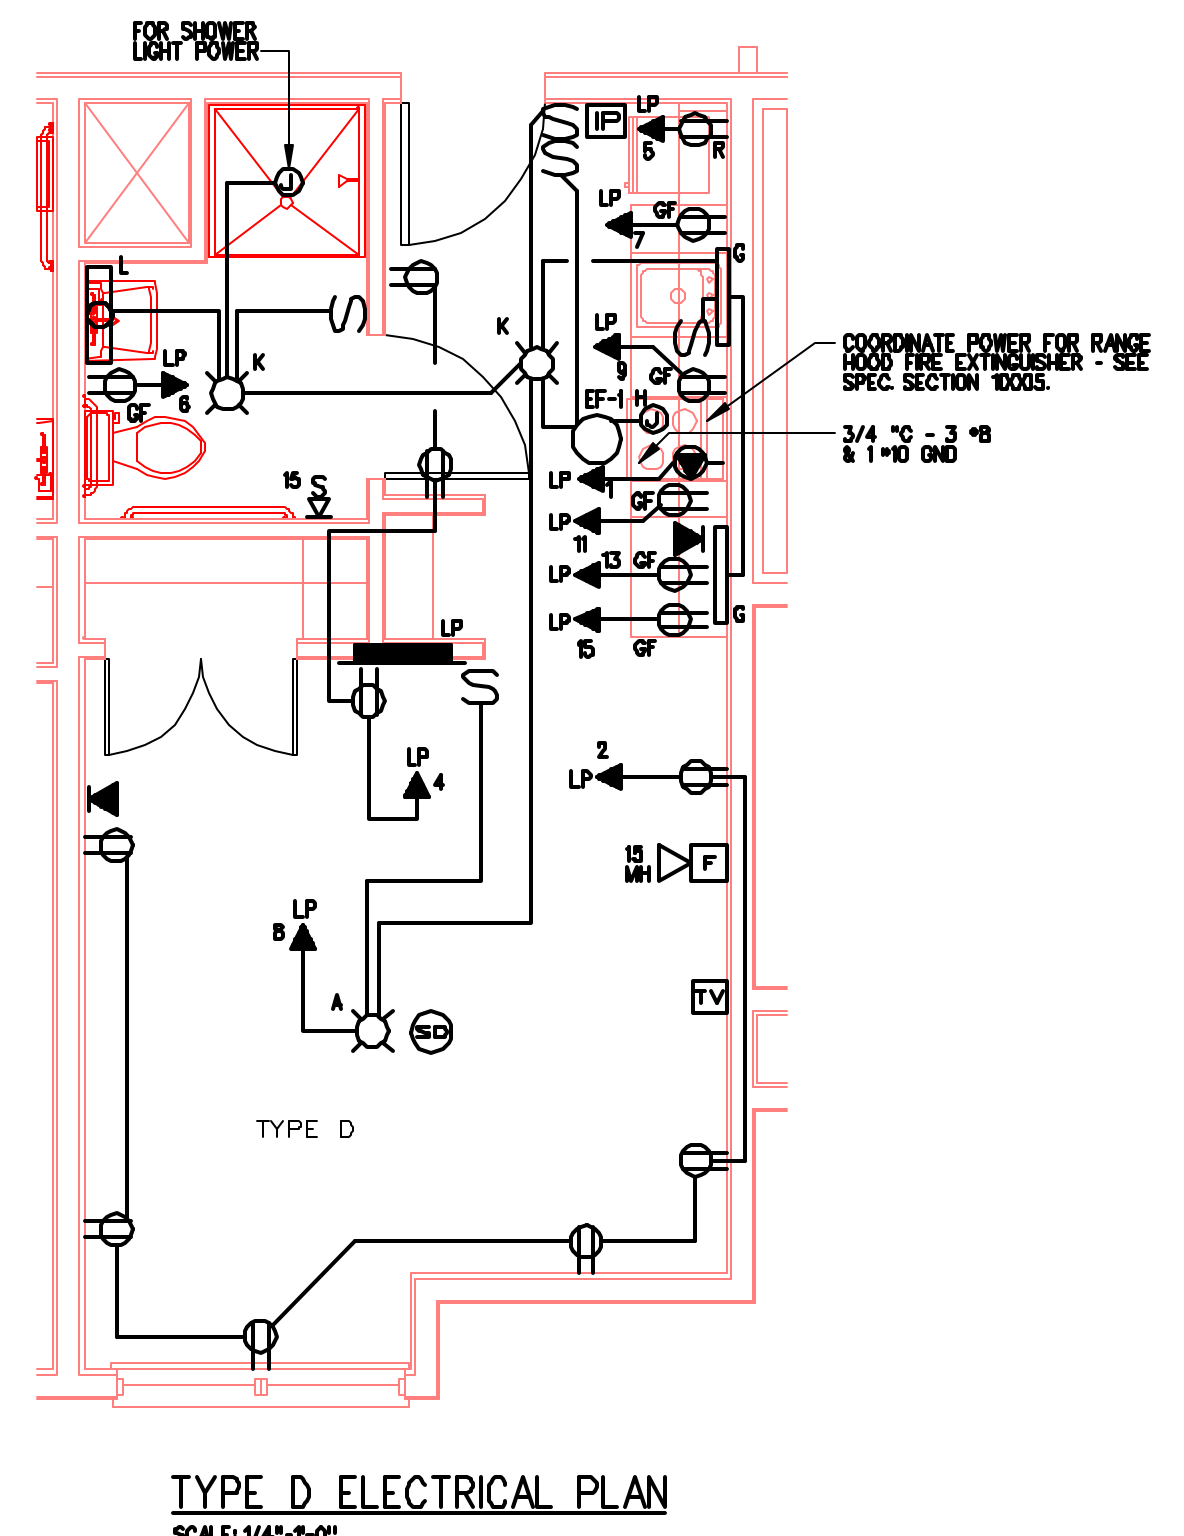

**TYPE D ELECTRICAL PLAN**  
 SCALE: 1/4"=1'-0"

PROJECT:		SINGLE PHASE		PANEL DESIGNATION:	
LOGAN PLACE		PANELBOARD SCHEDULE		10000 AC (TYPICAL TERRY PANEL)	
PORTLAND, MAINE		RECESSED			
MAIN LUSIS 100A		VOLTS: 120/208		PHASE: 1	
				WIRE: 3	
KVA LOAD	LOADCENTER			10,000 AC	KVA LOAD
X 4.0	RANGE	1-2P	20	EP-2	OUTLETS 1.4
X 4.0		50	20	EP-4	OUTLETS .80
1.5	REFRIGERATOR	5-2P	20	EP-6	BATHROOM OUTLET 1.5
1.5	COUNTER OUTLETS	7-2P	20	EP-8	LIGHTING 1.5
1.5	COUNTER OUTLETS	8-2P	20	EP-10	SPARE
1.5	COUNTER OUTLETS	11-2P	20	EP-12	
1.5	COUNTER OUTLETS	13-2P	20	EP-14	SPACE
1.5	COUNTER OUTLETS	18-2P	20	EP-16	
TOTAL CONN. LOAD 22.0 KVA			TOTAL DEM. LOAD _____		

NOTE: ALL PANELS TO BE KEYS TO SAME KEY.  
 X PROVIDE WITH SHUNT TRIP

Owner:  
**YC PORTLAND L.P.**  
 C/O AVESTA  
 307 CUMBERLAND AVE  
 PORTLAND, MAINE 04101  
 (207) 563-7777

Client:  
**YORK-CUMBERLAND**  
 HOUSING DEVELOPMENT

**LOGAN PLACE**  
 PORTLAND, MAINE

Project No: 01409 SRO

Drawing Title:  
**TYPICAL UNITS**  
**ELECTRICAL PLAN**

Scale: AS NOTED  
 Date: JANUARY 14, 2004

- Revisions:
- △
  - △
  - △
  - △
  - △
  - △

Drawing Number:  
**E3.1**