


ALPHAarchitects  
 17 CHESTNUT STREET  
 PORTLAND, ME 04101  
 PHONE: 207.761.9500  
 FAX: 207.761.9595  
 design@alphaarchitects.com

COPYRIGHT

Reuse or reproduction of the contents of this document is not permitted without written permission of ALPHA ARCHITECTS

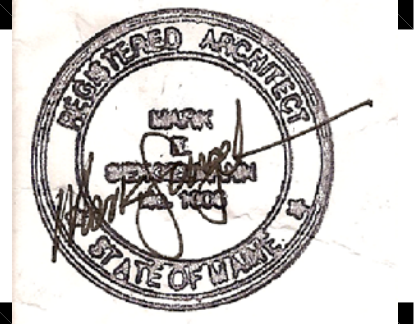

**Westfield Building**  
 17 Westfield Street  
 Portland, ME. 04102

JOB: 15162

ISSUE DATE	
PRELIM	08-18-15
PLANNING	01-19-16
CD's	01-27-15
REV. 1	02-04-16
REV. 2	05-06-16
PRINT	05-23-16

ENLARGED PLANS & DOOR SCHEDULE

A1.1


05-23-16

DOOR SCHEDULE


DOOR NO.	LOCATION	TYPE	MAT.	SIZE			HARDWARE	REMARKS
				W	H	T		
001A	EXIT HALL	NEW SC	BIRCH VENEER	3-0	6-8	1 3/4"	L, CL	45 MINUTE, STAIN POLYURETHANE
001B	EXIT HALL	NEW	METAL INSUL	3-0	7-0	1 3/4"	LL, CL, WS	PAINT, PEEP
002A	LL HVAC / SPRINKLER	NEW	METAL INSUL	3-0	7-0	1 3/4"	LL, CL, WS	PEEP, PAINT
101A	OFFICE	EXIST.	METAL	3-0	7-0	1 3/4"	NEW L	CLEAN, PRIME, PAINT & LUBE
101B	OFFICE	EXIST.	METAL	3-0	7-0	1 3/4"	NEW L	CLEAN, PRIME, PAINT & LUBE
101C	OFFICE	EXIST.	METAL	2-8	6-8	1 3/4"	NEW L, ST	CLEAN, PRIME, PAINT & LUBE
103A	UNISEX	EXIST.	METAL	2-8	6-8	1 3/4"	NEW LL	CLEAN, PRIME, PAINT & LUBE
104A	CLOSET	EXIST.	METAL	3-0	6-8	1 3/4"	NEW L	PAINT
104B	STORAGE	EXIST.	METAL	3-0	7-0	1 3/4"	NEW L	PAINT
105A	WORKSHOP/LAB	NEW	METAL	3-0	6-8	1 3/4"	L, TTDB, ST	PAINT
105B	WORKSHOP/LAB	NEW	METAL	3-0	6-8	1 3/4"	L, TTDB	PAINT
106A	TASTING ROOM	NEW	METAL INSUL	3-0	7-0	1 3/4"	CB, CL, WS, LP	PEEP, PAINT
106B	TASTING ROOM	NEW 4" STRFRNT	ALUM/GLASS	2)3-0	7-0	1 3/4"	CB, CL, WS, LP	FULL TGL, BROWN ANODIZED ALUM
108A	MEN	NEW SC	BIRCH VENEER	3-0	6-8	1 3/4"	CL, LP, KP	STAIN, POLYURETHANE
108A	WOMEN	NEW SC	BIRCH VENEER	3-0	6-8	1 3/4"	CL, LP, KP	STAIN, POLYURETHANE
112A	COOLER	SPECIAL	ALUM INSUL	3-0	6-8	±4"	CL, PANIC	LOCKOUT PROTECTION BY MANUF'R
112B	COOLER	SPECIAL	ALUM INSUL	3-0	6-8	±4"	CL, PANIC	LOCKOUT PROTECTION BY MANUF'R
114A	BOILER ROOM	NEW	METAL	3-0	6-8	1 3/4"	LL	45 MINUTE, PAINT
115A	DELIVERY	NEW	METAL INSUL	3-0	7-0	1 3/4"	CB, CL, WS, LP	PEEP, PAINT
203A	PAINT	NEW SC	BIRCH VENEER	3-0	6-8	1 3/4"	L, CL	STAIN, POLYURETHANE
204A	OFFICE	NEW SC	BIRCH VENEER	3-0	6-8	1 3/4"	LL, CL, KP	STAIN, POLYURETHANE
204B	OFFICE	NEW SC	BIRCH VENEER	3-0	6-8	1 3/4"	LL, CL, KP	45 MINUTE, PEEP, STAIN, POLYURETHANE
205A	UNISEX	NEW SC	BIRCH VENEER	3-0	6-8	1 3/4"	LL, CL, KP	STAIN, POLYURETHANE
301A	WORKROOM	NEW 1/2 TGL	BIRCH VENEER	3-0	6-8	1 3/4"	L, ST	STAIN, POLYURETHANE
302A	OFFICE 3	HC 6 PANEL	BIRCH VENEER	3-0	6-8	1 3/4"	LL	POLYURETHANE, LUBE
303A	OFFICE 2	HC 6 PANEL	BIRCH VENEER	3-0	6-8	1 3/4"	LL, ST	POLYURETHANE, LUBE
304A	OFFICE 1	HC 6 PANEL	BIRCH VENEER	3-0	6-8	1 3/4"	LL, ST	POLYURETHANE, LUBE
305A	INVENTORY *	EXIST.	ALUM TGL	3-0	7-0	1 3/4"	LP, CL, TTDB, WS	REMOVE BLADE PULL, LUBRICATE
305C	INVENTORY	NEW 1/2 GLASS	SC- BIRCH v.	3-0	6-8	1 3/4"	L, CL	STAIN, POLYURETHANE
307A	ADA UNISEX 1	NEW SC	BIRCH VENEER	3-0	6-8	1 3/4"	LL, CL, KP	STAIN, POLYURETHANE
308A	ADA UNISEX 2	NEW SC	BIRCH VENEER	3-0	6-8	1 3/4"	LL, CL, KP	STAIN, POLYURETHANE
310A	WORK AREA	NEW	METAL INSUL	3-0	7-0	1 3/4"	LL, CL, WS	PAINT, PEEP
310B	CUTTING AREA	NEW 1/2 TGL	BIRCH VENEER	3-0	7-0	1 3/4"	L, ST	STAIN, POLYURETHANE
401A	WAREHOUSE A	NEW	METAL INSUL	3-0	7-0	1 3/4"	LL, CL, WS	PAINT, PEEP
402B	WAREHOUSE B	NEW SC	BIRCH VENEER	3-0	6-8	1 3/4"	L, ST	STAIN, POLYURETHANE
403A	UNISEX	NEW SC	BIRCH VENEER	3-0	6-8	1 3/4"	LL, CL, KP	STAIN, POLYURETHANE

ABBREVIATIONS:


- LP = ADA LOOP PULL
- L = ADA LEVER
- LL = ADA LOCKING LEVER
- CL = DOOR CLOSER
- CB = CRASH BAR
- TTDB = THUMB TURN DEAD BOLT
- DS = DOOR STOP
- ST = WALL STOP
- PP = PUSH PLATE
- KP = KICK PLATE
- VP = VISION PANEL
- WS = WEATHER STRIPPING SYSTEM
- XS = (x = #) SHELVES

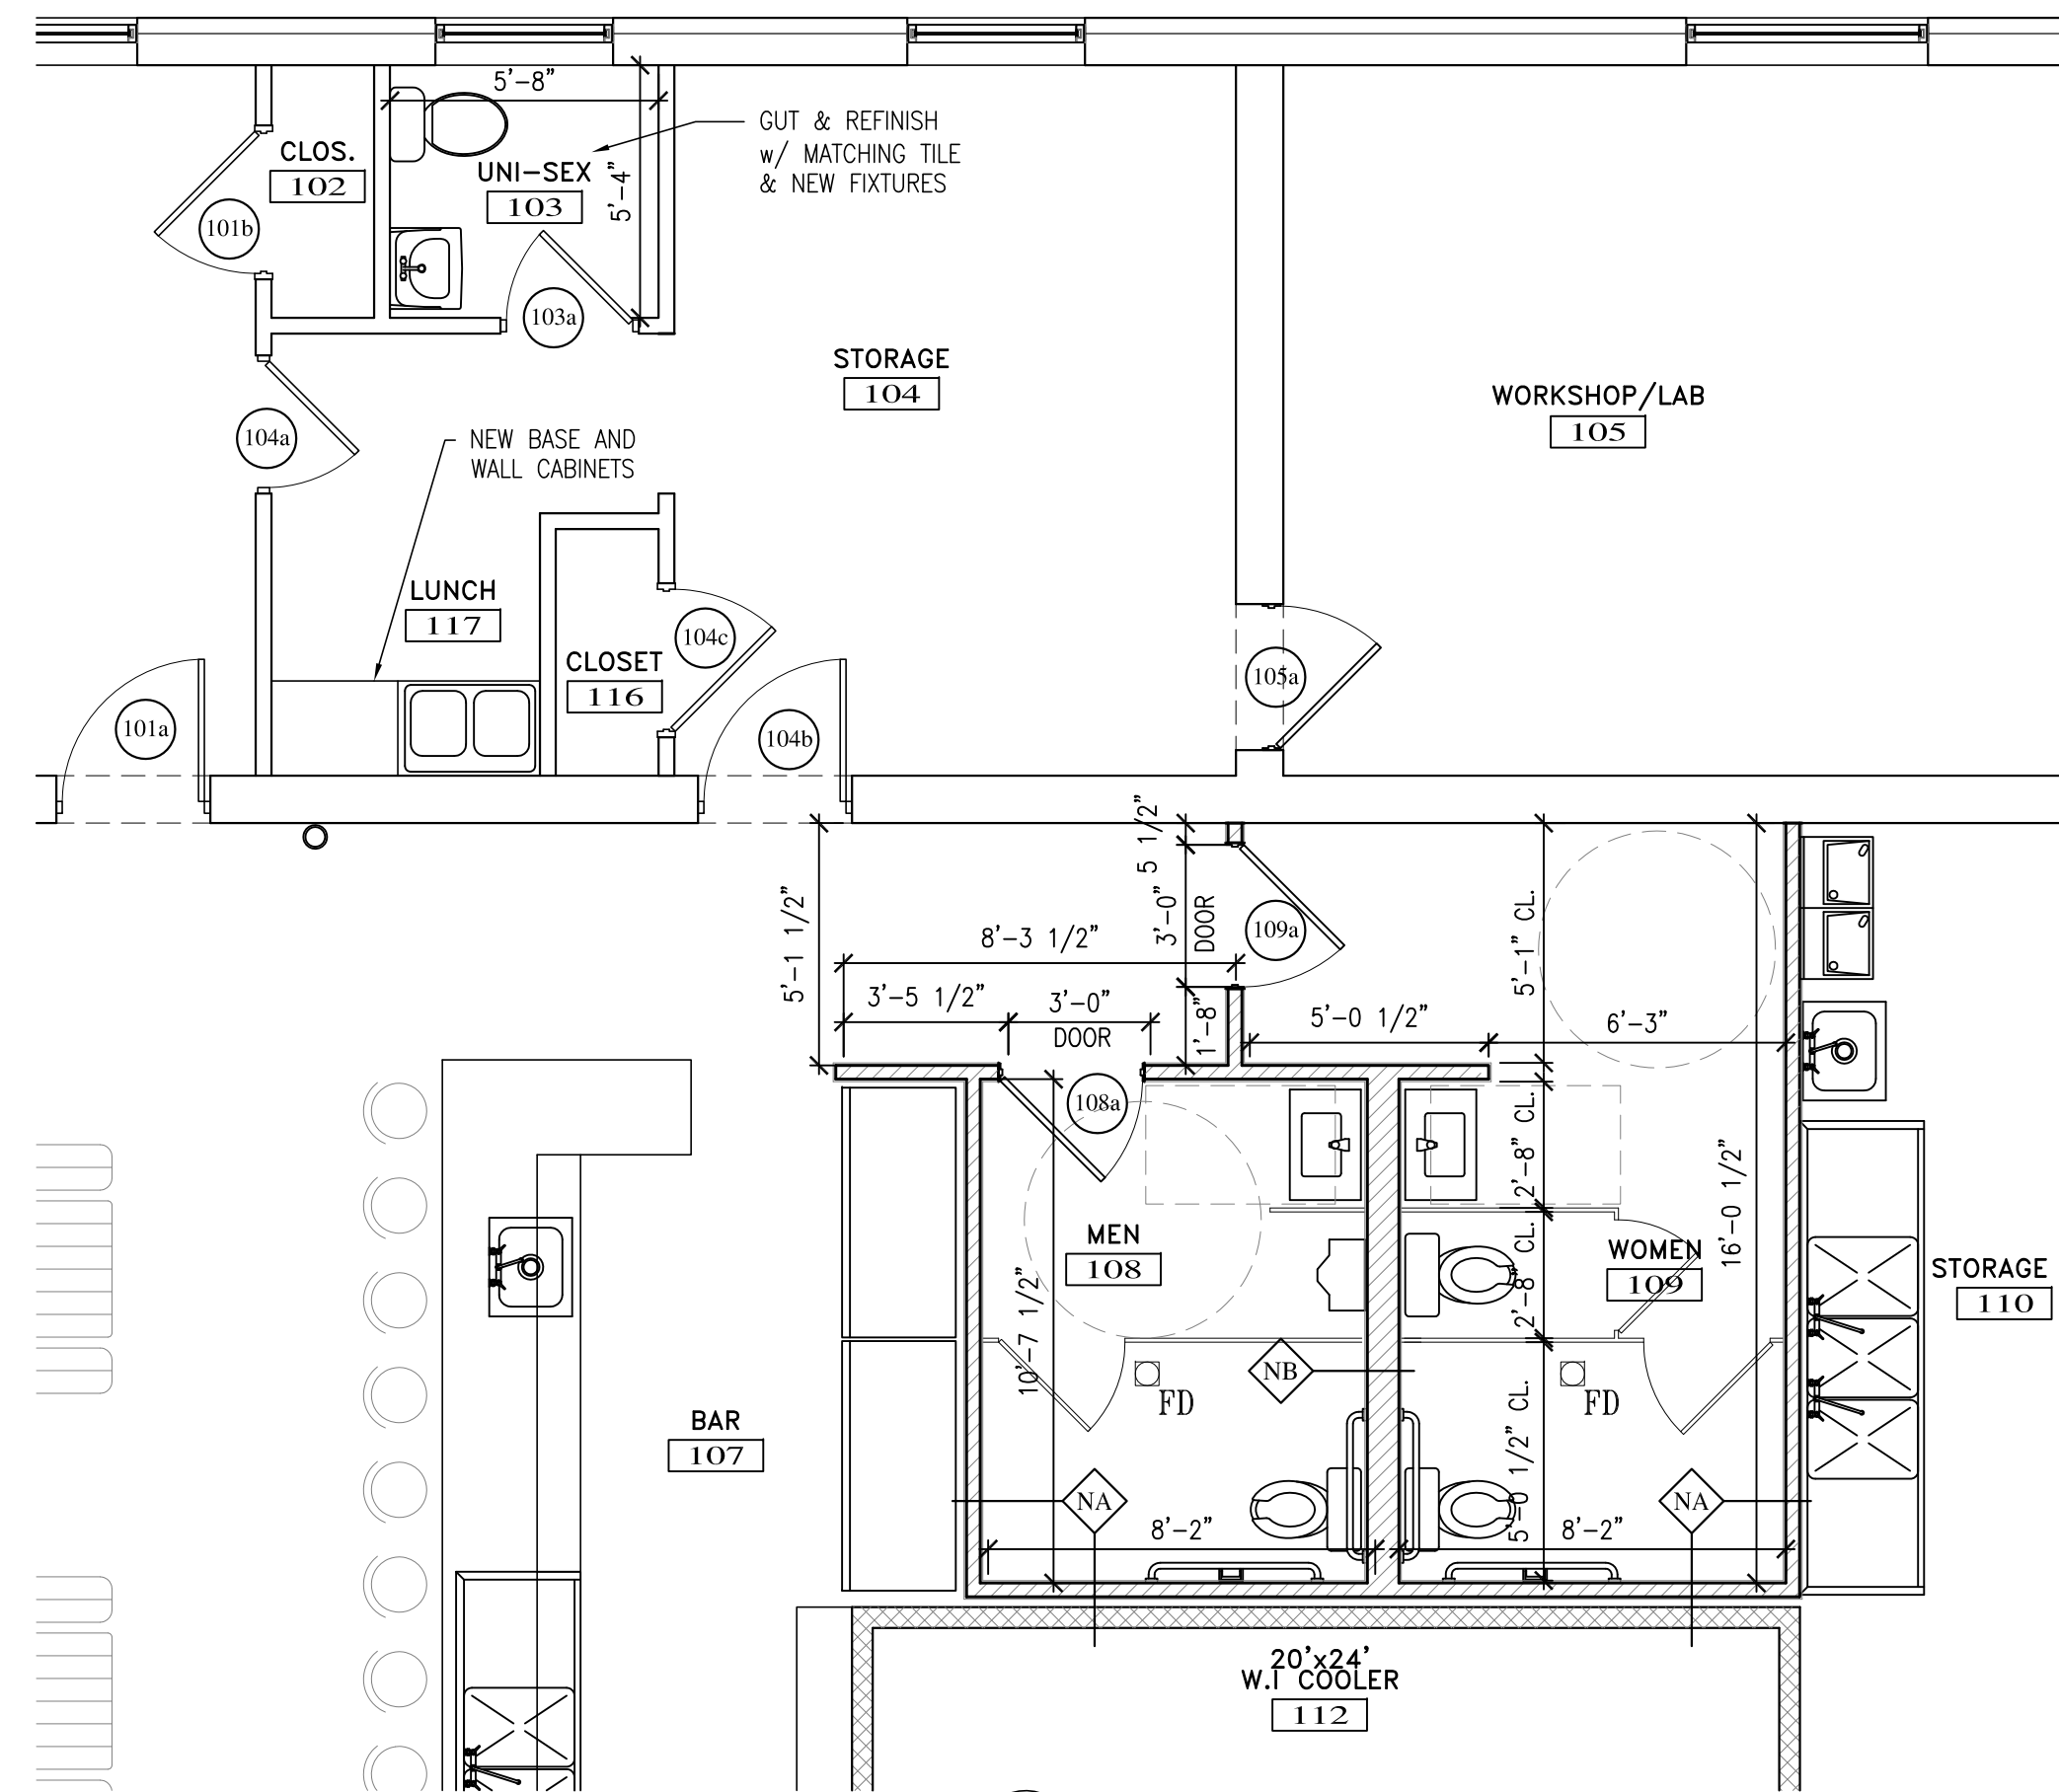

1 ENLARGED PLAN  
 A1.1 SCALE: 1/4" = 1'-0"

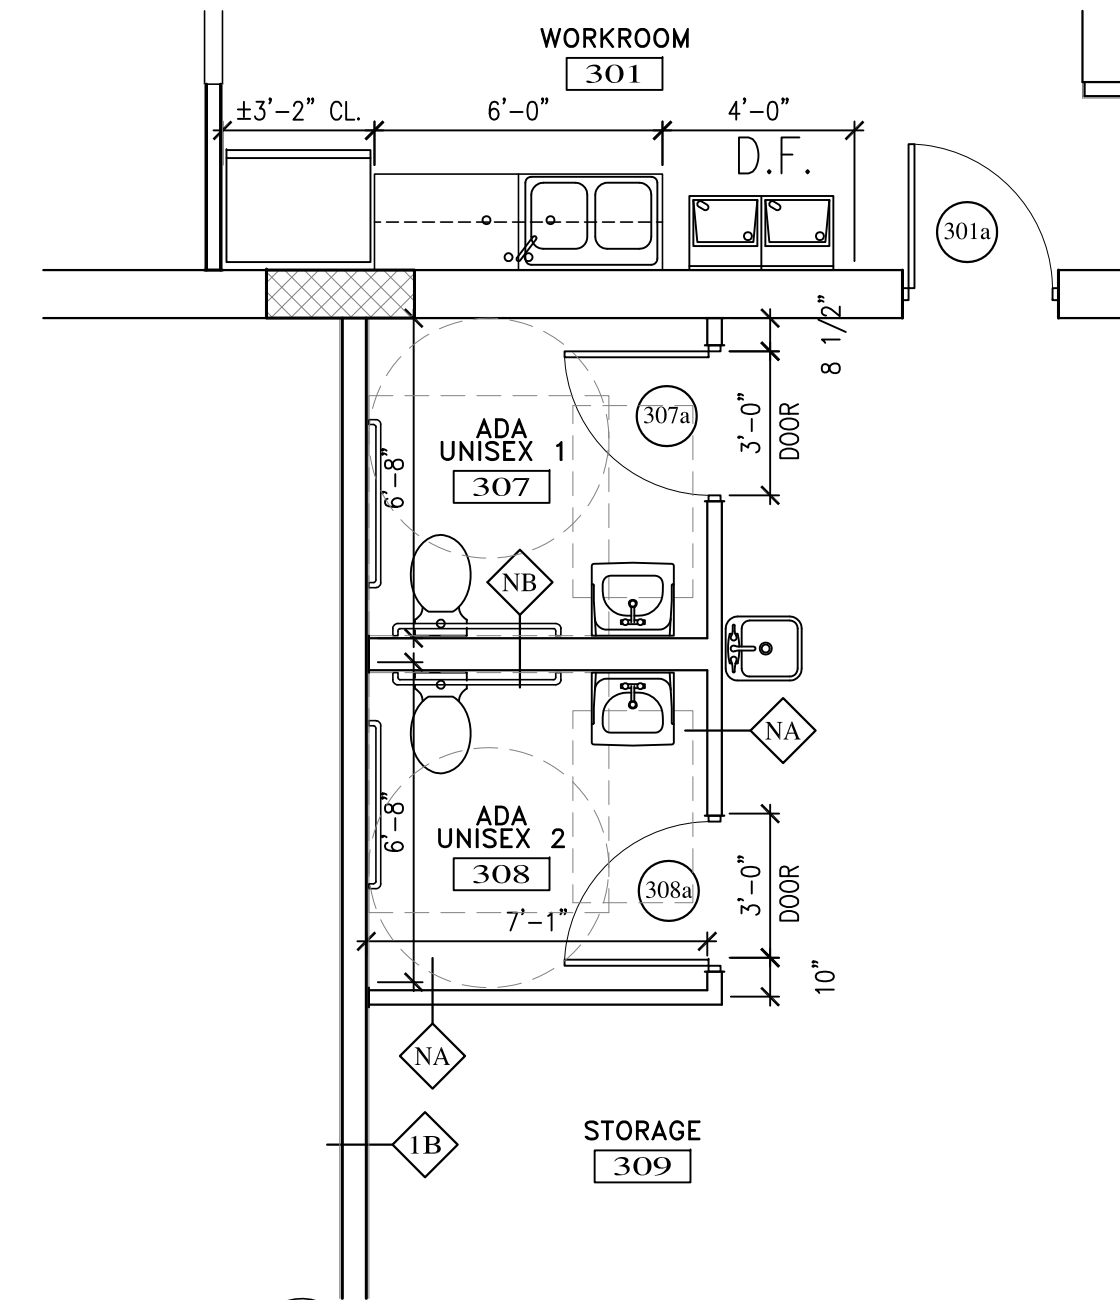

2 ENLARGED PLAN  
 A1.1 SCALE: 1/4" = 1'-0"

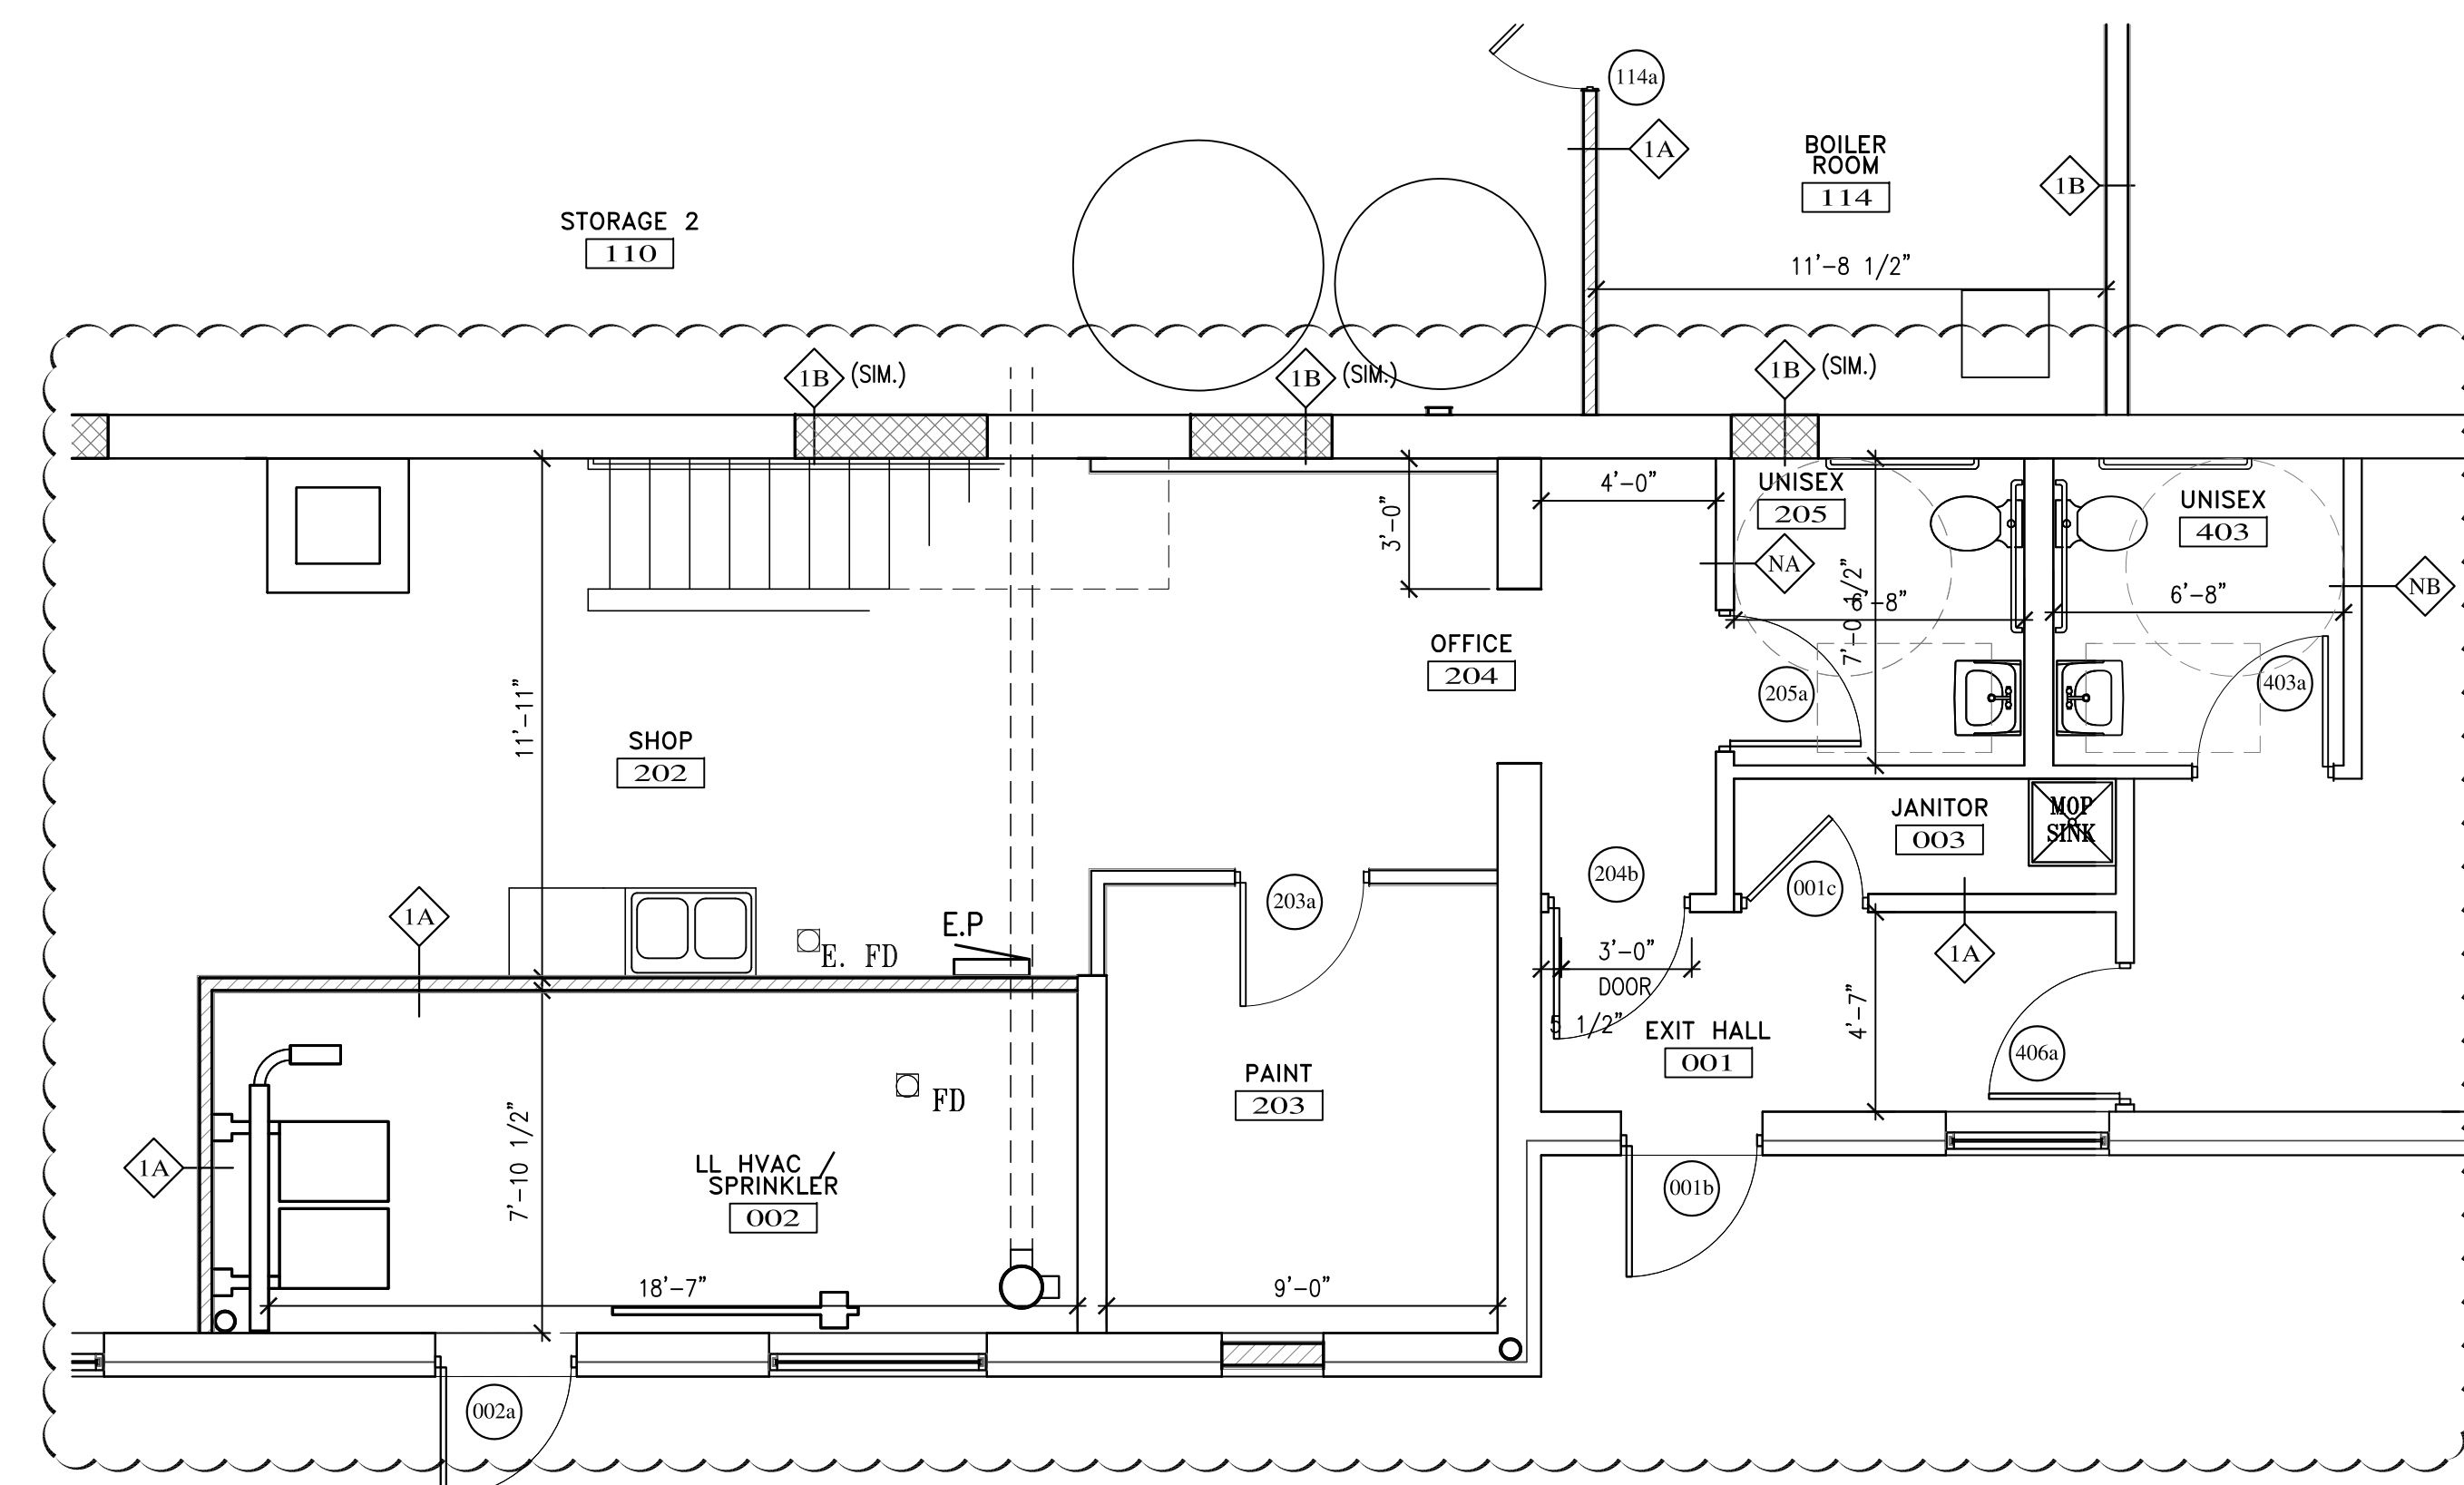

3 ENLARGED PLAN  
 A1.1 SCALE: 1/4" = 1'-0"