


REVISION	DESCRIPTION	DATE
0	ISSUED FOR REVIEW & APPROVAL	4/20/2016

RESERVED FOR CITY STAMP

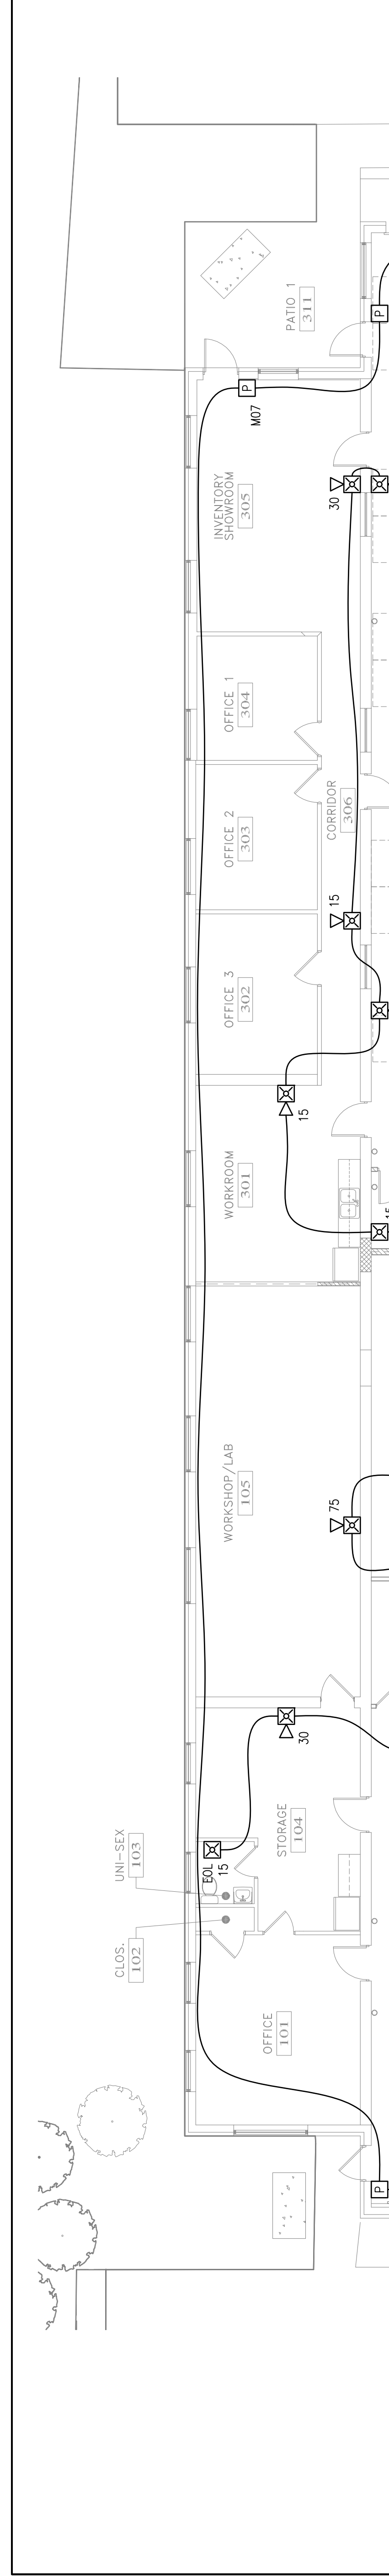


**CUNNINGHAM**  
Security Systems  
10 Princes Point Road, Yarmouth, Maine 04096  
Office: 207.846.3350 • Fax: 207.846.6080

**WESTFIELD BUILDING**  
17 WETFIELD STREET  
PORTLAND, MAINE 04102  
FIRE ALARM PLAN

DRAWN	JPB UNICAD JOB #16227
CHECKED	WAYNE B. HAWES NICET # 90496
DATE	4/20/2016
REVISION	0
SCALE	1/8"=1'-0"

**FA-2**

**UNICAD** Inc.  
Fire Alarm Design & Drafting Services  
www.unicad.net  
578 W. 40th St.  
Portland, ME 04102  
Office: 603.865.6410

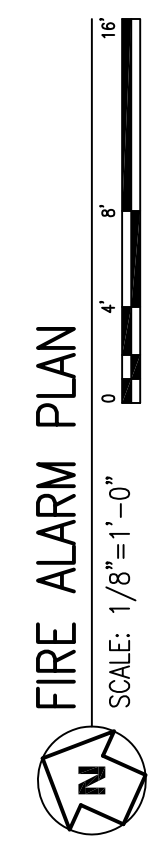

**SHEET NOTES:**

- ◆ ADDRESSABLE MONITOR MODULE(S) PROVIDED TO MONITOR ALL WATER FLOW PRESSURE SWITCHES, TAMPER SWITCHES AND POST INDICATING VALVES ASSOCIATED WITH THE FIRE SUPPLY WATER SYSTEM. INSTALLING CONTRACTOR SHALL VERIFY EXACT MOUNTING, CIRCUITING AND PROGRAMMING REQUIREMENTS. FIELD VERIFY EXACT QUANTITY AND LOCATION(S).