

GENERAL NOTES:


NO.	REVISION/ISSUE	DATE

CONVERSION OF EXISTING  
METER DEPARTMENT SHOP TO  
TRAINING AND MEETING FACILITY  
FOR  
PORTLAND WATER DISTRICT  
225 DOUGLAS ST. PORTLAND, MAINE

ZACHAU CONSTRUCTION, INC.  
1185 U.S. ROUTE ONE P.O. BOX J  
FREEPORT, MAINE 04032-0916  
TEL: (207) 865-9925 FAX: (207) 865-9926

THIS DRAWING HAS BEEN REVIEWED FOR COMPLIANCE  
WITH THE NFPA 101 LIFE SAFETY CODE 2000 AND THE  
AMERICANS WITH DISABILITIES ACT OF 1991 AND, TO  
THE BEST OF MY KNOWLEDGE AND BELIEF, CONFORMS  
WITH THE REQUIREMENTS OF THESE ORDINANCES.

EXISTING FLOOR PLAN AT METER SHOP

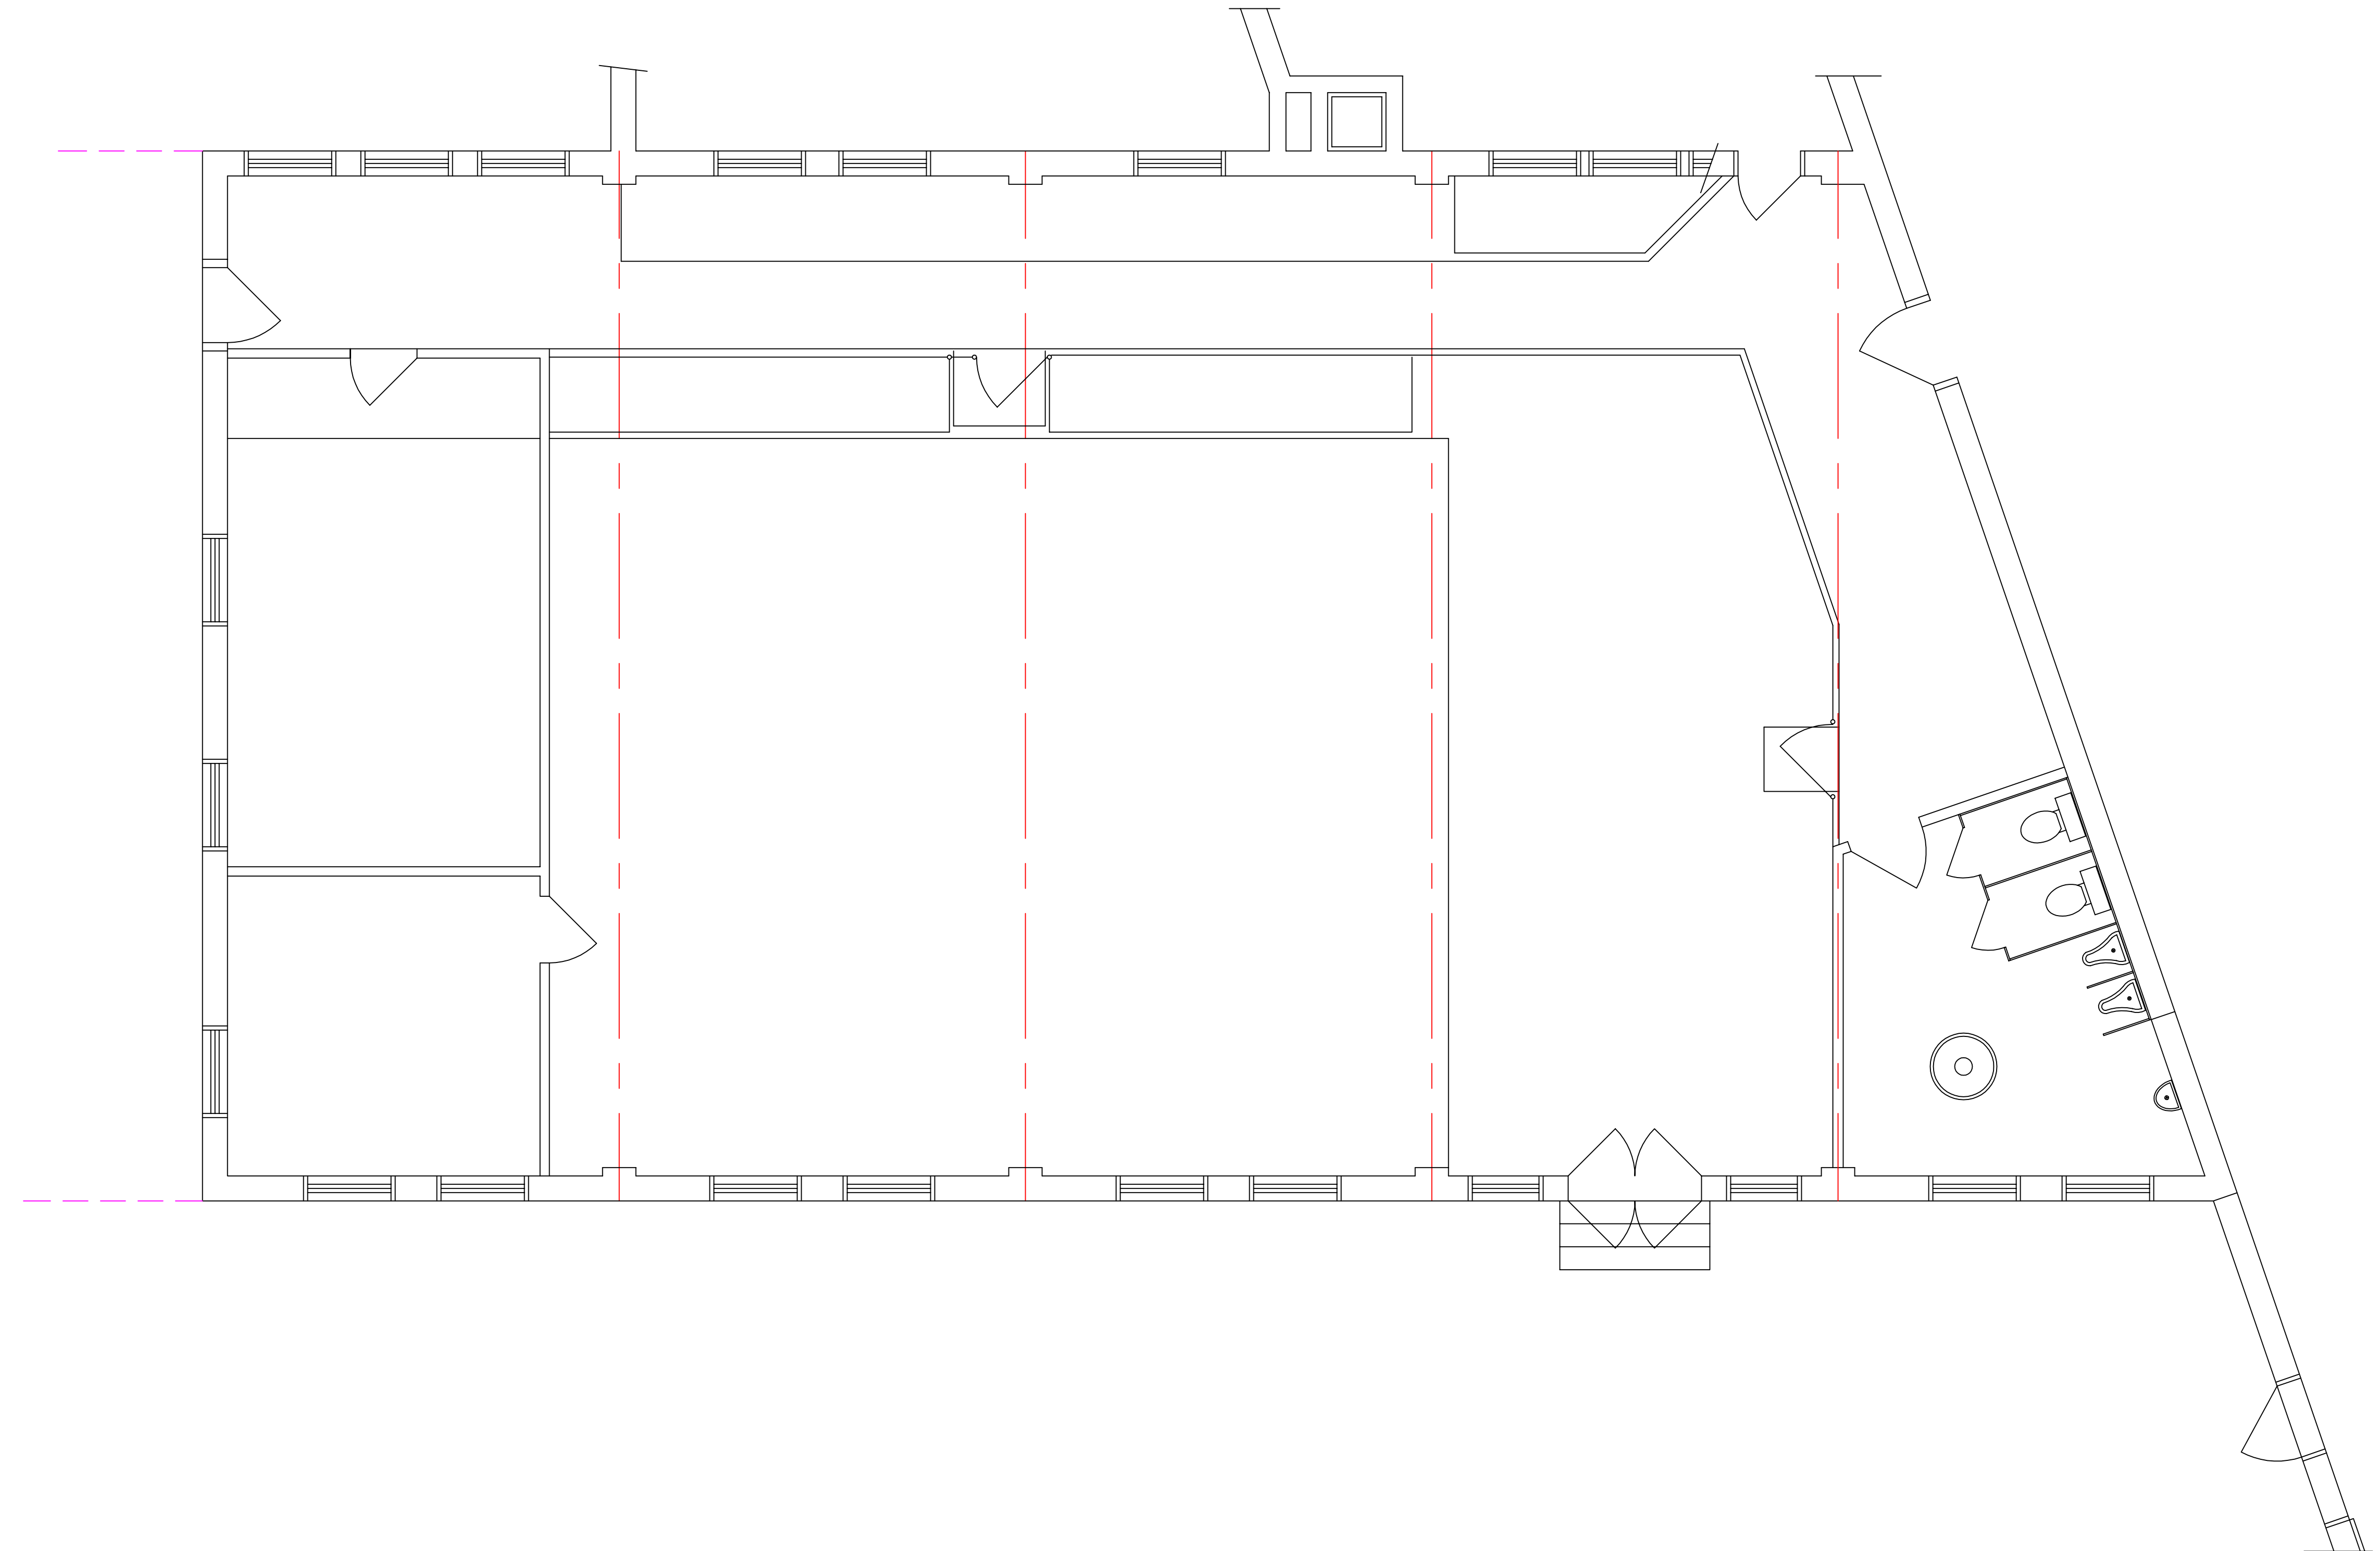

DRAWING FILE NAME:

BY: DJB DATE: 6-5-02

SCALE: 1/4" = 1'-0"

A1