


GENERAL NOTES:

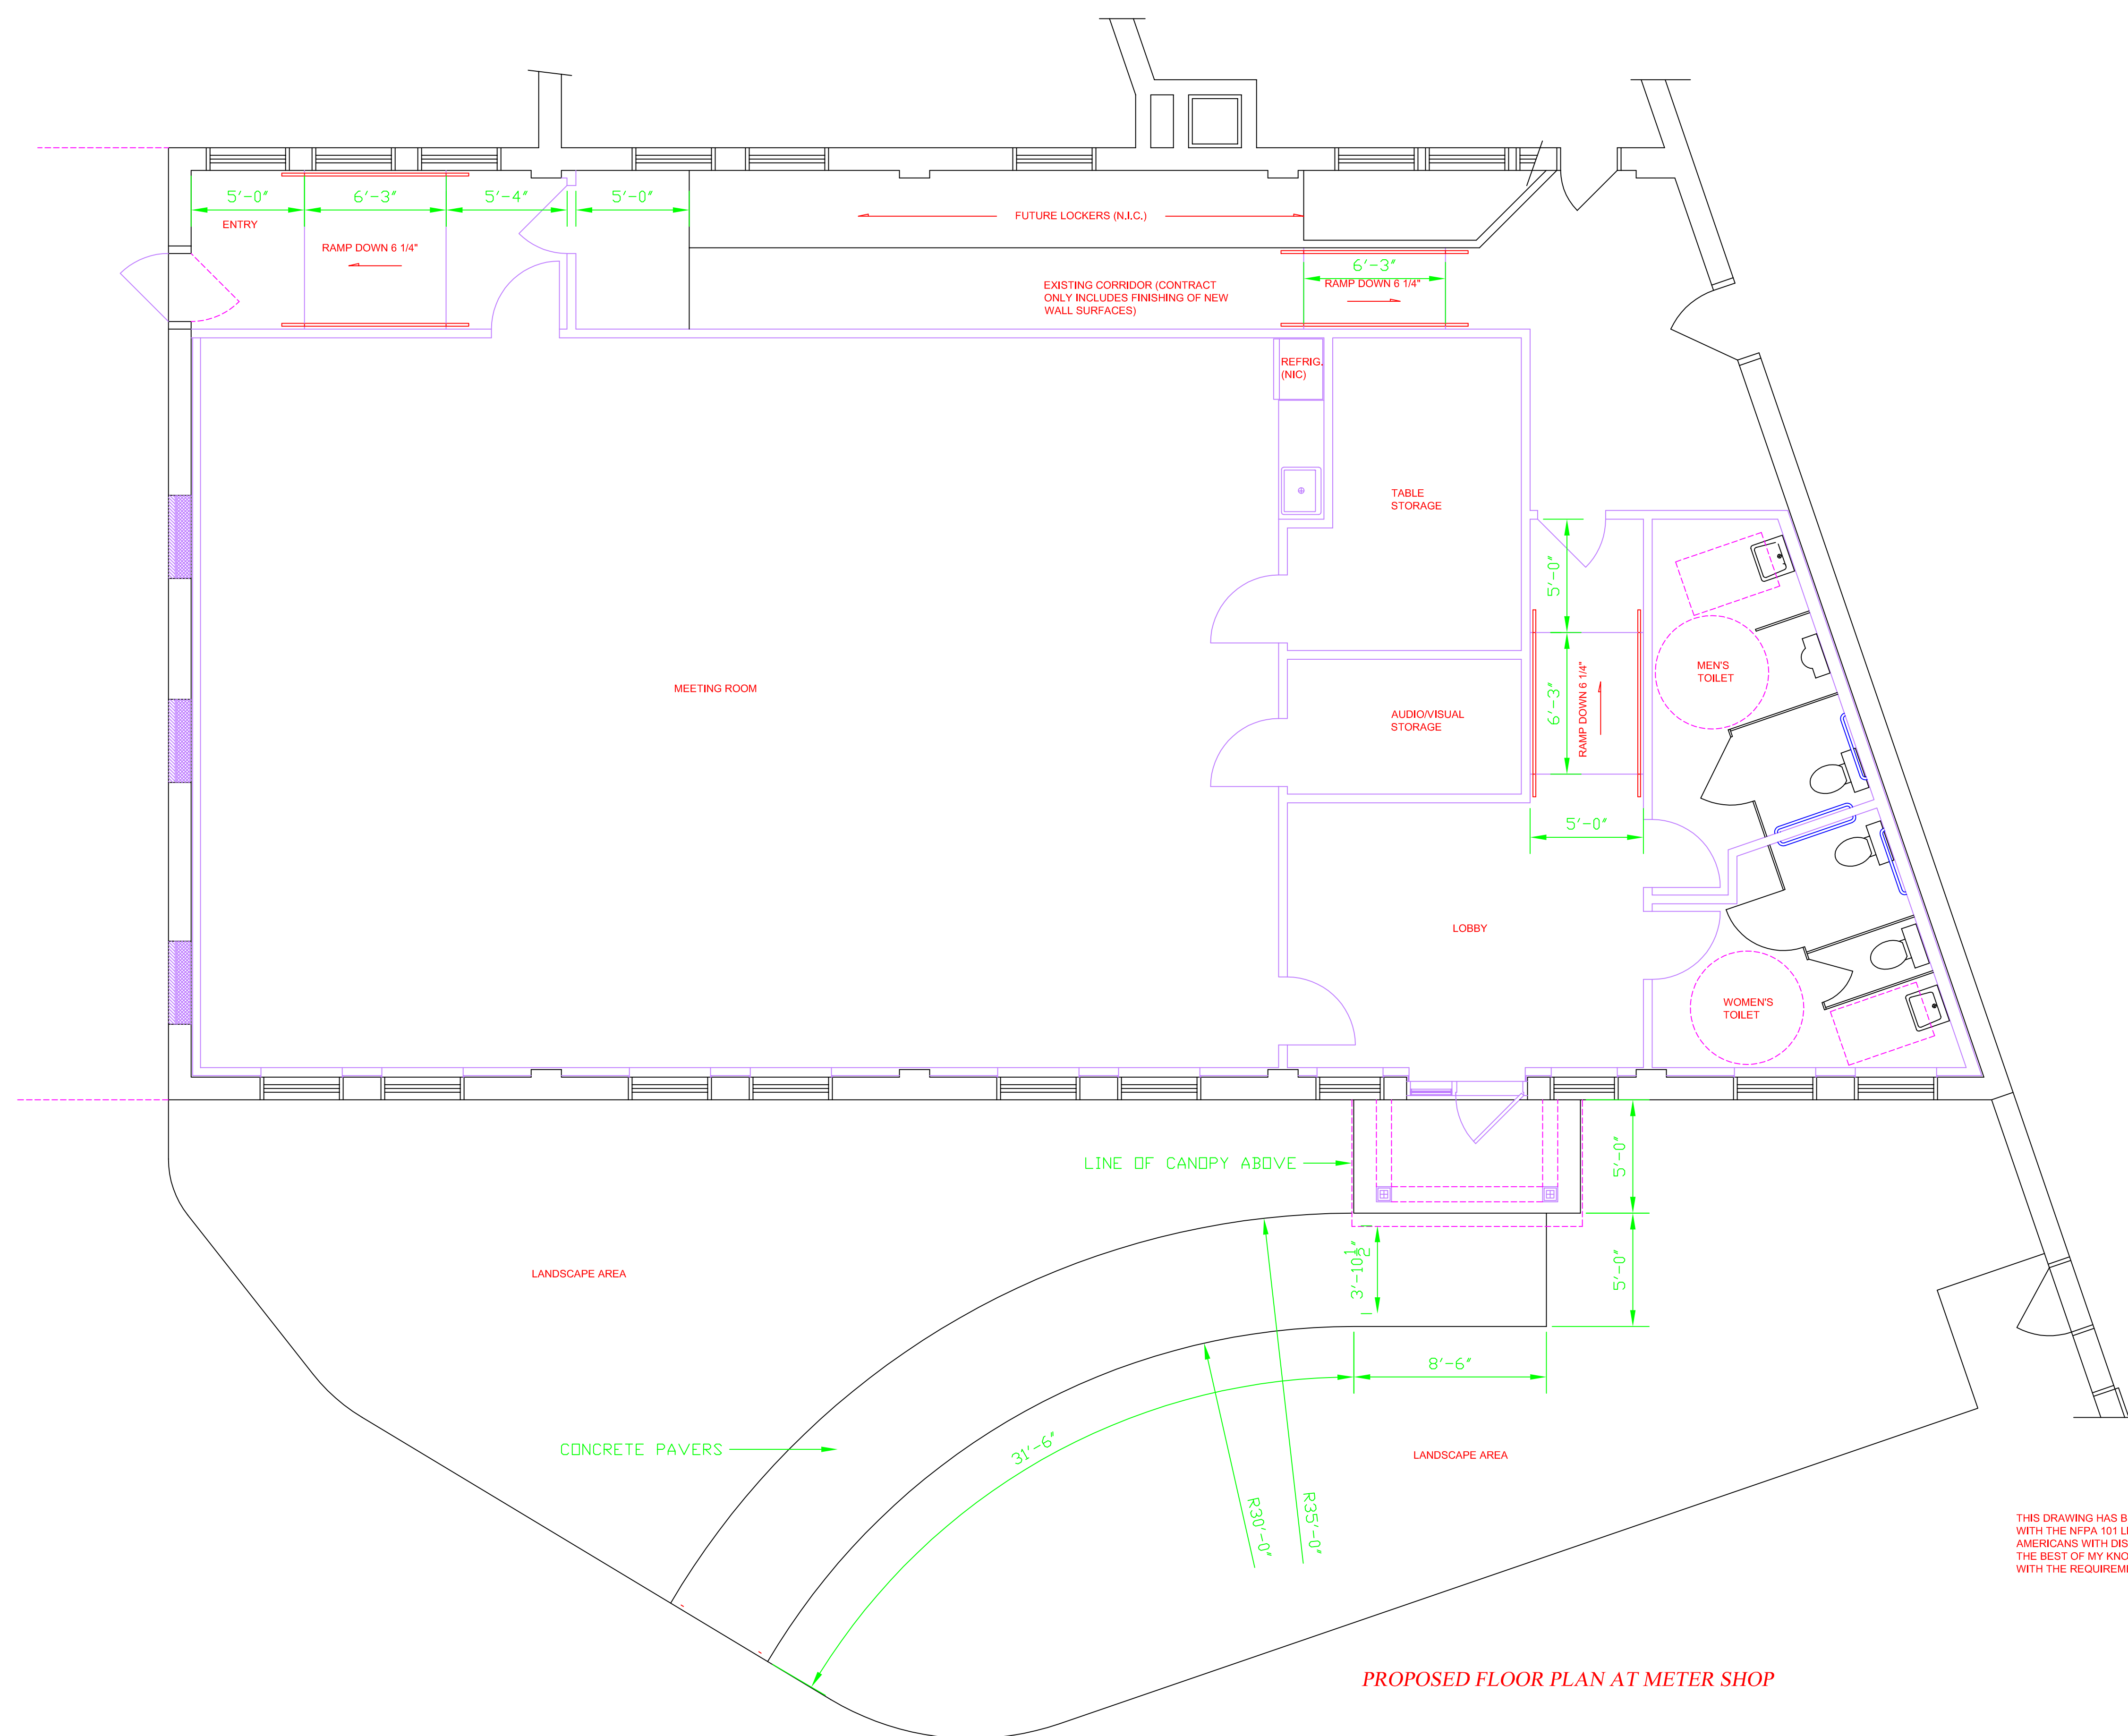


PROPOSED FLOOR PLAN AT METER SHOP

THIS DRAWING HAS BEEN REVIEWED FOR COMPLIANCE WITH THE NFPA 101 LIFE SAFETY CODE 2000 AND THE AMERICANS WITH DISABILITIES ACT OF 1991 AND, TO THE BEST OF MY KNOWLEDGE AND BELIEF, CONFORMS WITH THE REQUIREMENTS OF THESE ORDINANCES.

| NO. | REVISION/ISSUE | DATE |
|-----|----------------|------|
| | | |

CONVERSION OF EXISTING METER DEPARTMENT SHOP TO TRAINING AND MEETING FACILITY FOR PORTLAND WATER DISTRICT 225 DOUGLAS ST. PORTLAND, MAINE

ZACHAU CONSTRUCTION, INC.
1185 U.S. ROUTE ONE P.O. BOX J
FREEPORT, MAINE 04032-0916
TEL: (207) 865-9925 FAX: (207) 865-9926

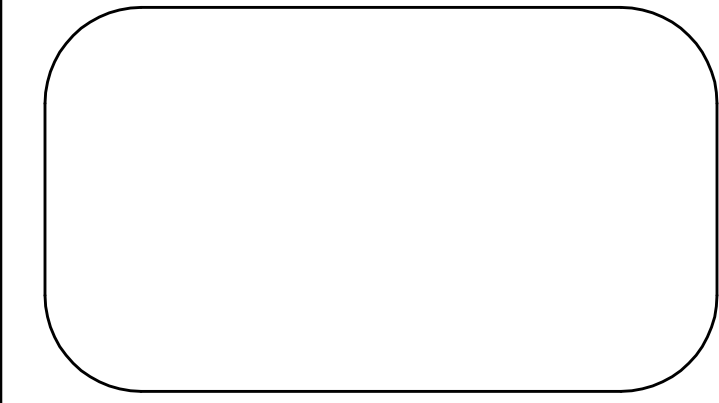

| | | |
|---------------------|---------------|----|
| DRAWING FILE NAME: | | A2 |
| BY: DJB | DATE: 8-15-02 | |
| SCALE: 1/4" = 1'-0" | | |