
 
 


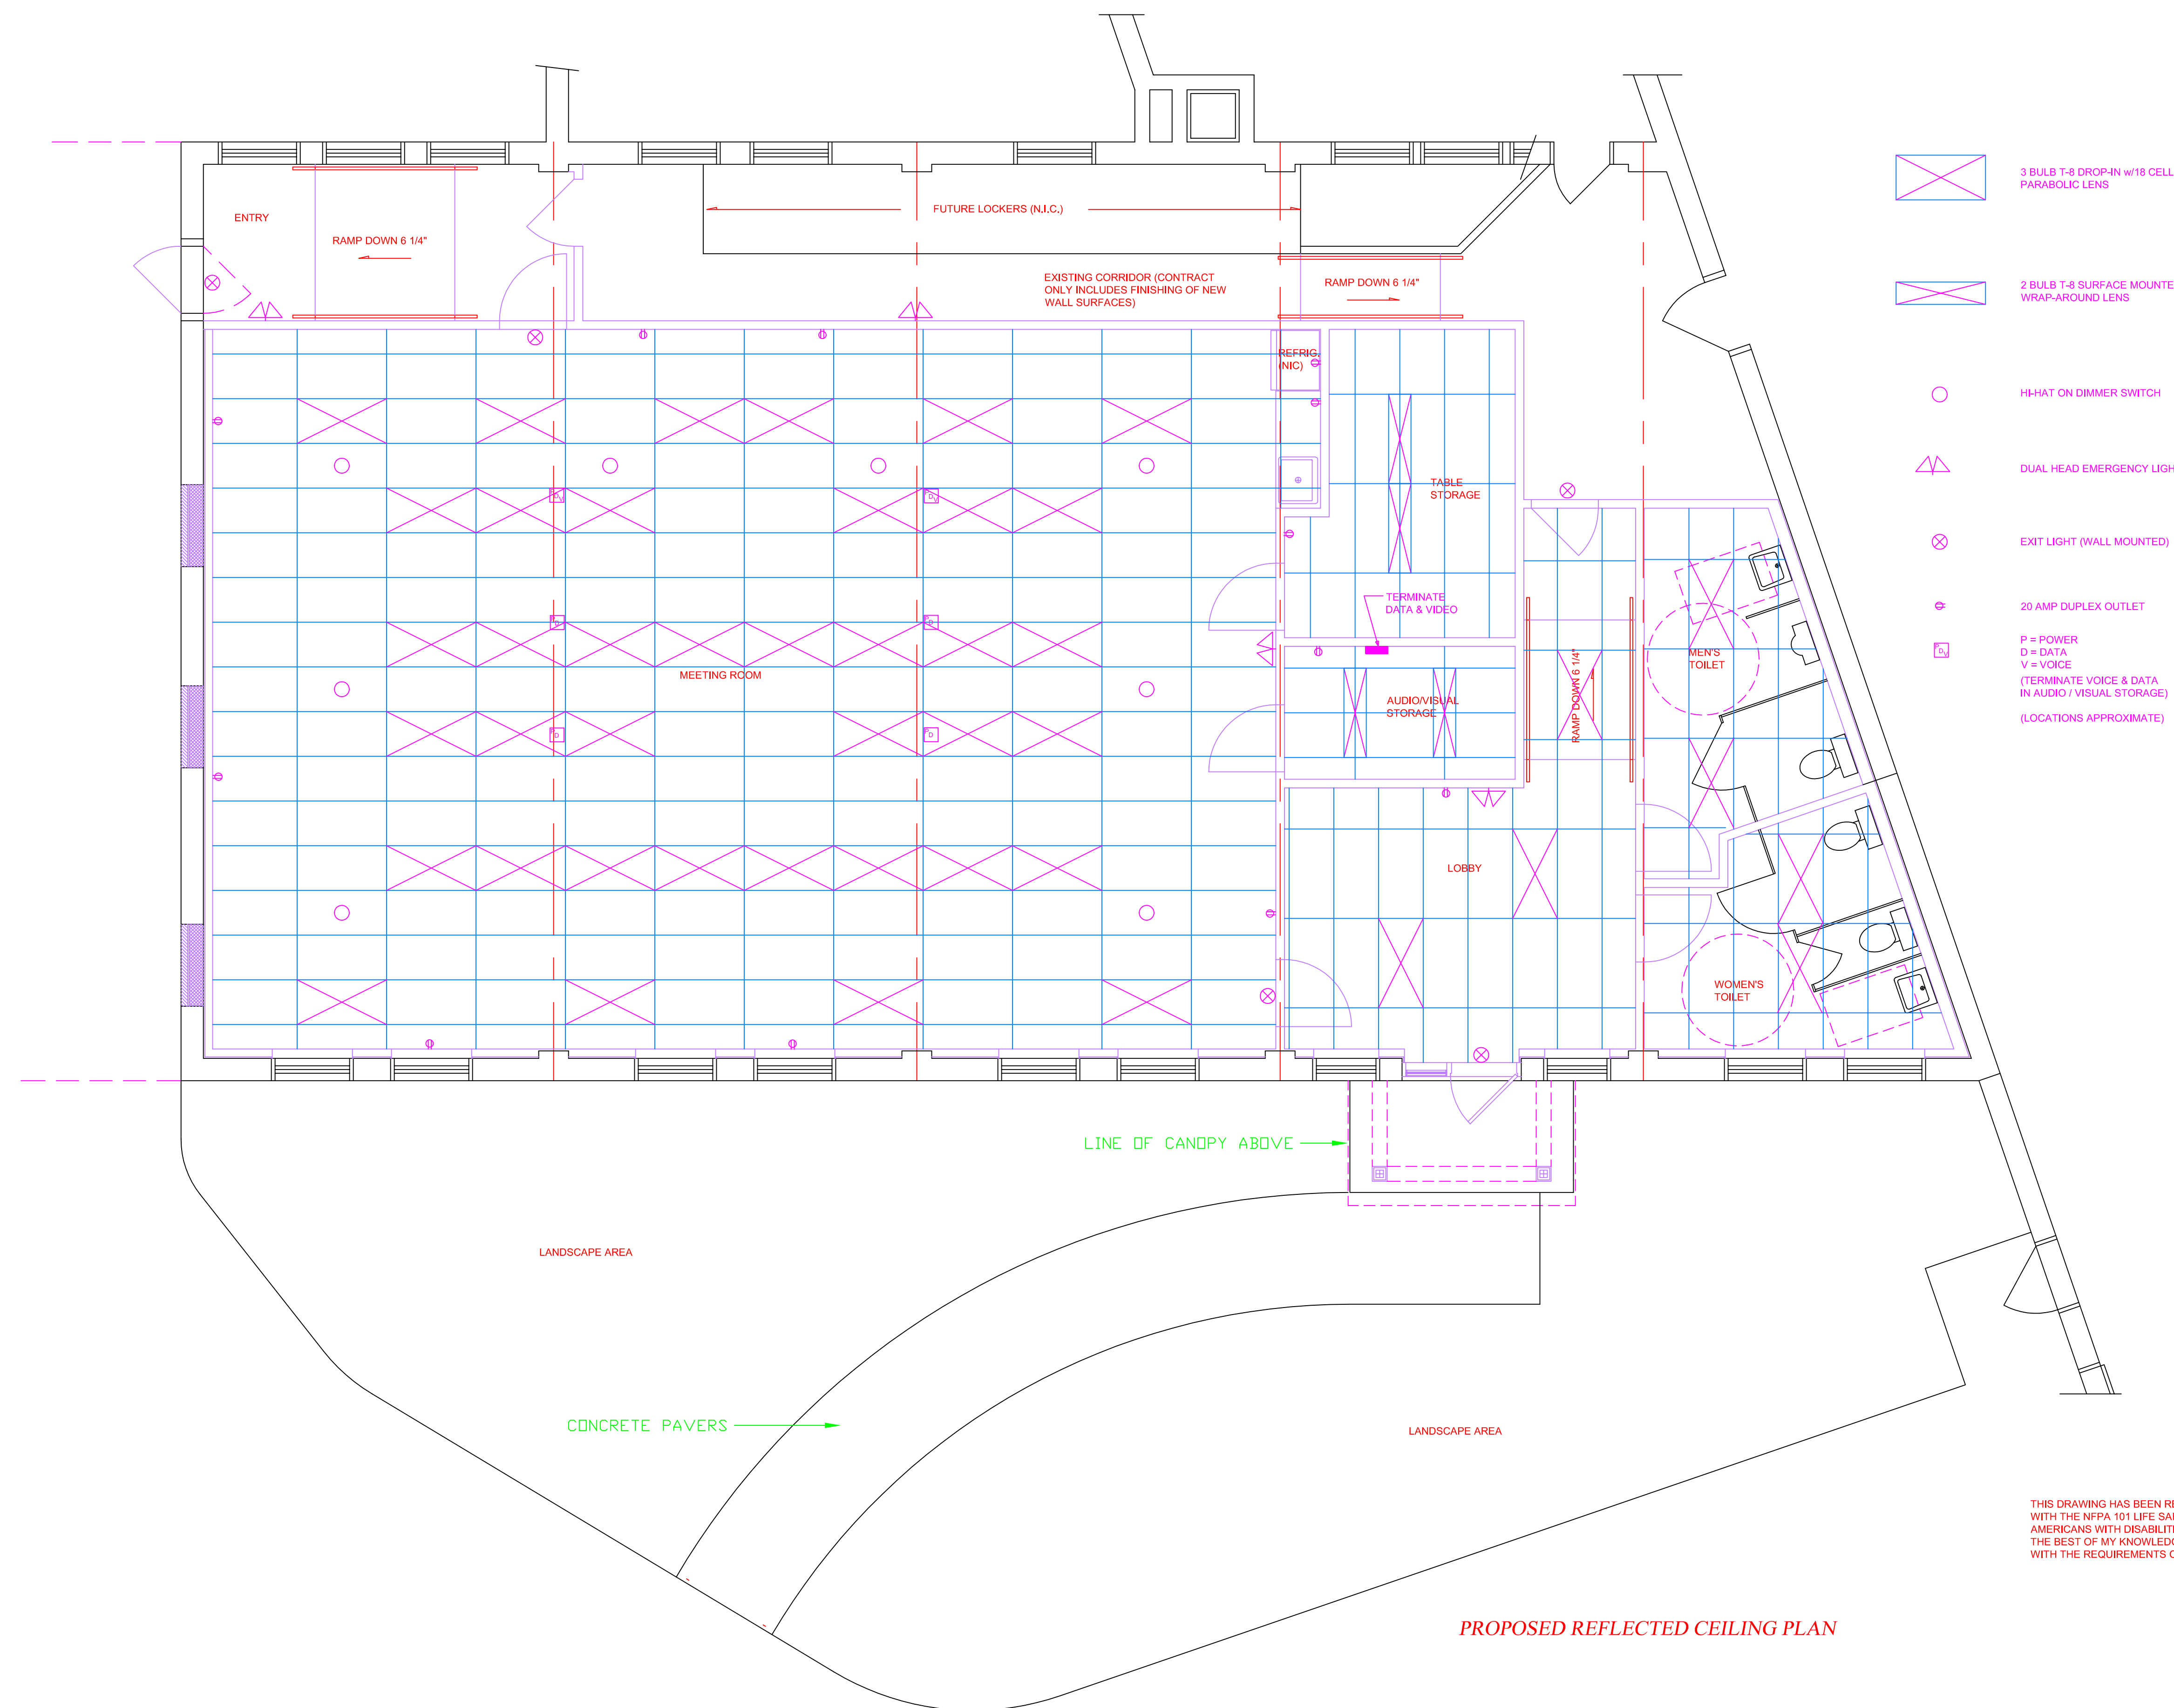




GENERAL NOTES:



-  3 BULB T-8 DROP-IN w/18 CELL PARABOLIC LENS
-  2 BULB T-8 SURFACE MOUNTED W/ WRAP-AROUND LENS
-  H-HAT ON DIMMER SWITCH
-  DUAL HEAD EMERGENCY LIGHT
-  EXIT LIGHT (WALL MOUNTED)
-  20 AMP DUPLEX OUTLET
-  P = POWER
D = DATA
V = VOICE
(TERMINATE VOICE & DATA IN AUDIO / VISUAL STORAGE)
(LOCATIONS APPROXIMATE)

NO.	REVISION/ISSUE	DATE

CONVERSION OF EXISTING
METER DEPARTMENT SHOP TO
TRAINING AND MEETING FACILITY
FOR
PORTLAND WATER DISTRICT
225 DOUGLAS ST. PORTLAND, MAINE

ZACHAU CONSTRUCTION, INC.
1185 U.S. ROUTE ONE P.O. BOX J
FREEPORT, MAINE 04032-0916
TEL: (207) 865-9925 FAX: (207) 865-9926

THIS DRAWING HAS BEEN REVIEWED FOR COMPLIANCE WITH THE NFPA 101 LIFE SAFETY CODE 2000 AND THE AMERICANS WITH DISABILITIES ACT OF 1991 AND, TO THE BEST OF MY KNOWLEDGE AND BELIEF, CONFORMS WITH THE REQUIREMENTS OF THESE ORDINANCES.

PROPOSED REFLECTED CEILING PLAN

DRAWING FILE NAME:
BY: **DJB** DATE: **7-16-02**
SCALE: **1/4" = 1'-0"**

A5