

DESIGNER

CWS ARCHITECTS
ARCHITECTURE | INTERIOR DESIGN
434 CUMBERLAND AVENUE
PORTLAND, MAINE 04101
T: 207.774.4441
F: 207.774.4016
WWW.CWSARCH.COM

OWNER

COMMUNITY HOUSING
OF MAINE INC.
ONE CITY CENTER, 4TH FLOOR
PORTLAND, MAINE 04101

PROJECT

548 SAINT JOHN STREET
APARTMENT

DRAWING


FIRST FLOOR REFLECTED
CEILING PLAN

REVISIONS

NO.	DESCRIPTION

DRAWING NUMBER
A2.10

SCALE: AS NOTED
DATE: 1/13/2017

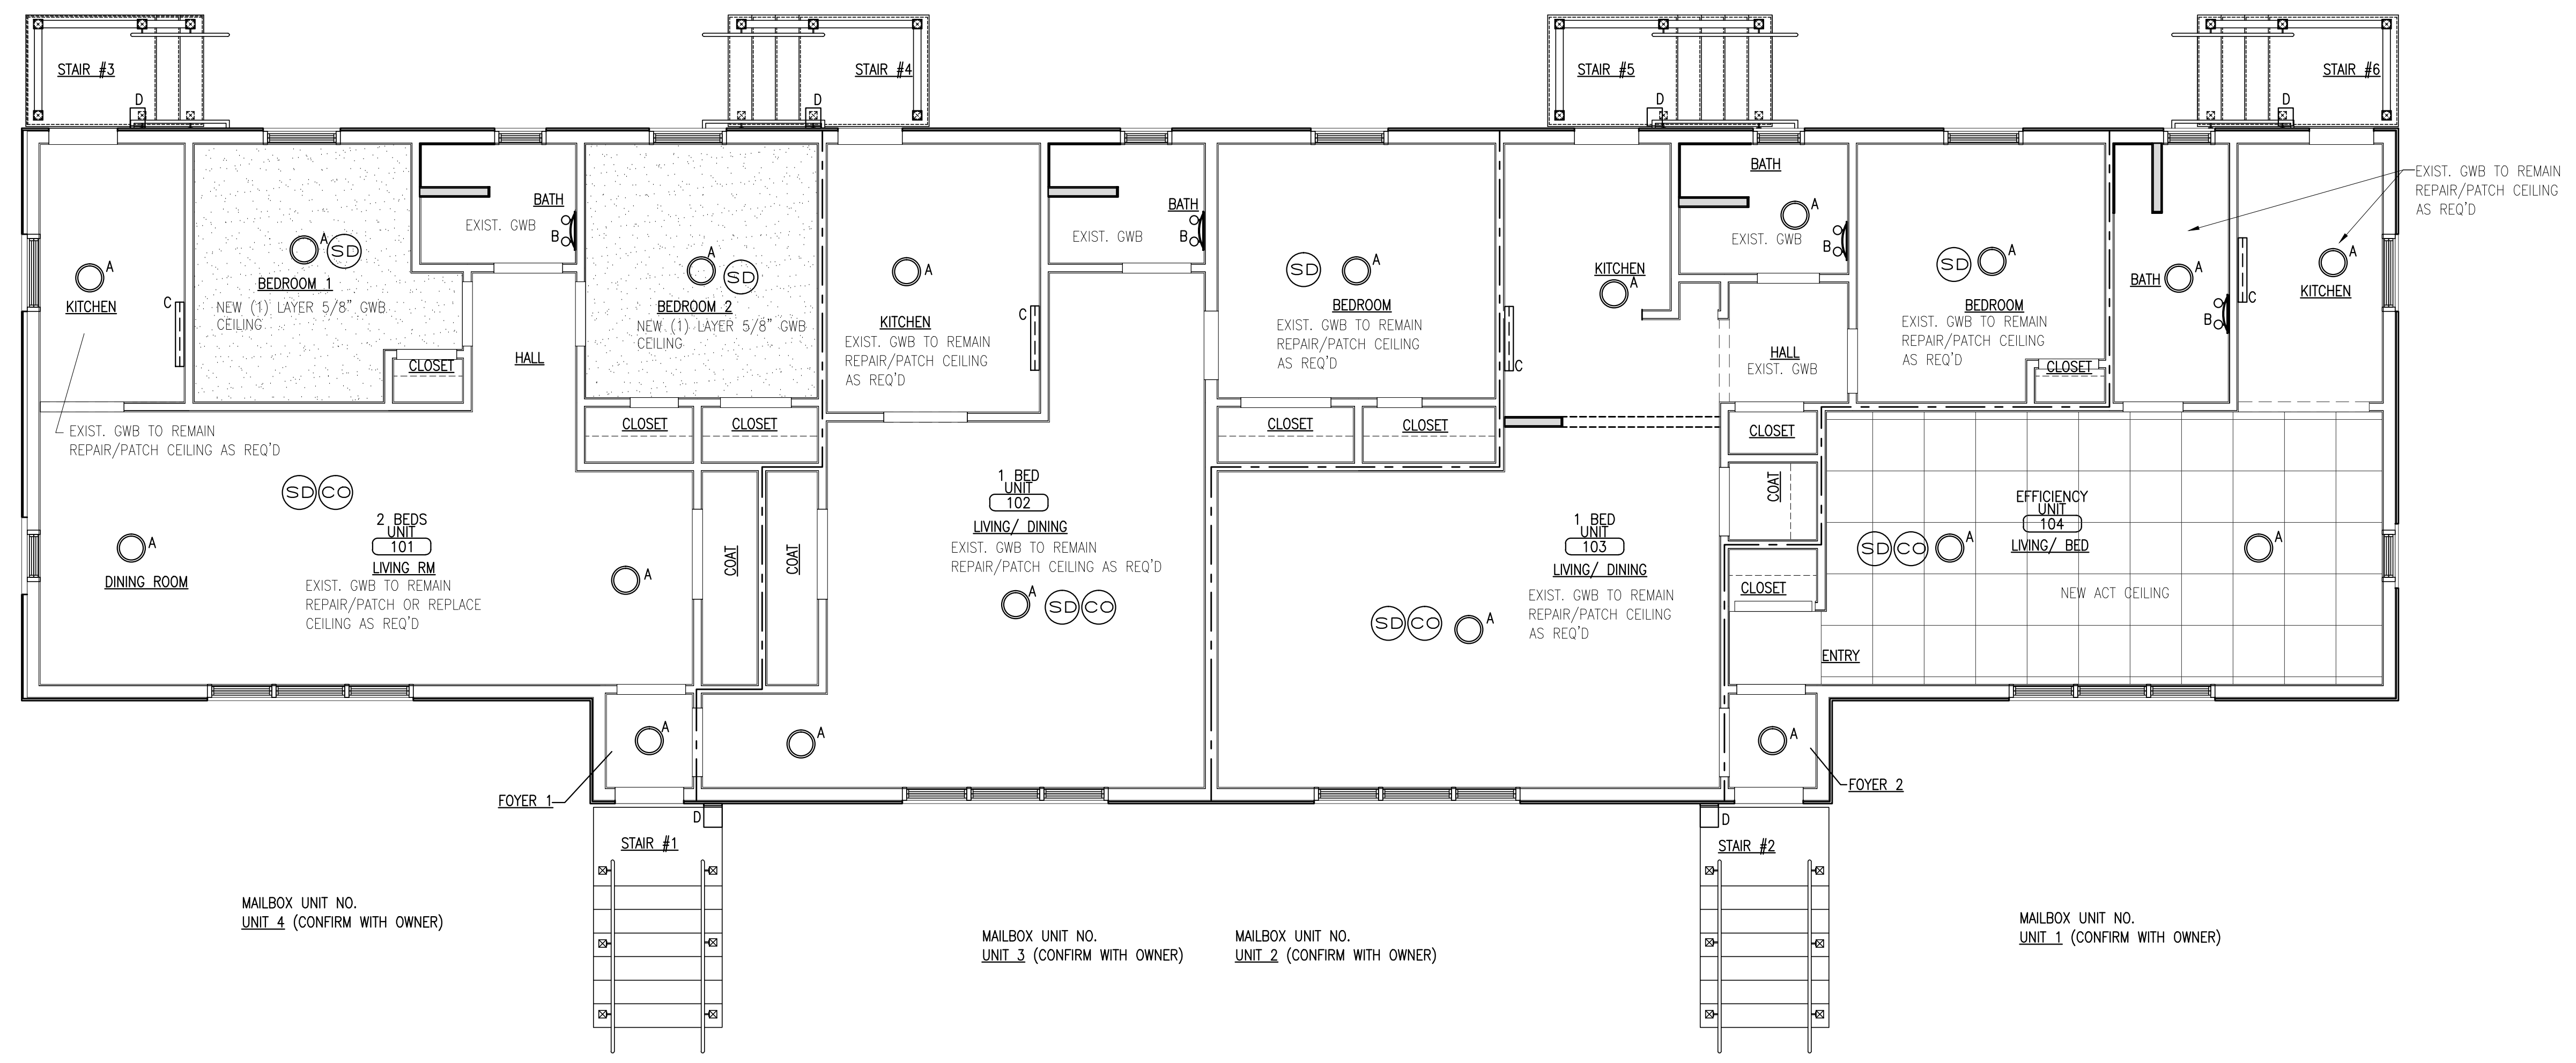

A3 FIRST FLOOR REFLECTED CEILING PLAN
REFERENCED FROM: SCALE: 1/4" = 1'-0"

- LIGHTING LEGEND**
-

- NOTES:**
- INTERIOR FIXTURE LEGEND FOR DESIGN INTENT ONLY. COORDINATE WITH ELECTRICAL DRAWINGS FOR LIGHT FIXTURE TYPES AND CIRCUITING. ANY LIGHT FIXTURE DISCREPANCY SHALL BE BROUGHT TO THE ATTENTION OF AND COORDINATED WITH ARCHITECT AND ELECTRICAL ENGINEER PRIOR TO LIGHT FIXTURE INSTALLATION.
 - NOT USED
 - PROVIDE NEW LIGHT FIXTURES AT EXISTING LIGHT FIXTURES LOCATION.
 - ACT = ACOUSTICAL CEILING TILE
 - REFERENCE REFLECTED CEILING PLAN DRAWING A2.10 FOR LIGHTING LAYOUT. COORDINATE WITH ELECTRICAL DRAWINGS. ANY DISCREPANCY SHALL BE BROUGHT TO THE ATTENTION OF AND COORDINATED WITH ARCHITECT AND ELECTRICAL ENGINEER PRIOR TO LIGHT FIXTURE INSTALLATION.
 - CONTINUOUS FINISHED GWB CEILING SHALL BE FINISHED AT THE UNDERSIDE OF FRAMING. LIGHT FIXTURES SHALL BE SURFACE MOUNTED, UNLESS NOTED OTHERWISE.

LIGHTING FIXTURE SCHEDULE

TYPE	DESCRIPTION	LAMPS QUANTITY & TYPE	REMARKS
A	PROJECT SOURCE 13-IN W/ NICKEL LED FLUSH MOUNT LIGHT. MODEL: MXL304-LED18K830N	(1) 18 WATT INTEGRATED LED	CEILING FLUSH MOUNT
B	WESTMORE LIGHTING ASHLAND 2-LIGHT BRUSHED NICKEL BELL LED VANITY LIGHT MODEL: BB202120LED	(2) LED BULB	BATHROOM OVER SINK
C	SYLVANIA LIGHTIFY 24-IN UNDER CABINET LED LIGHT BAR MODEL: 71722	10 WATTS 600 LUMENS LED	UNDER CABINET
D	FALLBROOK 9" HIGH - DUSK TO DAWN MOTION SENSOR WALL MOUNT OUTDOOR LIGHT - BLACK COLOR MODEL: 5Y111	60 WATTS	EXTERIOR WALL MOUNT

A5 - REFERENCED FROM: SCALE: 1/4" = 1'-0"

F5 - REFERENCED FROM: SCALE: N.T.S.