



1 GARAGE FLOOR PLAN
A10.1 1/4" = 1'-0"

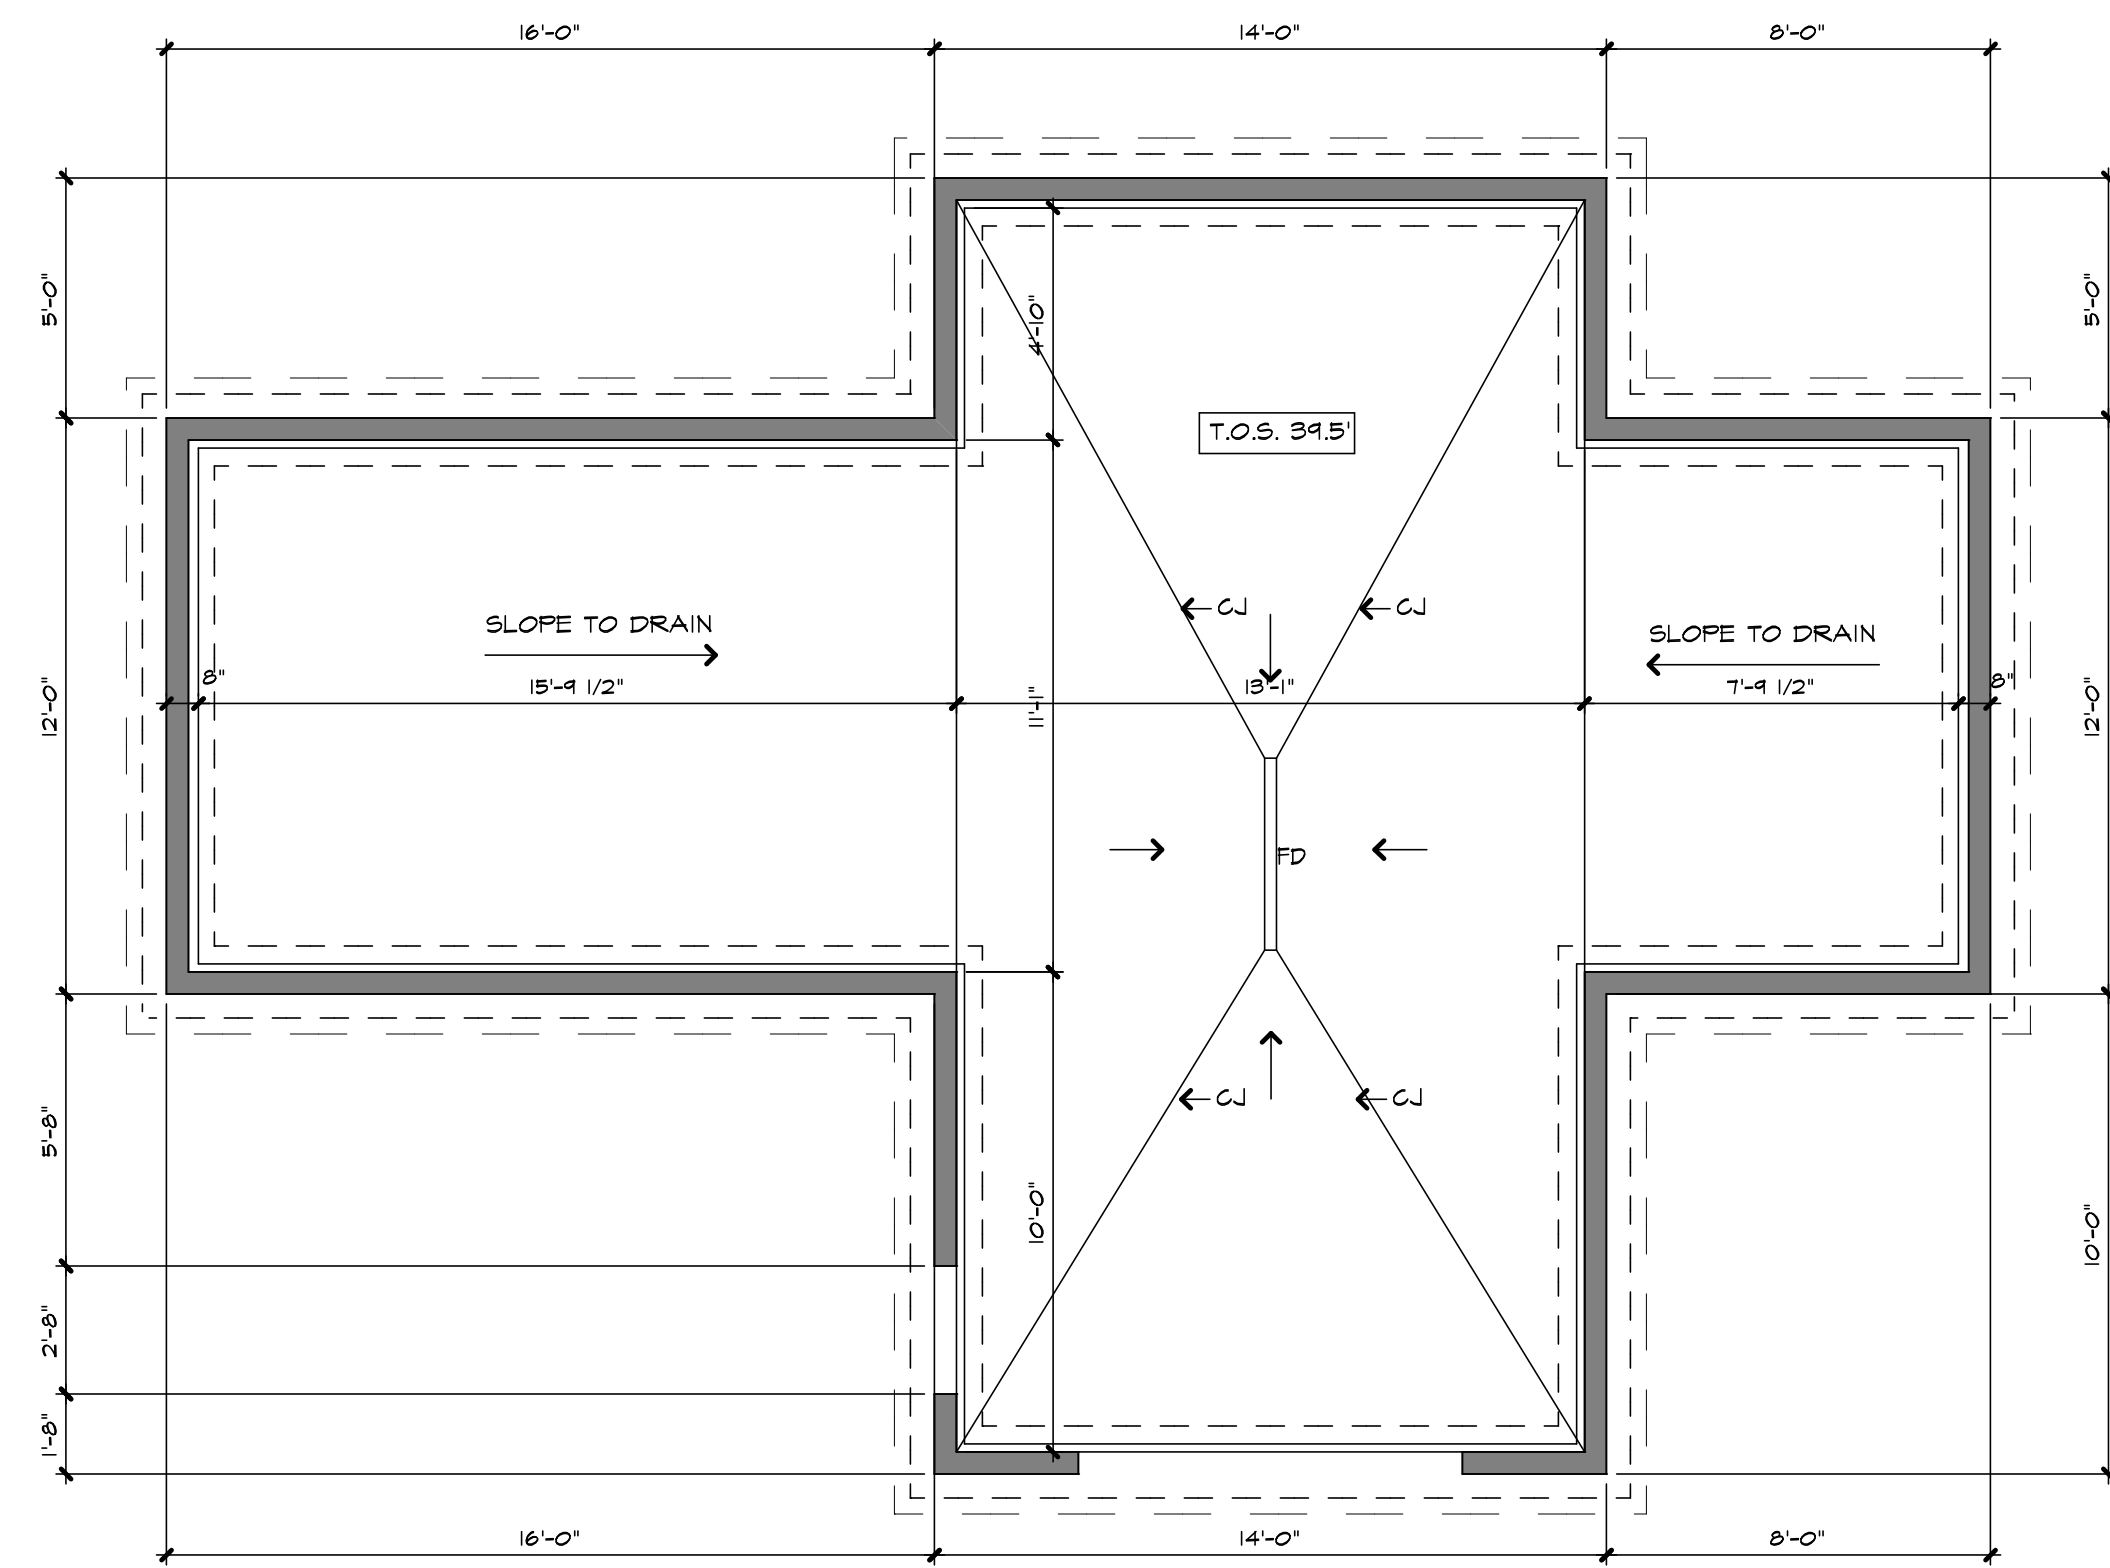


2 GARAGE FOUNDATION PLAN
A10.1 1/4" = 1'-0"

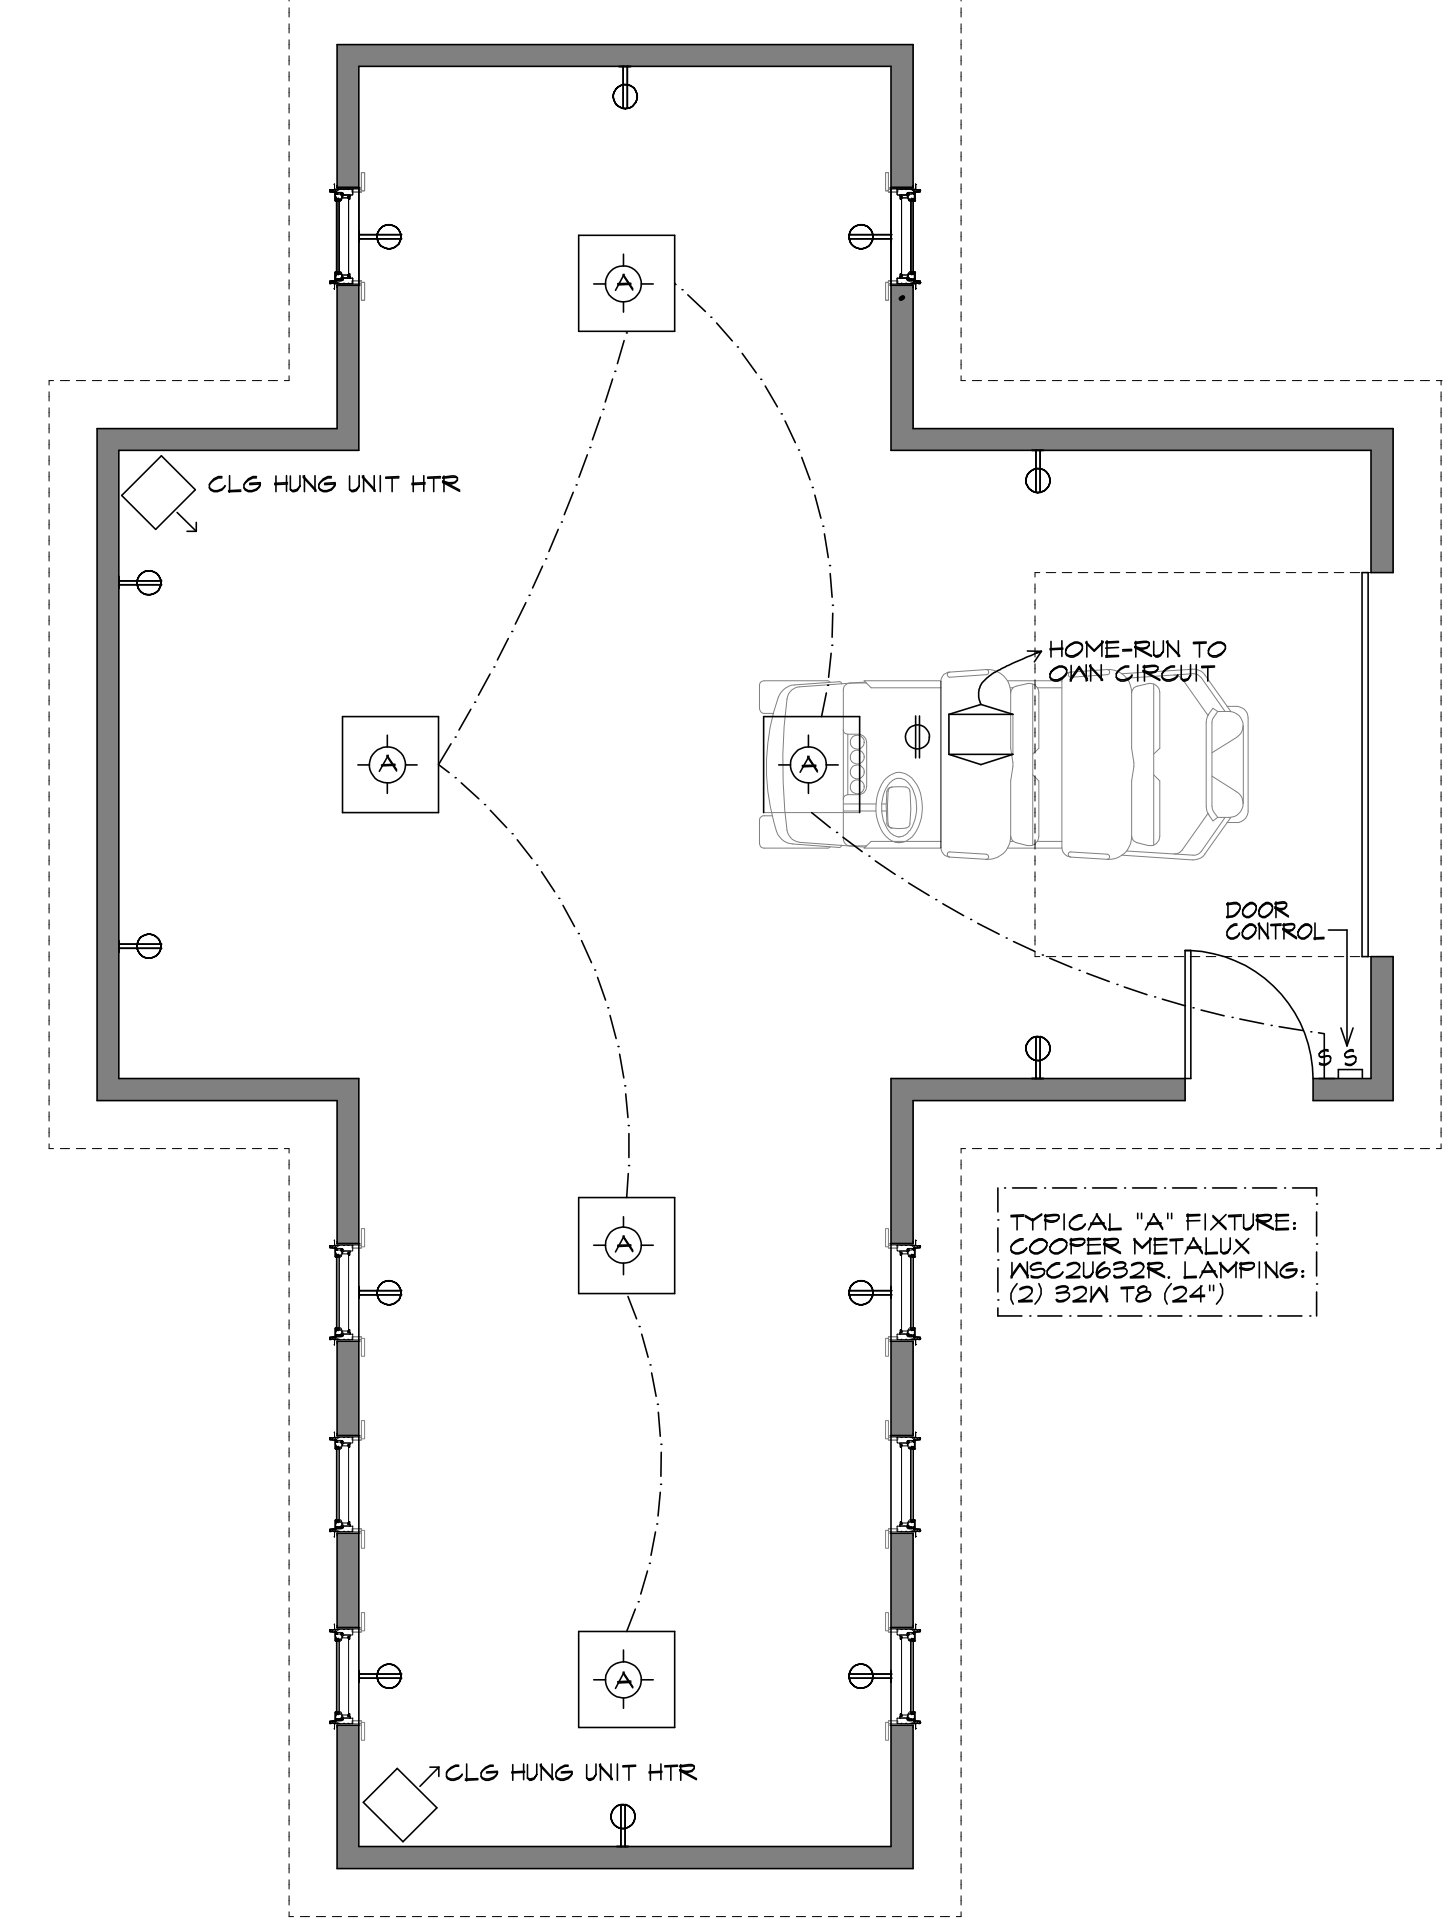

3 GARAGE ELECTRICAL PLAN
A10.1 1/4" = 1'-0"



4 GARAGE: NORTH ELEVATION
A10.1 1/4" = 1'-0"

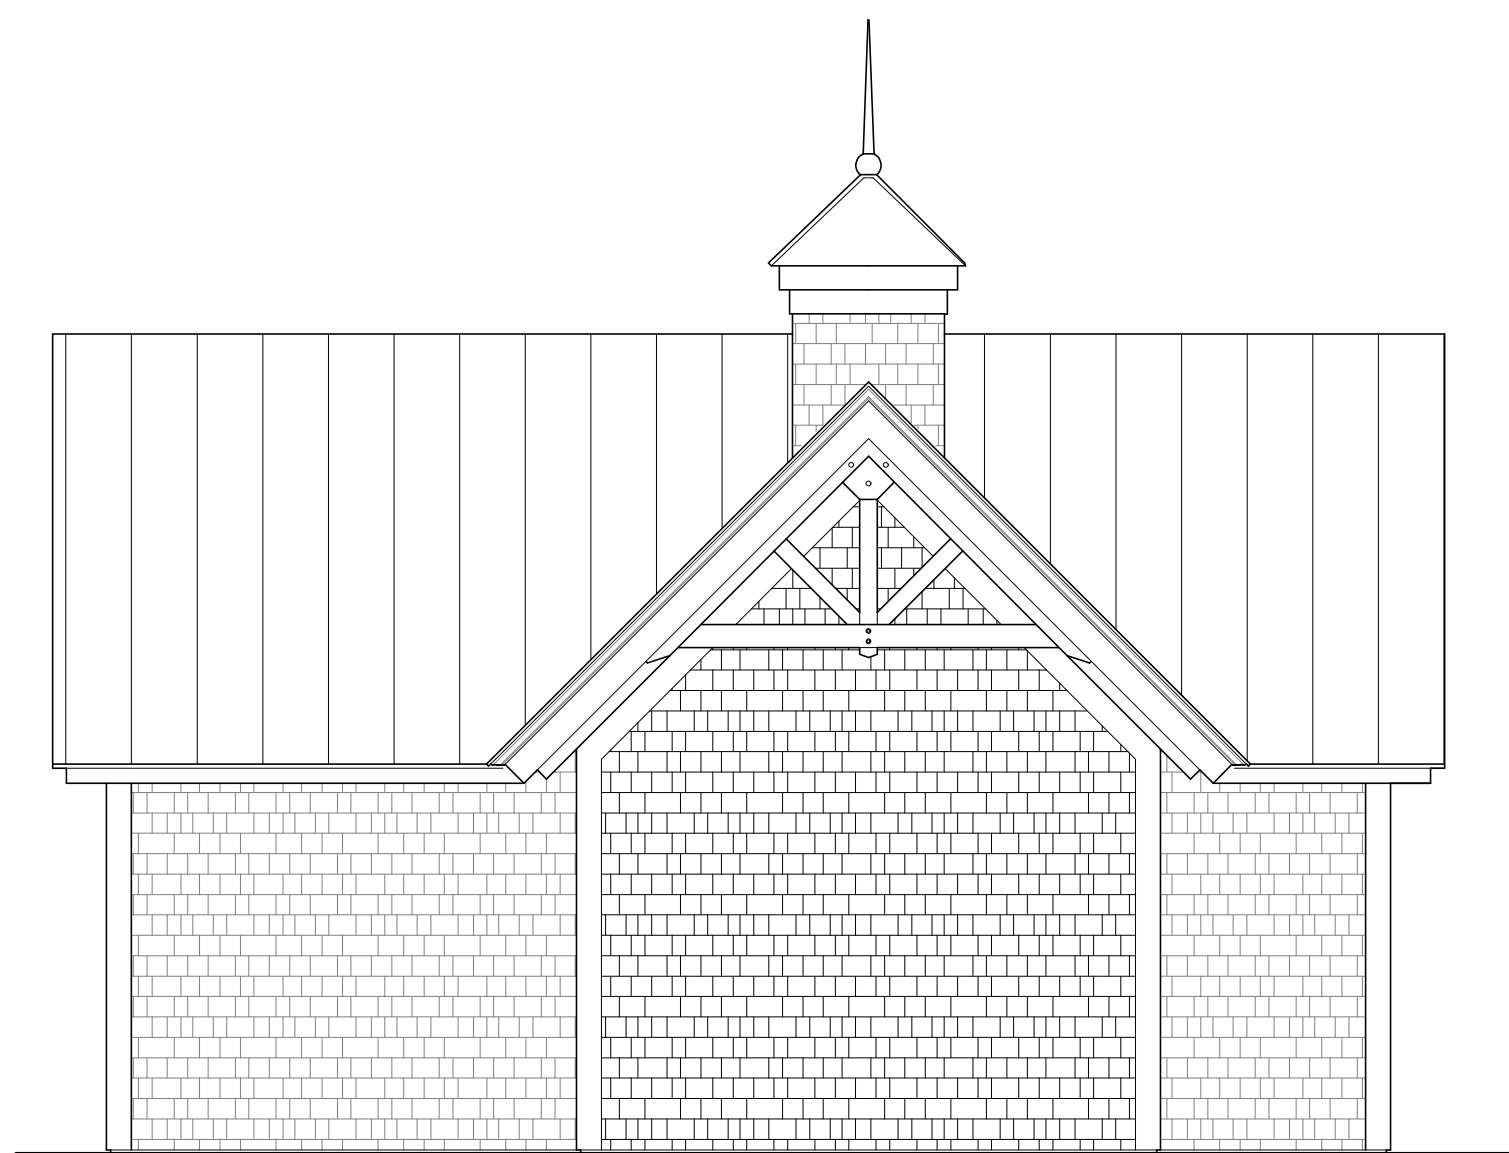


5 GARAGE: WEST ELEVATION
A10.1 1/4" = 1'-0"



6 GARAGE: SOUTH ELEVATION
A10.1 1/4" = 1'-0"



7 GARAGE: EAST ELEVATION
A10.1 1/4" = 1'-0"

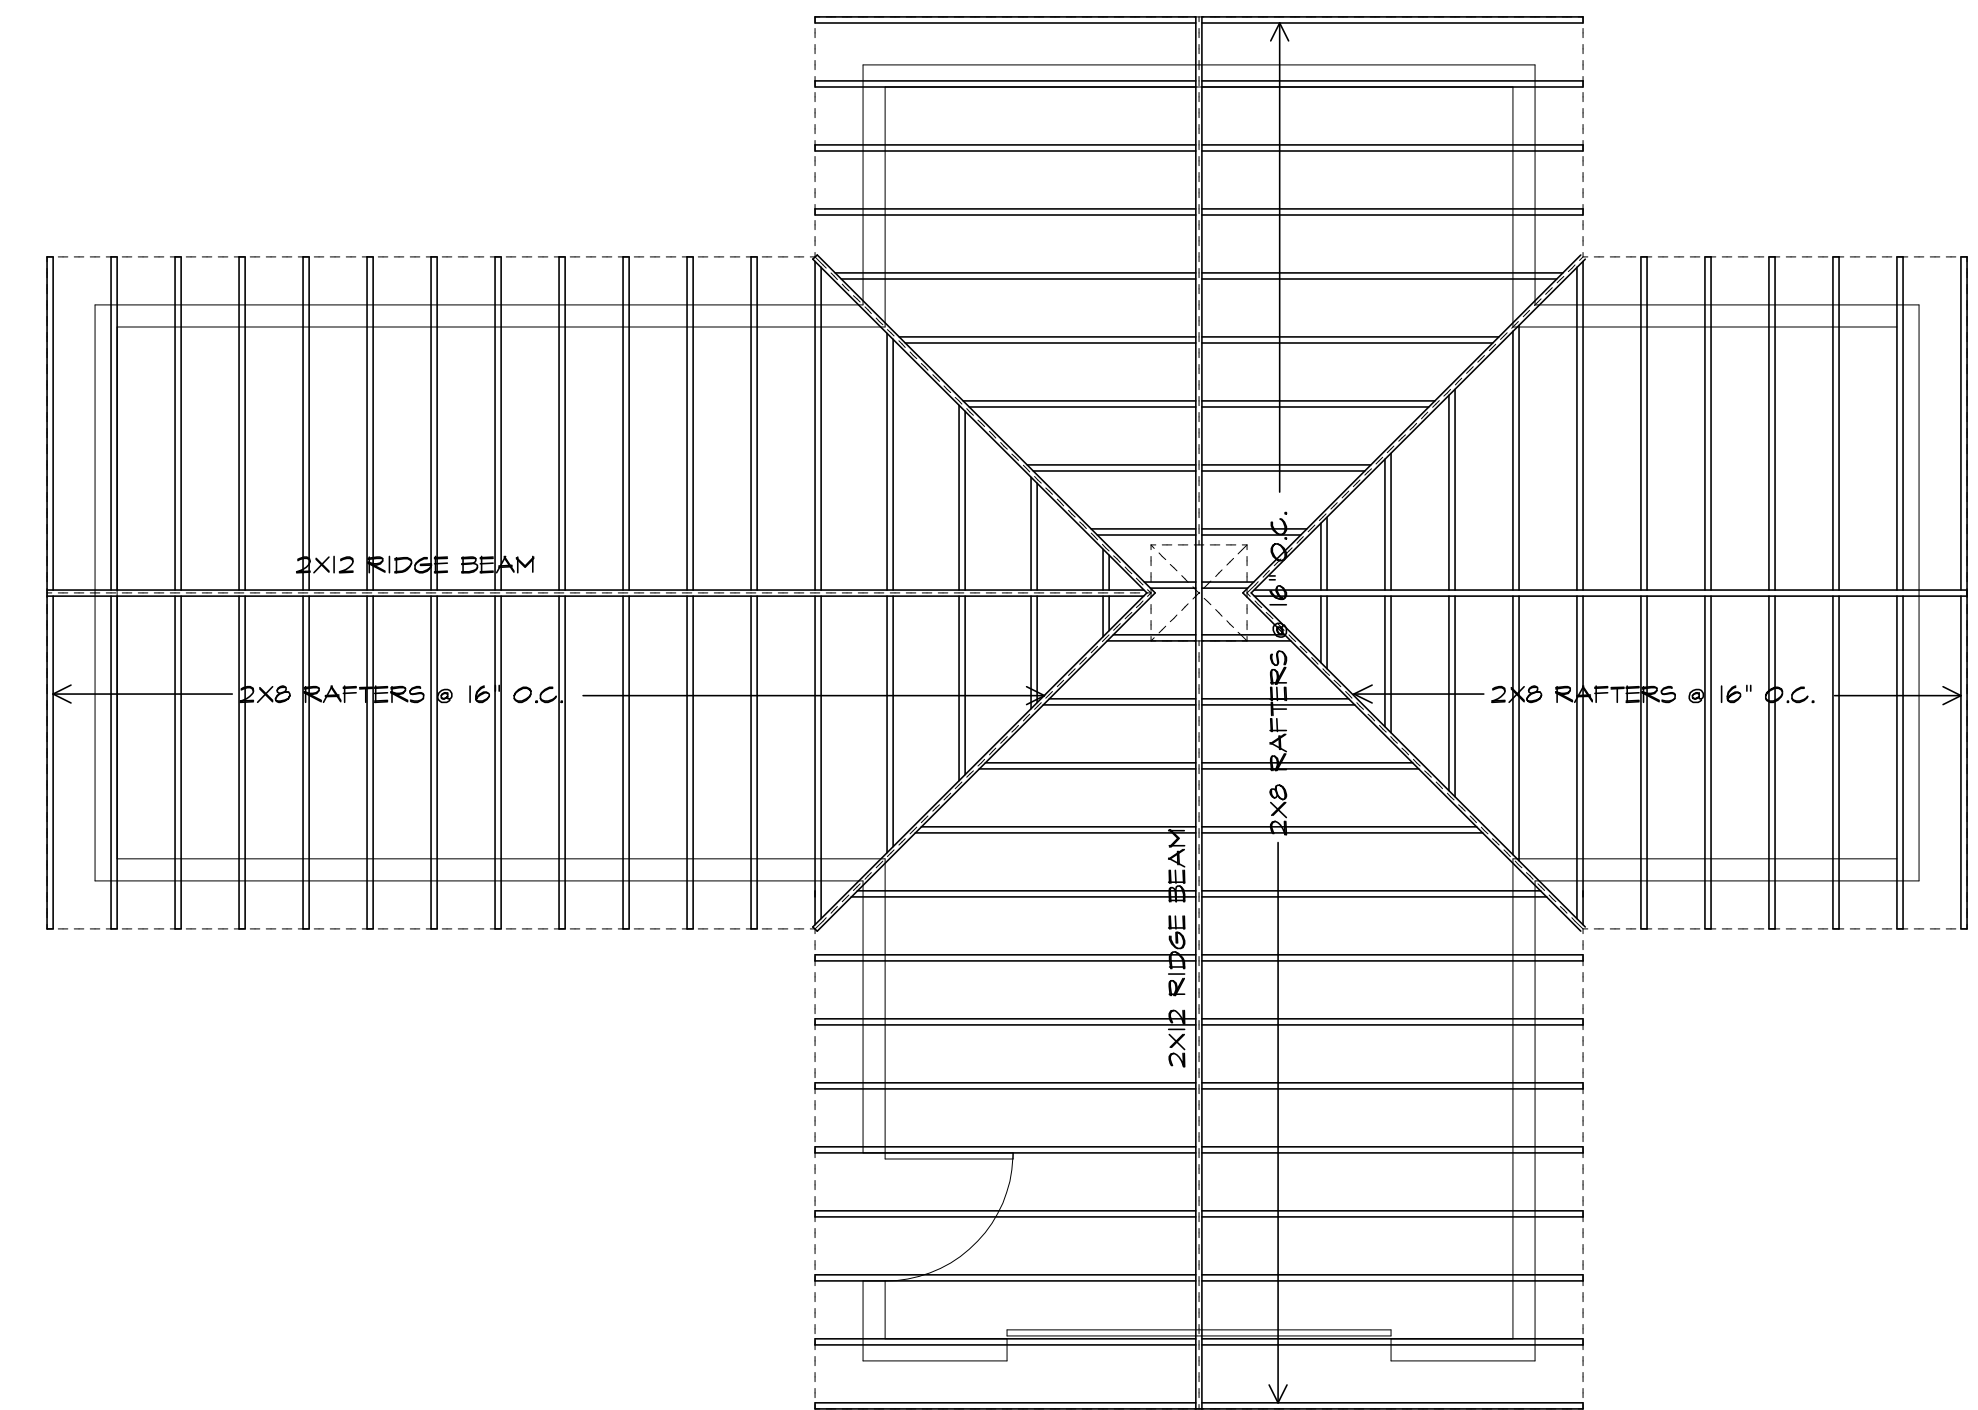

1 GARAGE FRAMING PLAN
A10.1 1/4" = 1'-0"

JOHN MORRIS
ARCHITECTS
49 MECHANIC ST. P.O. BOX 250 CAMDEN, ME 04843
207-236-6321 johnmorrisarchitects.com FAX 207-236-6391

SOSNIK GARAGE
PORTLAND MAINE
PLANS AND ELEVATIONS
SCALE: 1/4" = 1'-0"
PLOT SCALE: 1/4" = 1'-0"

REVISIONS	
8.20.19	ISSUE FOR

JOB NO. 1506	FILE NAME 1506-GARAGEPLAN
DRAWN BY JJA	DATE 17 MARCH 2016

© COPYRIGHT 2016
JOHN MORRIS ARCHITECTS

A10.1

ISSUE FOR PERMIT
PROGRESS PRINT
NOT FOR CONSTRUCTION

5-2716 1/21 PM