


① FIELD ROUTE 4" DIAMETER EXHAUST DUCT UP THRU ATTIC TO CUPOLA.

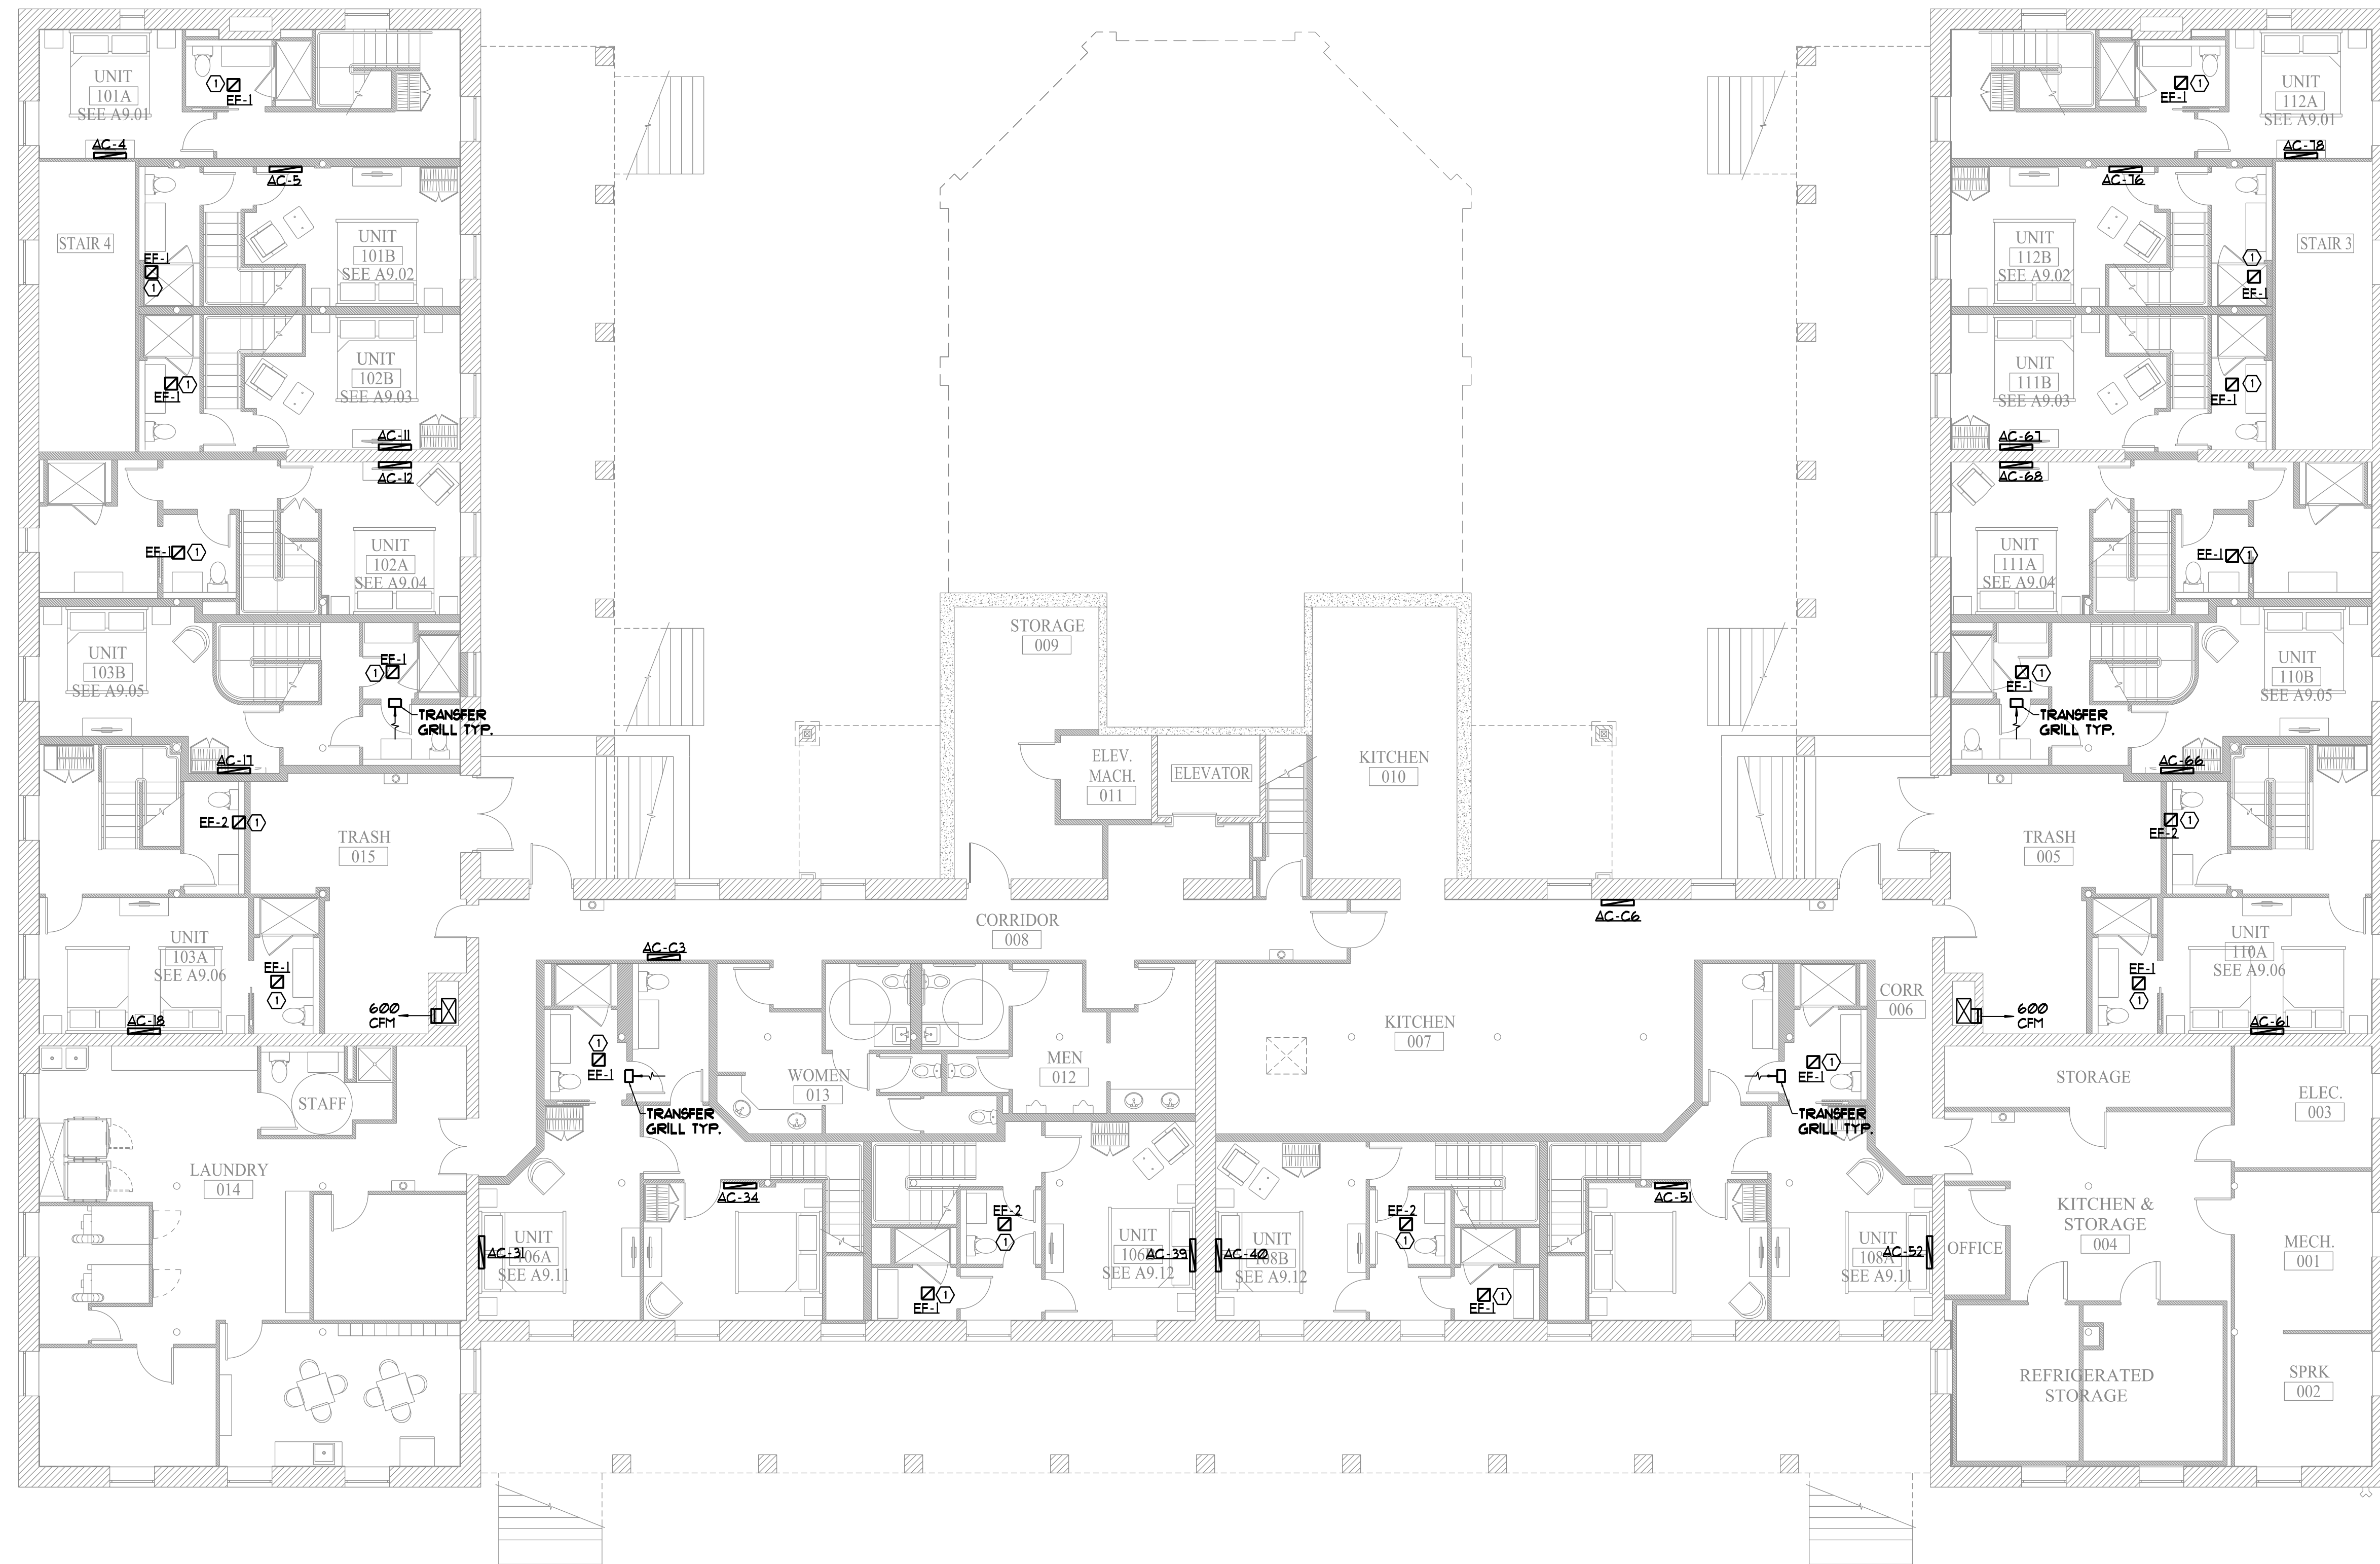

BASEMENT MECHANICAL PLAN
SCALE 1/8" = 1'-0"

DIAMOND ISLAND INN

BASEMENT MECHANICAL PLAN

Date Drawn - 9-10-13
Drawn By - SMR
Revised -

Project # 3394
Scale - 1/8" = 1'-0"
Sheet Number - M1.00