


① FIELD ROUTE 4" DIAMETER EXHAUST DUCT UP THRU ATTIC TO CUPOLA.

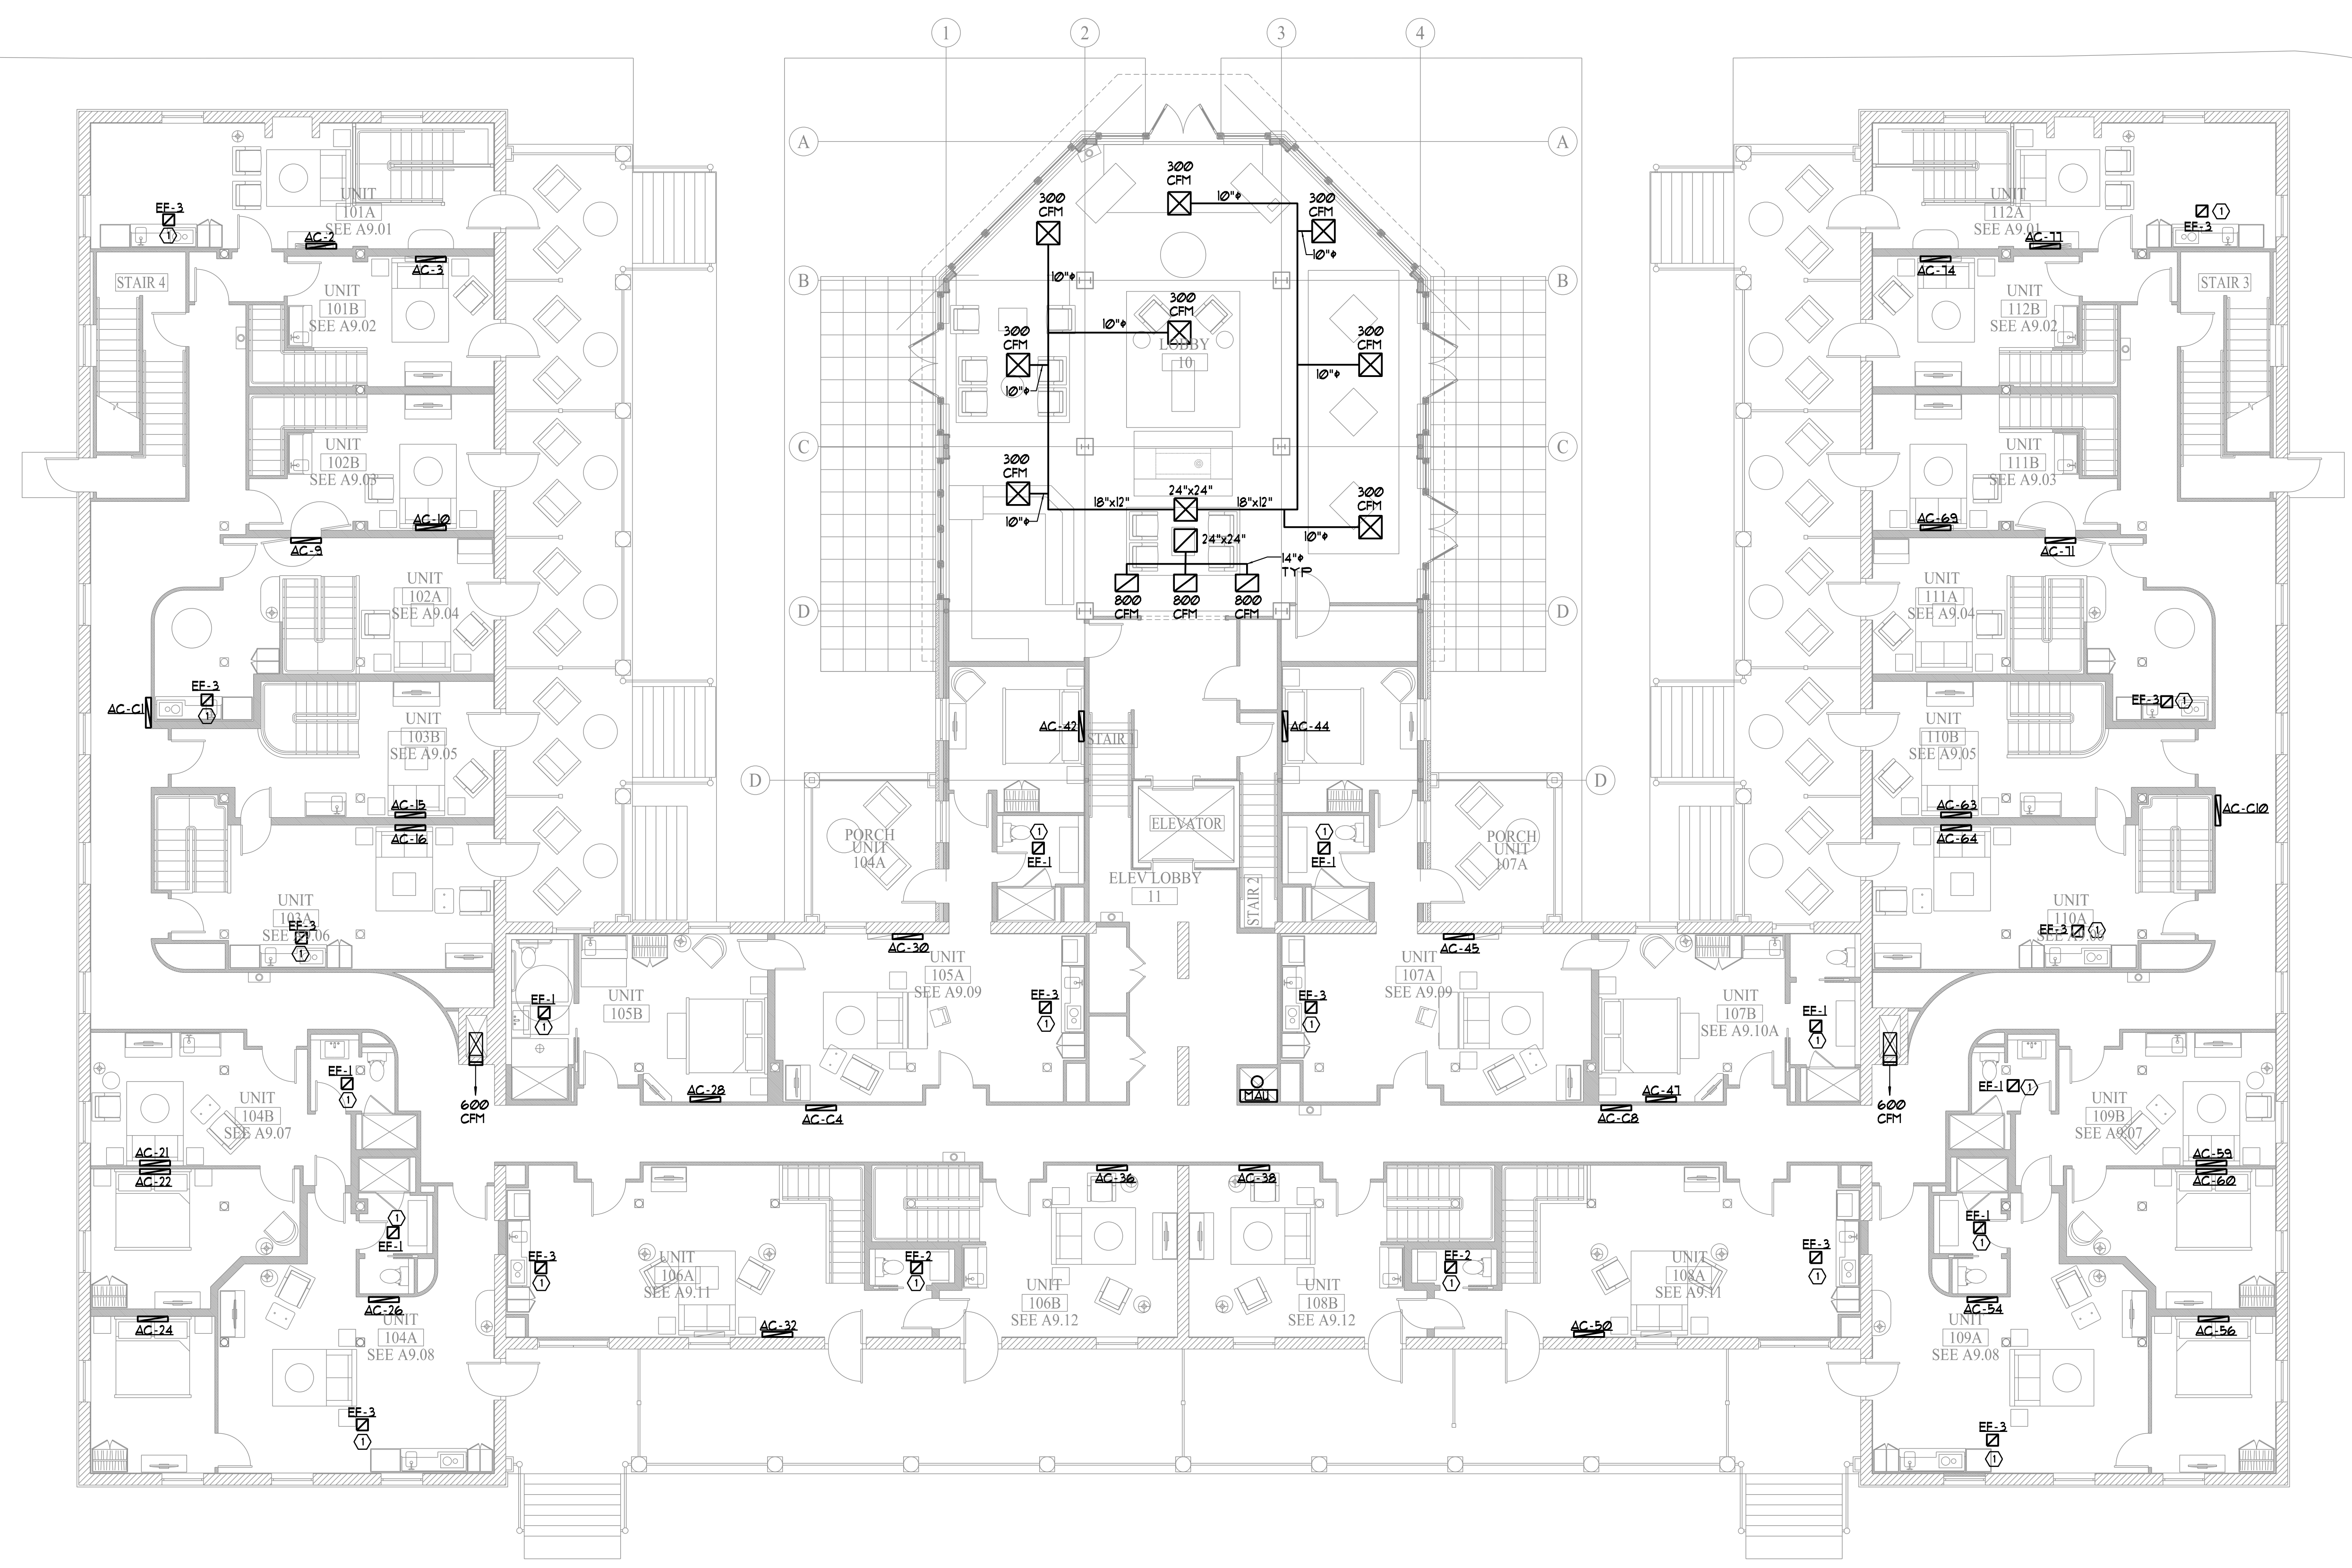

FIRST FLOOR MECHANICAL PLAN
SCALE 1/8" = 1'-0"

DIAMOND ISLAND INN
FIRST FLOOR MECHANICAL PLAN

Date Drawn -	9-10-13
Drawn By -	SMR
Revised -	
Project #	3394
Scale -	1/8" = 1'-0"
Sheet Number -	M1.01