


① FIELD ROUTE 4" DIAMETER EXHAUST DUCT UP THRU ATTIC TO CUPOLA.

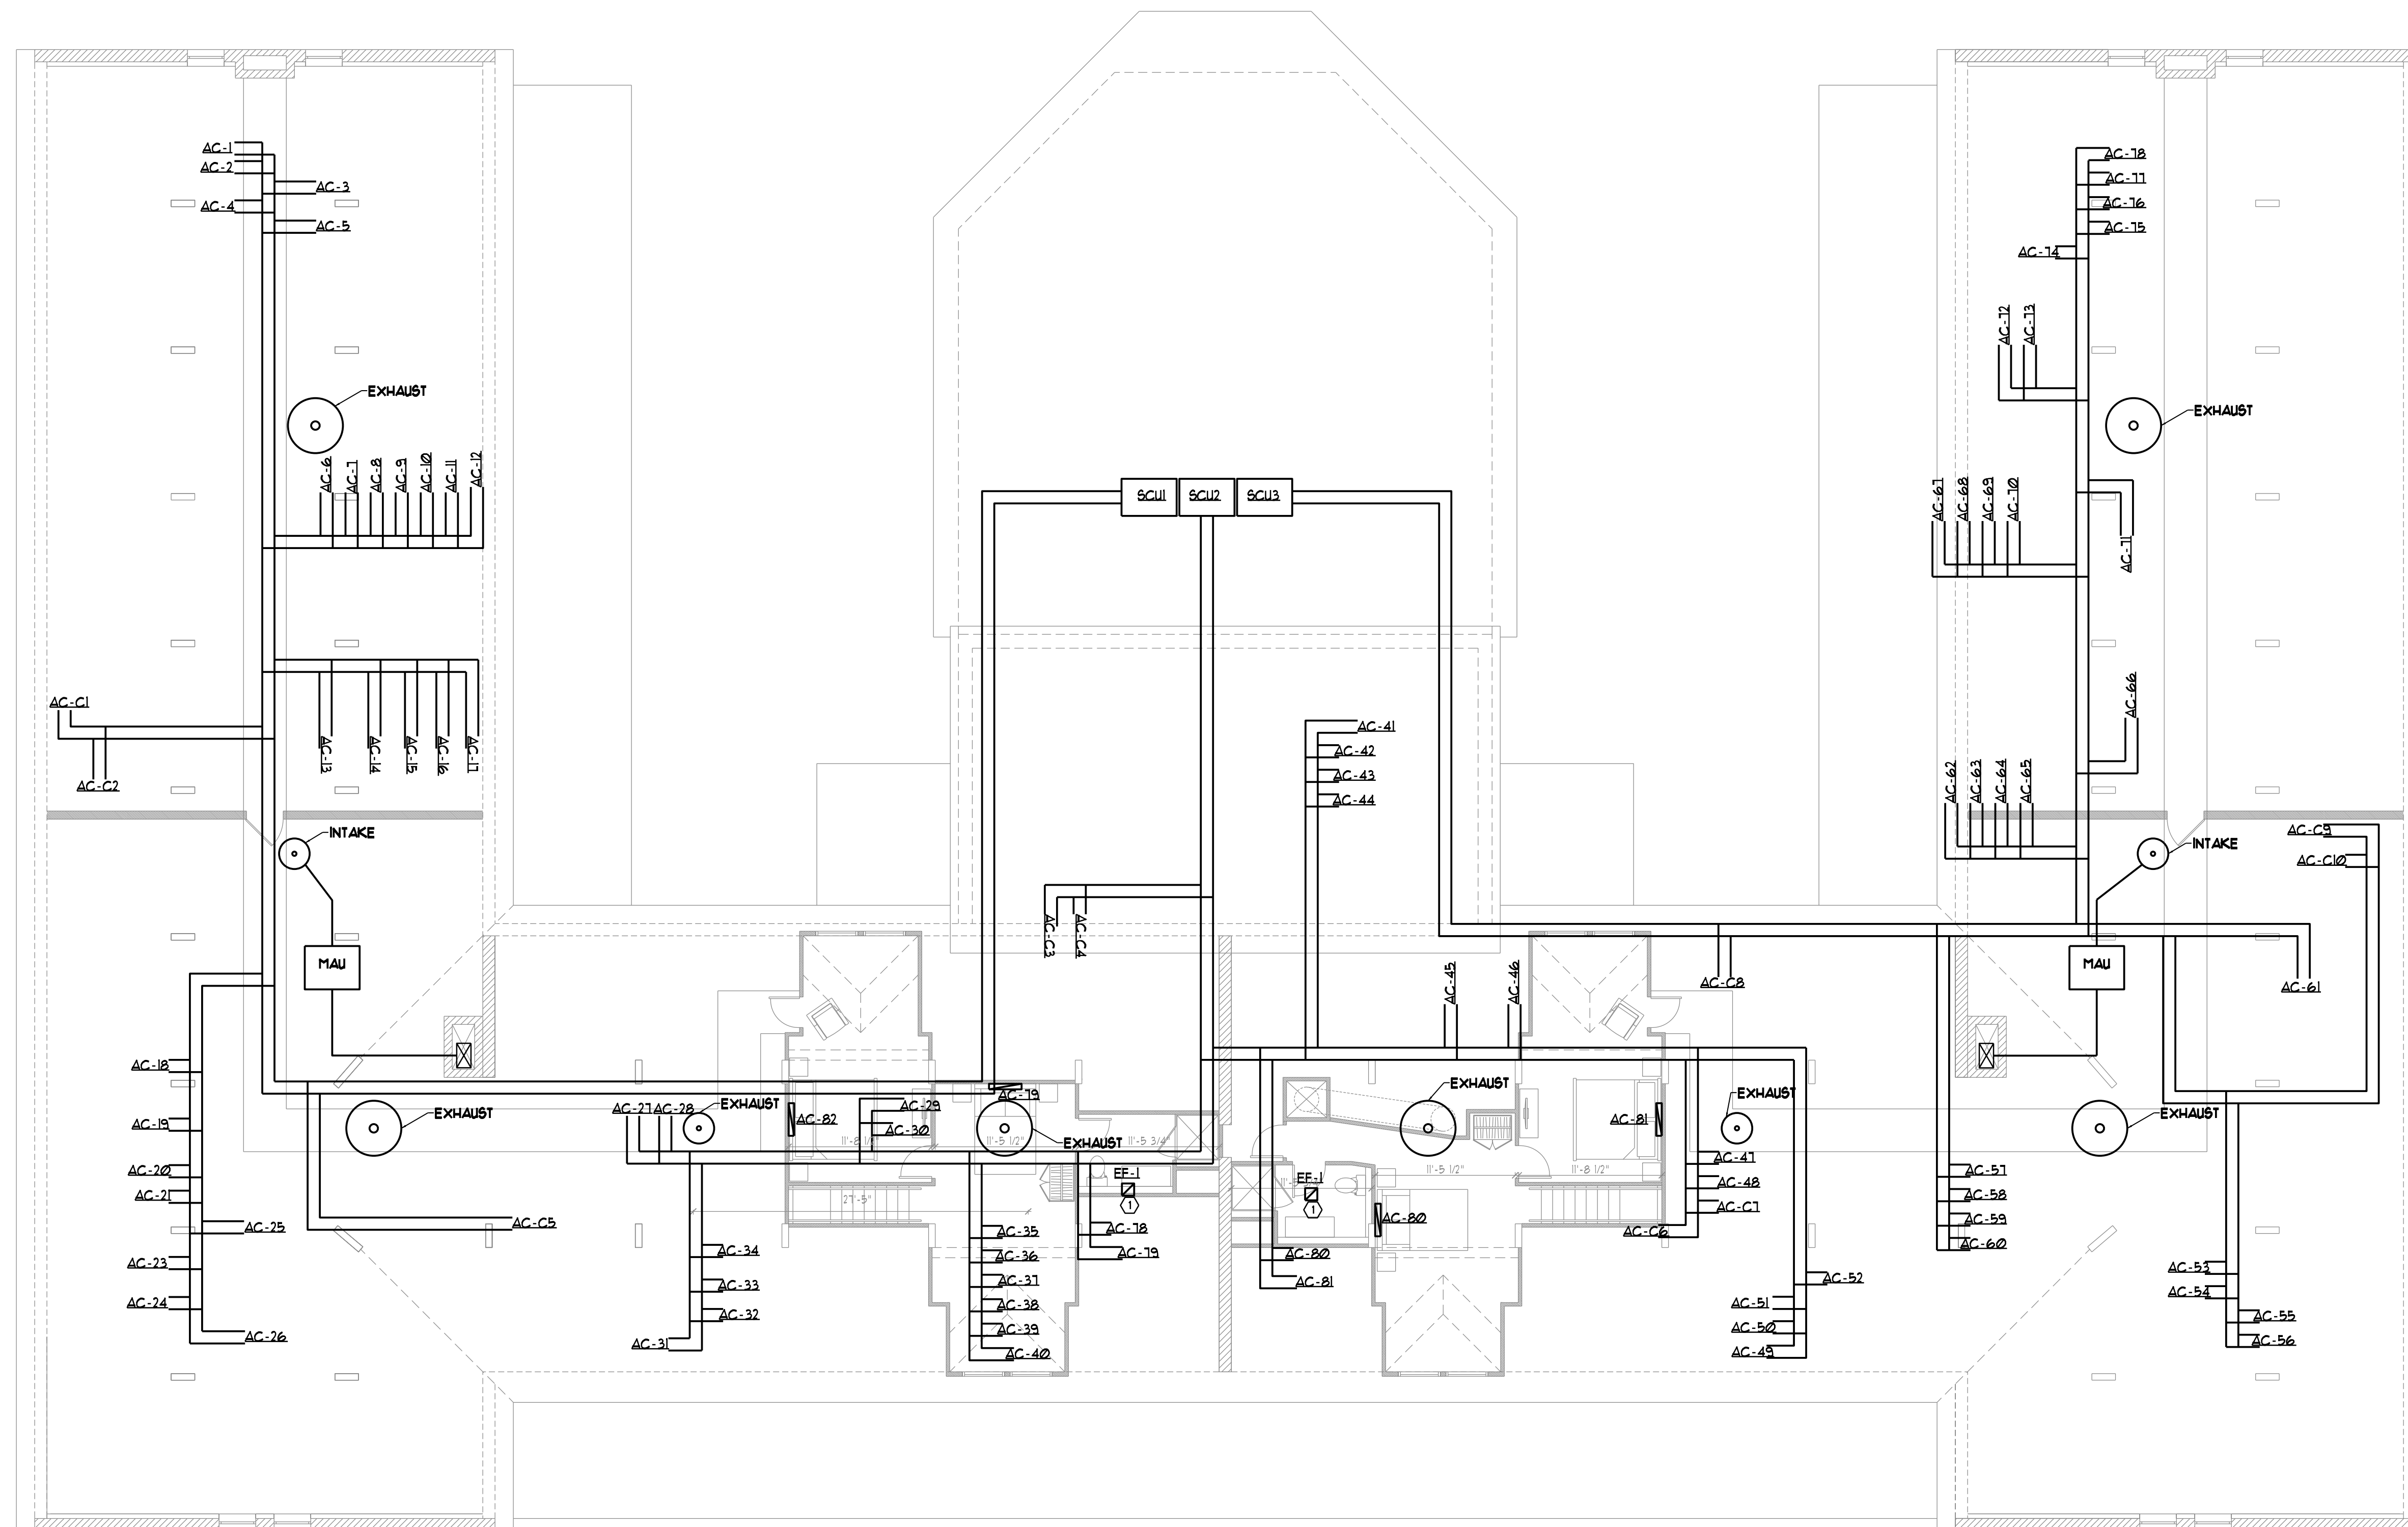

THIRD FLOOR MECHANICAL PLAN  
SCALE 1/8" = 1'-0"

DIAMOND ISLAND INN

THIRD FLOOR MECHANICAL PLAN

Date Drawn - 9-10-13

Drawn By - SMR

Revised -

Project # 3394

Scale - 1/8" = 1'-0"

Sheet Number - M1.03