

FIRE & CARBON MONOXIDE SYSTEMS (IRC 2009)

RSB.2.1 AUTOMATIC RESIDENTIAL FIRE SPRINKLER SYSTEMS SHALL BE DESIGNED AND INSTALLED IN ACCORDANCE WITH SECTION P2404 OR NFPA 13D

RS14 SMOKE ALARMS ALL SMOKE ALARMS SHALL BE LISTED IN ACCORDANCE WITH UL217 & INSTALLED IN IMMEDIATE VICINITY OF THE BEDROOMS. INSTALLED & LISTED AS COMPLYING W/ UL 2084

RS15 CARBON MONOXIDE ALARMS SHALL BE INSTALLED OUTSIDE OF EACH SEPARATE SLEEPING AREA IN THE IMMEDIATE VICINITY OF THE BEDROOMS. INSTALLED & LISTED AS COMPLYING W/ UL 2084

HVAC SYSTEMS
TO BE BUILT IN ACCORDANCE WITH IECC 2009 SECTION 403

ELECTRICAL POWER AND LIGHTING SYSTEMS
TO BE BUILT IN ACCORDANCE WITH IECC 2009 SECTION 404

KB A
kevin browne ARCHITECTURE
207 - 847 - 3499
kevin@kevinbrowne.com
7 breezy hill lane
falmouth, me 04105


REVISIONS:
4-15-14 ISSUE FOR PERMIT
5-15-14 ISSUE PER REVISION CLOUDS

CONSULTANTS:

BEAULIEU RESIDENCE
CLIENT: RON & LORI BEAULIEU
ADDRESS: LOT #61
GREAT DIAMOND ISLAND, ME

FIRST FLOOR PLAN
DATE: 6/19/2014
DRAWN: KW/B
PROJECT NO.: 2013-14
SCALE: 1/4" = 1'-0"

A1.2

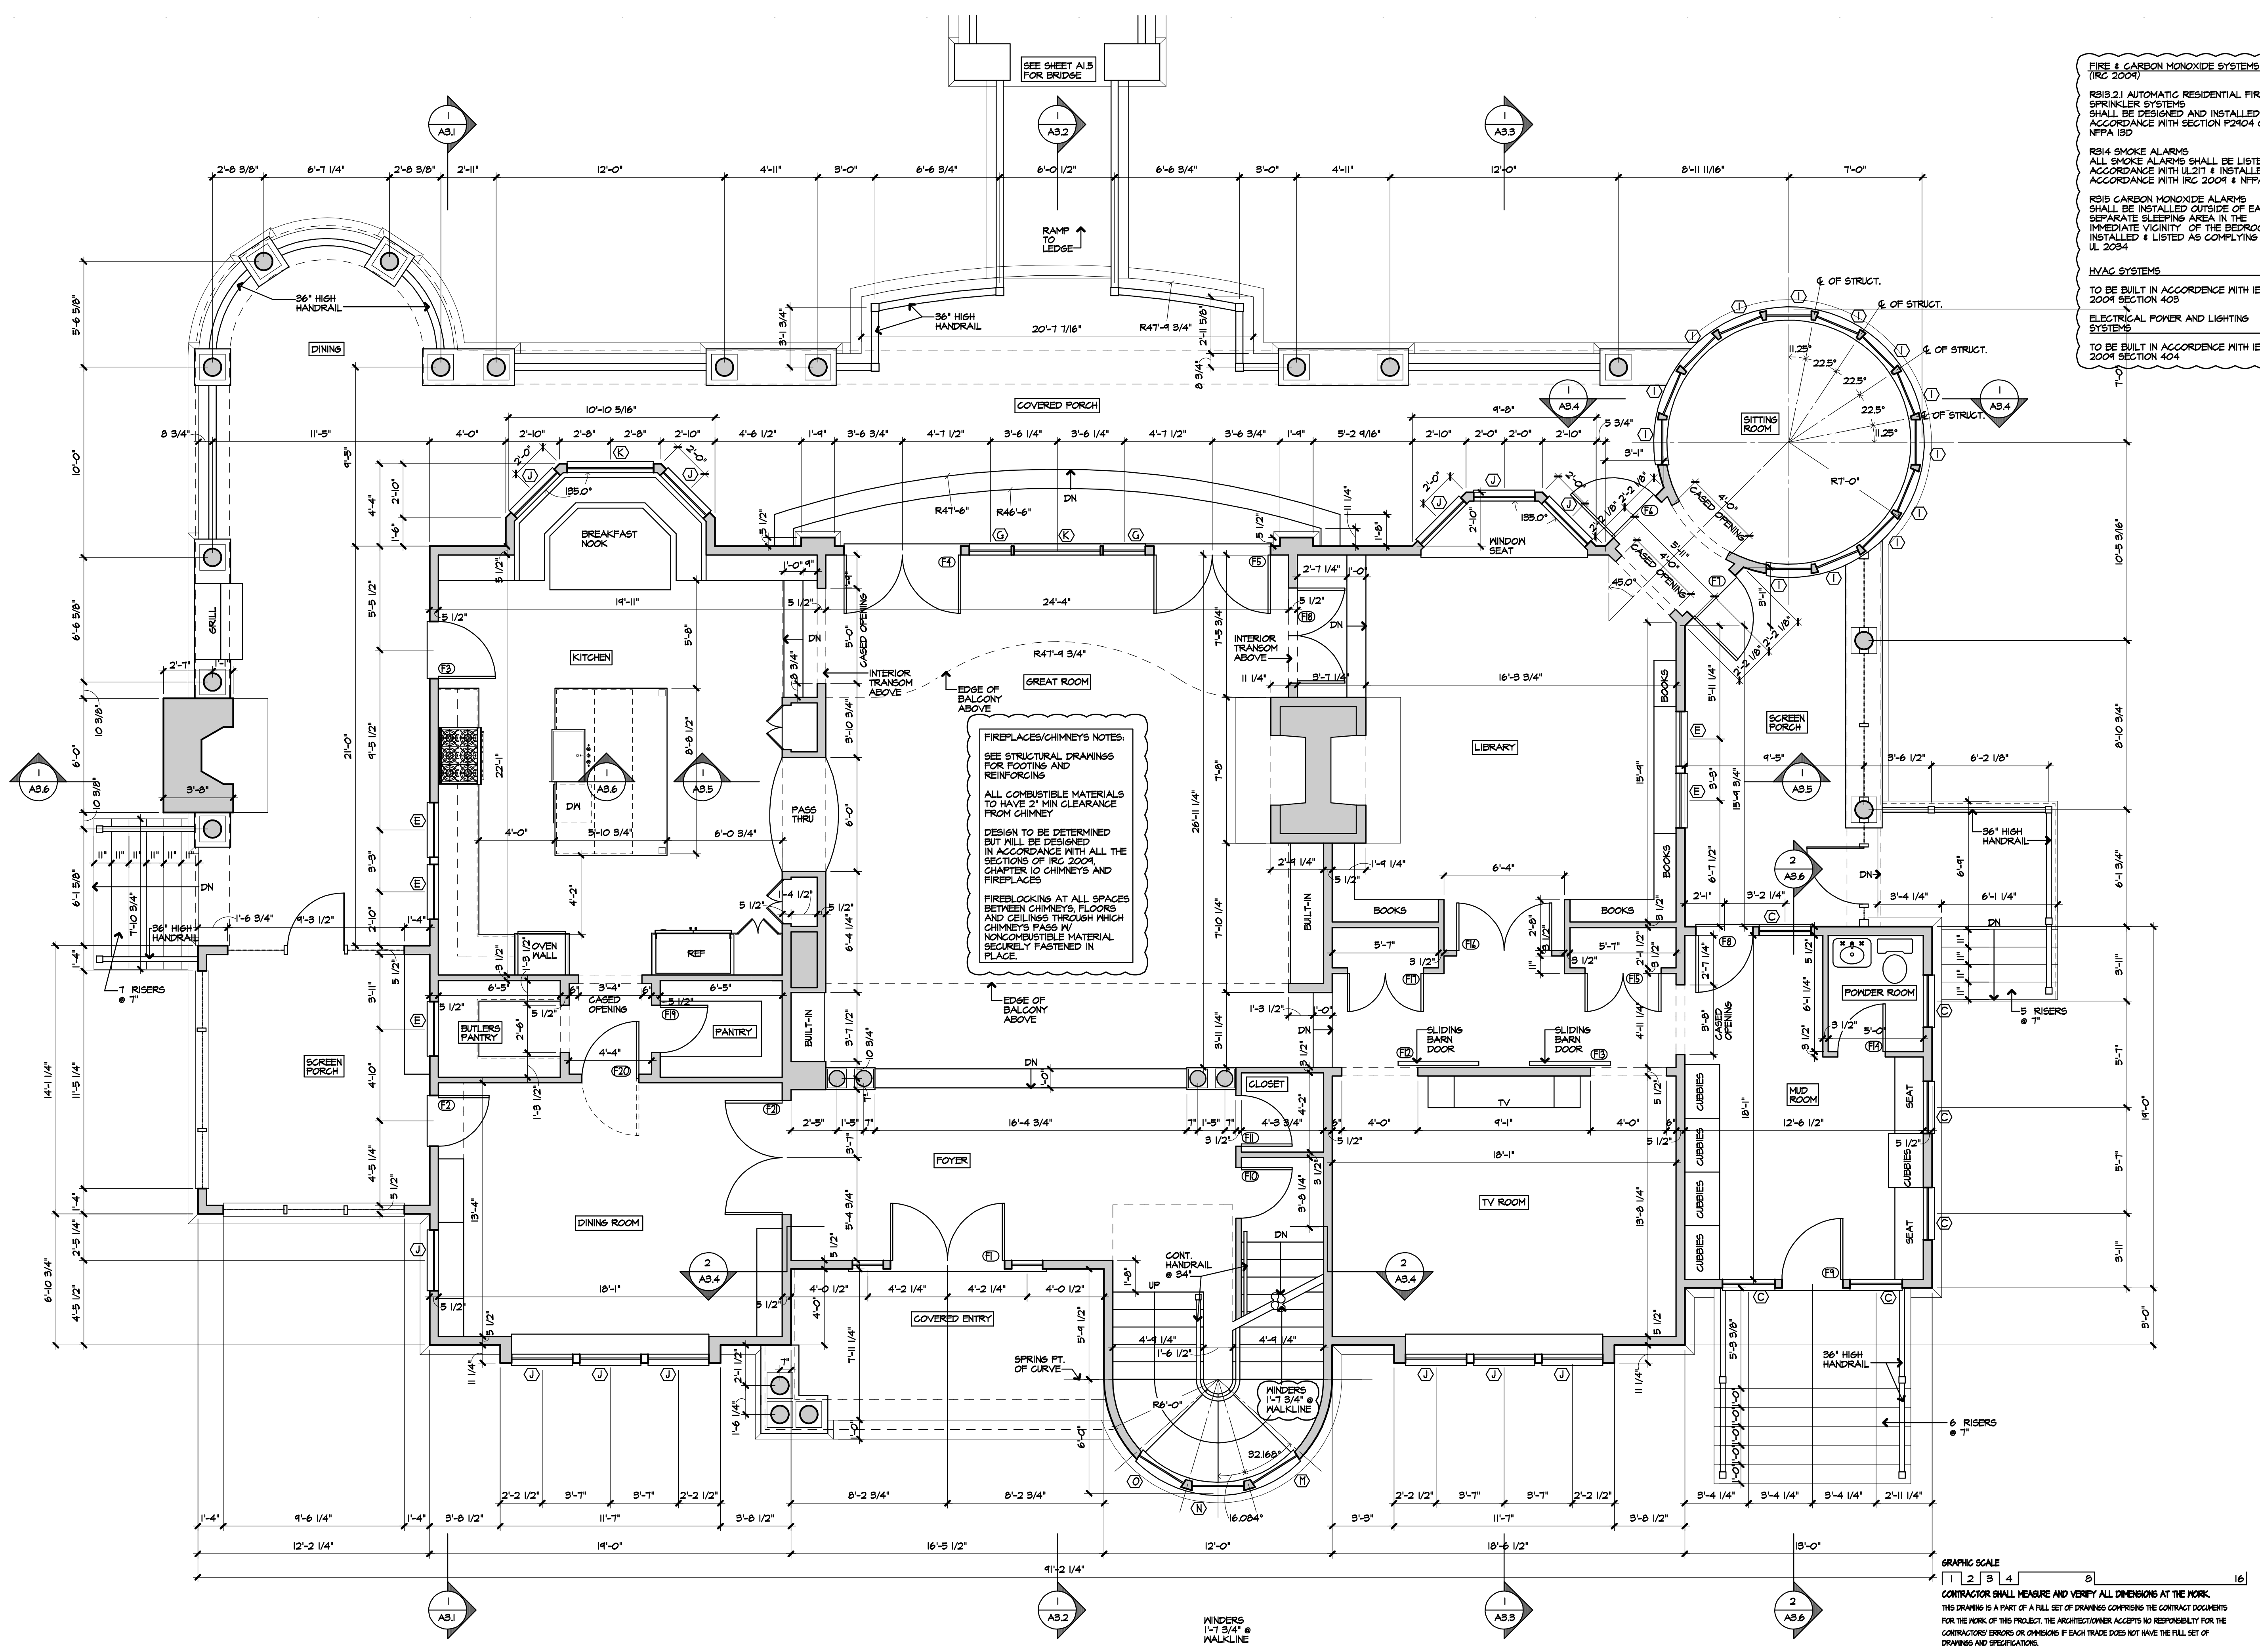

1 FIRST FLOOR PLAN
A1.2 1/4" = 1'-0"

3240 SQ.FT.

GRAPHIC SCALE
1 2 3 4 8 16
CONTRACTOR SHALL MEASURE AND VERIFY ALL DIMENSIONS AT THE WORK.
THIS DRAWING IS A PART OF A FULL SET OF DRAWINGS COMPRISING THE CONTRACT DOCUMENTS FOR THE WORK OF THIS PROJECT. THE ARCHITECTURE ACCEPTS NO RESPONSIBILITY FOR THE CONTRACTOR'S ERRORS OR OMISSIONS IF EACH TRADE DOES NOT HAVE THE FULL SET OF DRAWINGS AND SPECIFICATIONS.

COPYRIGHT 2014 ©
THE MATERIAL CONTAINED IN THESE DRAWINGS AND THE DESIGN THEY ARE INTENDED TO CONVEY ARE THE EXCLUSIVE PROPERTY OF KEVIN BROWNE ARCHITECTURE LLC. POSSESSION AND USE HEREOF IS GRANTED ONLY CONFIDENTIALLY IN CONNECTION WITH THE CONSTRUCTION OF THE BUILDING SPECIFIC HEREIN AS AUTHORIZED BY KEVIN BROWNE ARCHITECTURE LLC. THE REQUIRMENT AGREES TO ABIDE BY THESE RESTRICTIONS. ANY REPRODUCTION OR DISCLOSURE OF ANY INFORMATION IN WHOLE OR IN PART, CONTAINED HEREIN, WITHOUT WRITTEN PERMISSION OF KEVIN BROWNE ARCHITECTURE LLC, IS EXPRESSLY PROHIBITED.