


Rachel Conly

Architectural Design

207.766.5625

First Floor
Power & Lighting

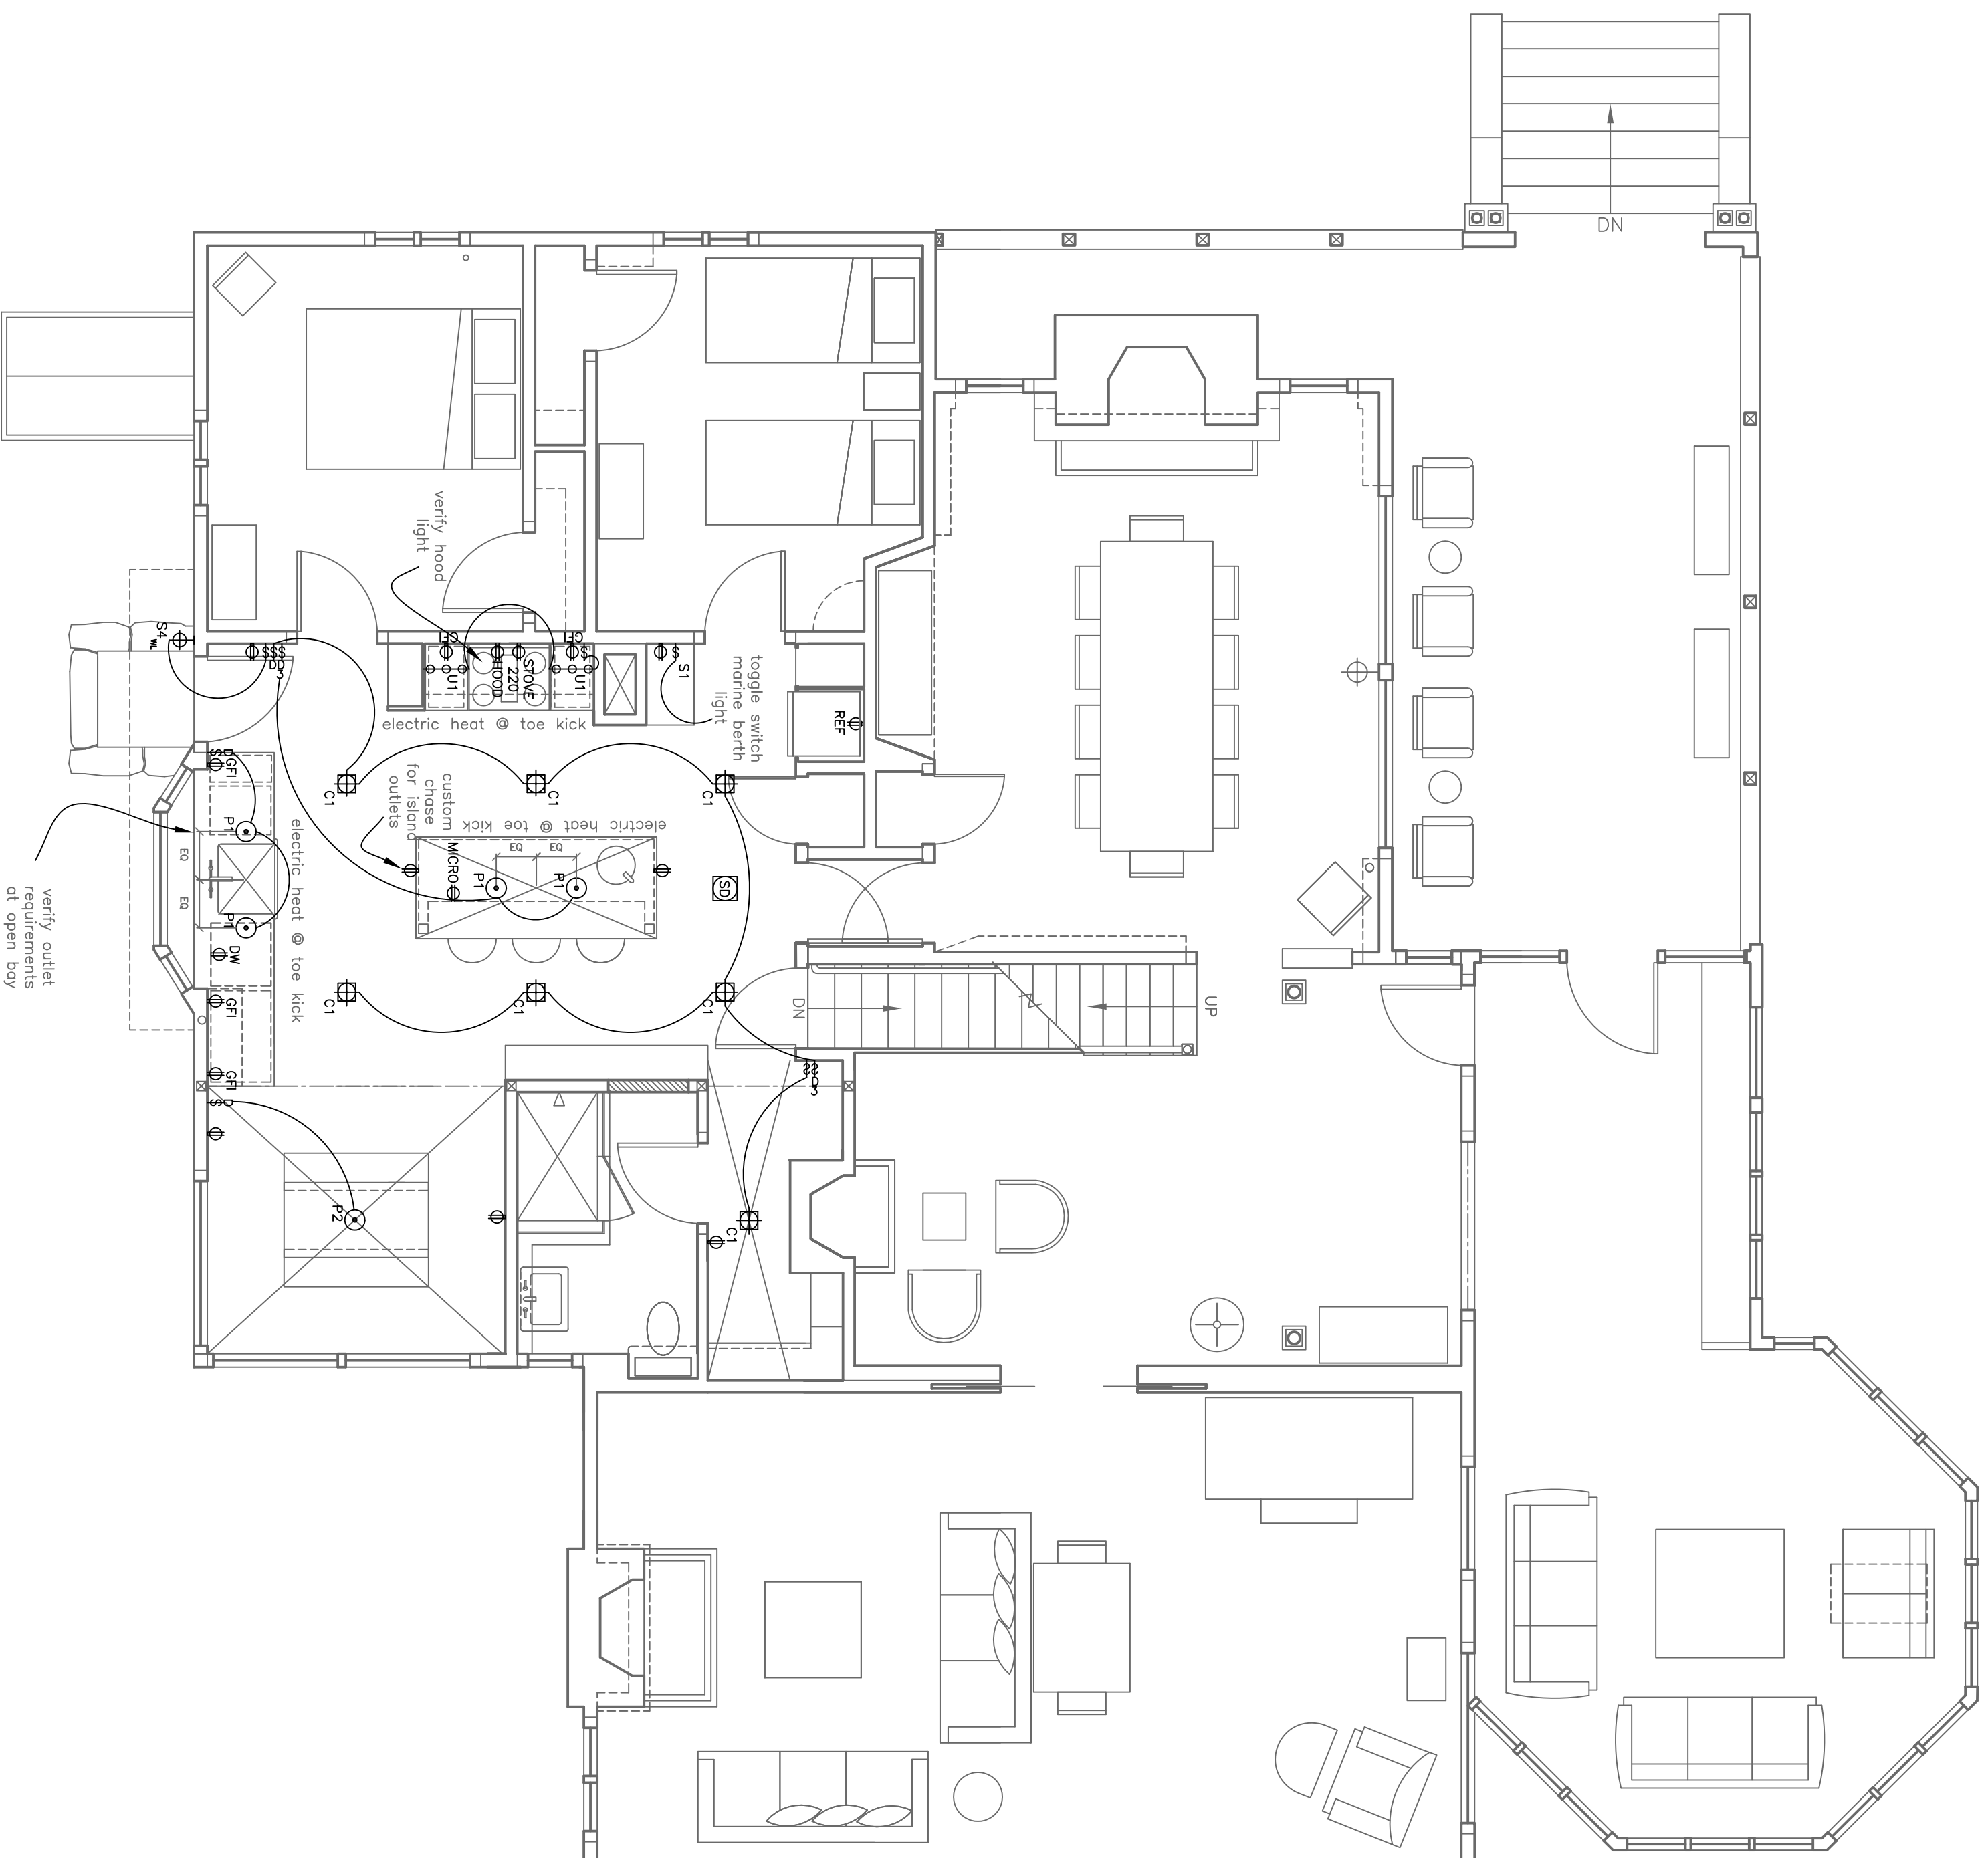

PROJECT

**Frexes Steed
Residence**

**3 Torrington Point
Peaks Island, Maine
04108**

DATE REVISED 10.17.12

SCALE 1.13.13

NOTES DRAWN BY
Rachel

A

Kitchen Power and Lighting Plan
1/4" = 1'-0"

A8