


Rachel Conly


Architectural Design

Peaks Island, Maine 04108
207.766.5625

**Proposed Power,
Lighting &
Framing Plan**

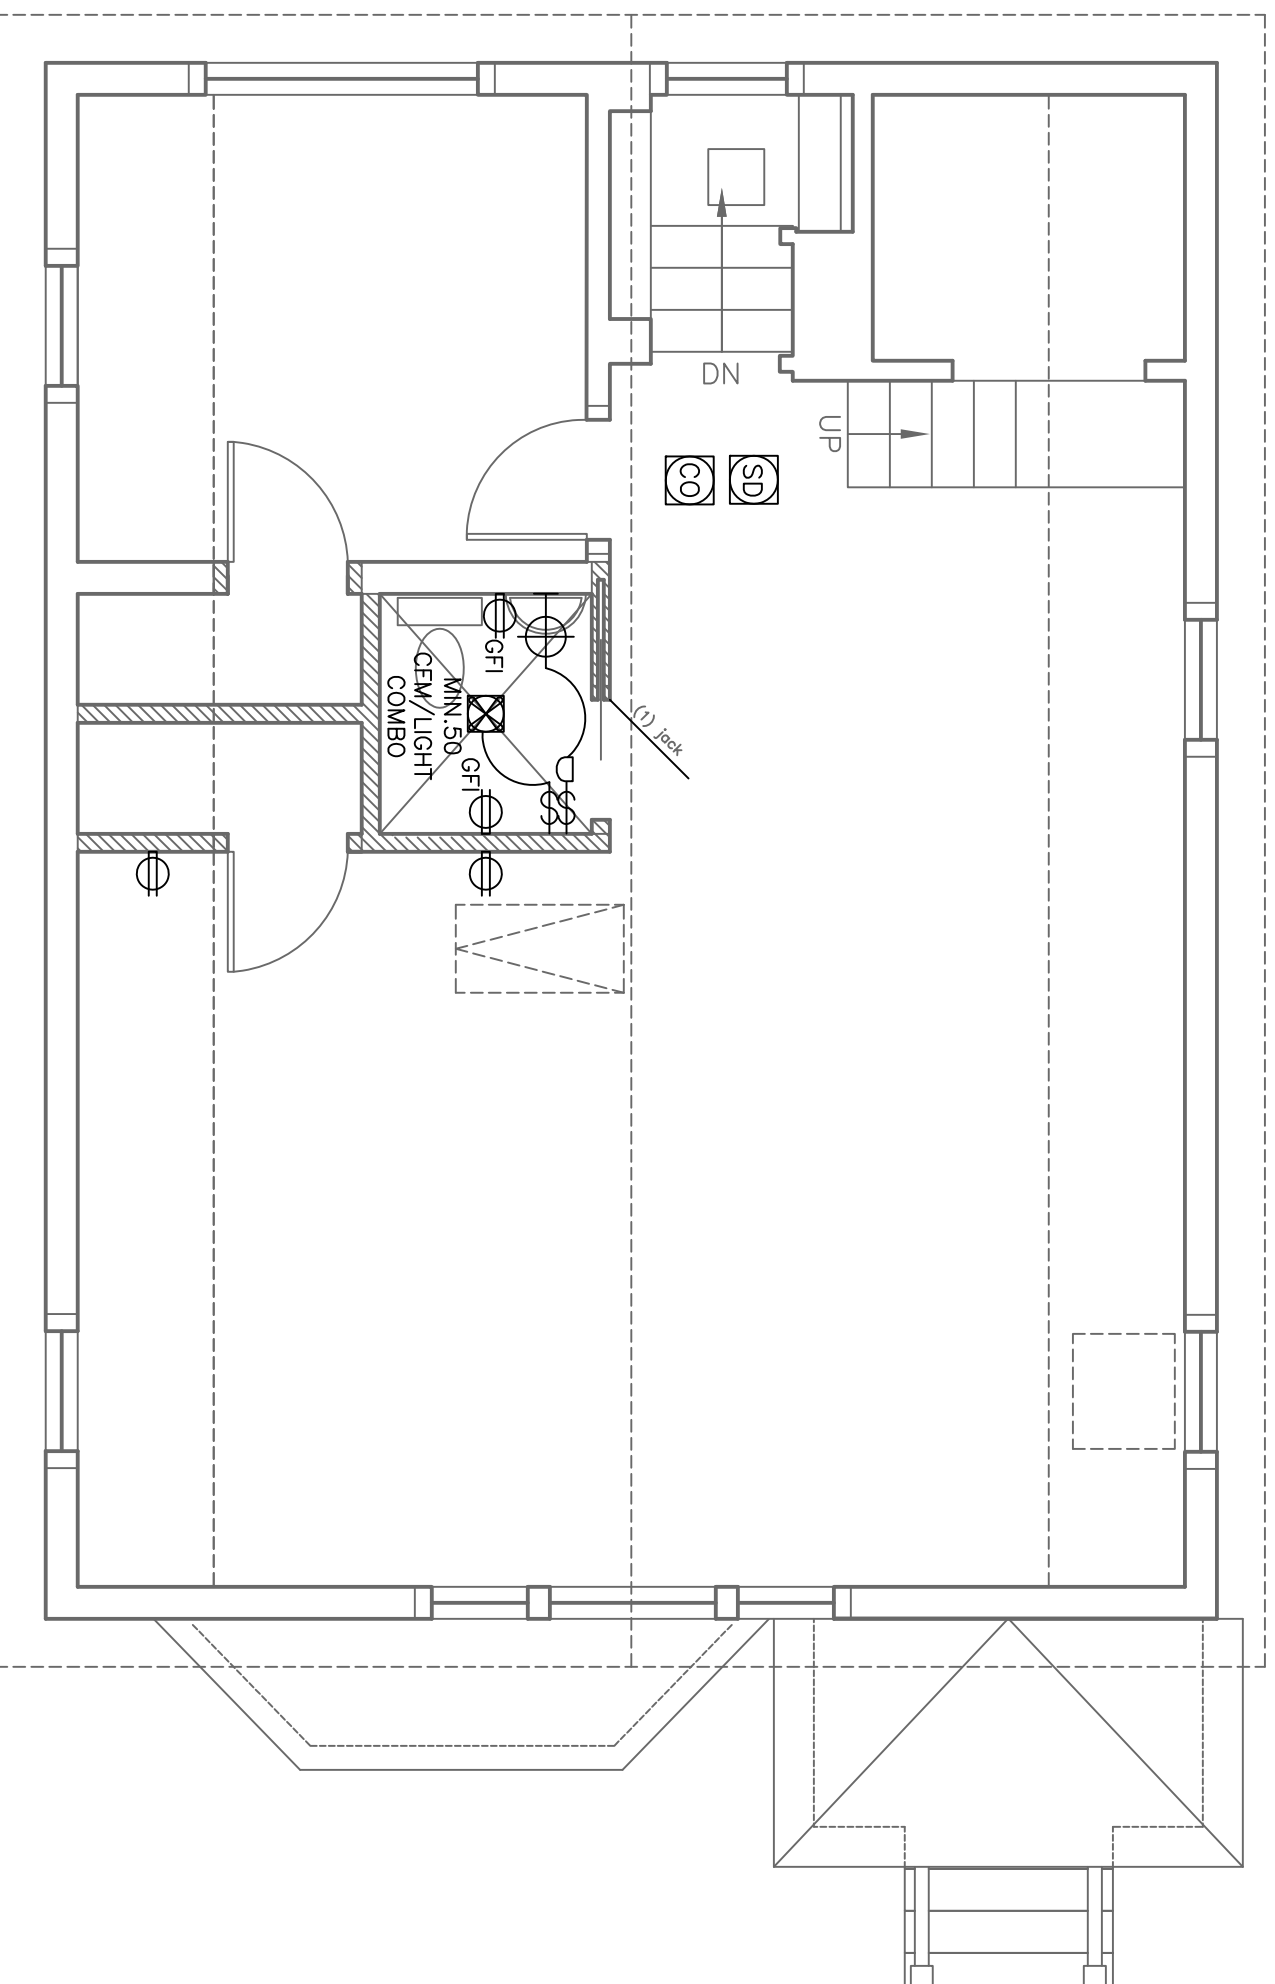

A Proposed Power & Lighting Plan
1/4" = 1'-0"

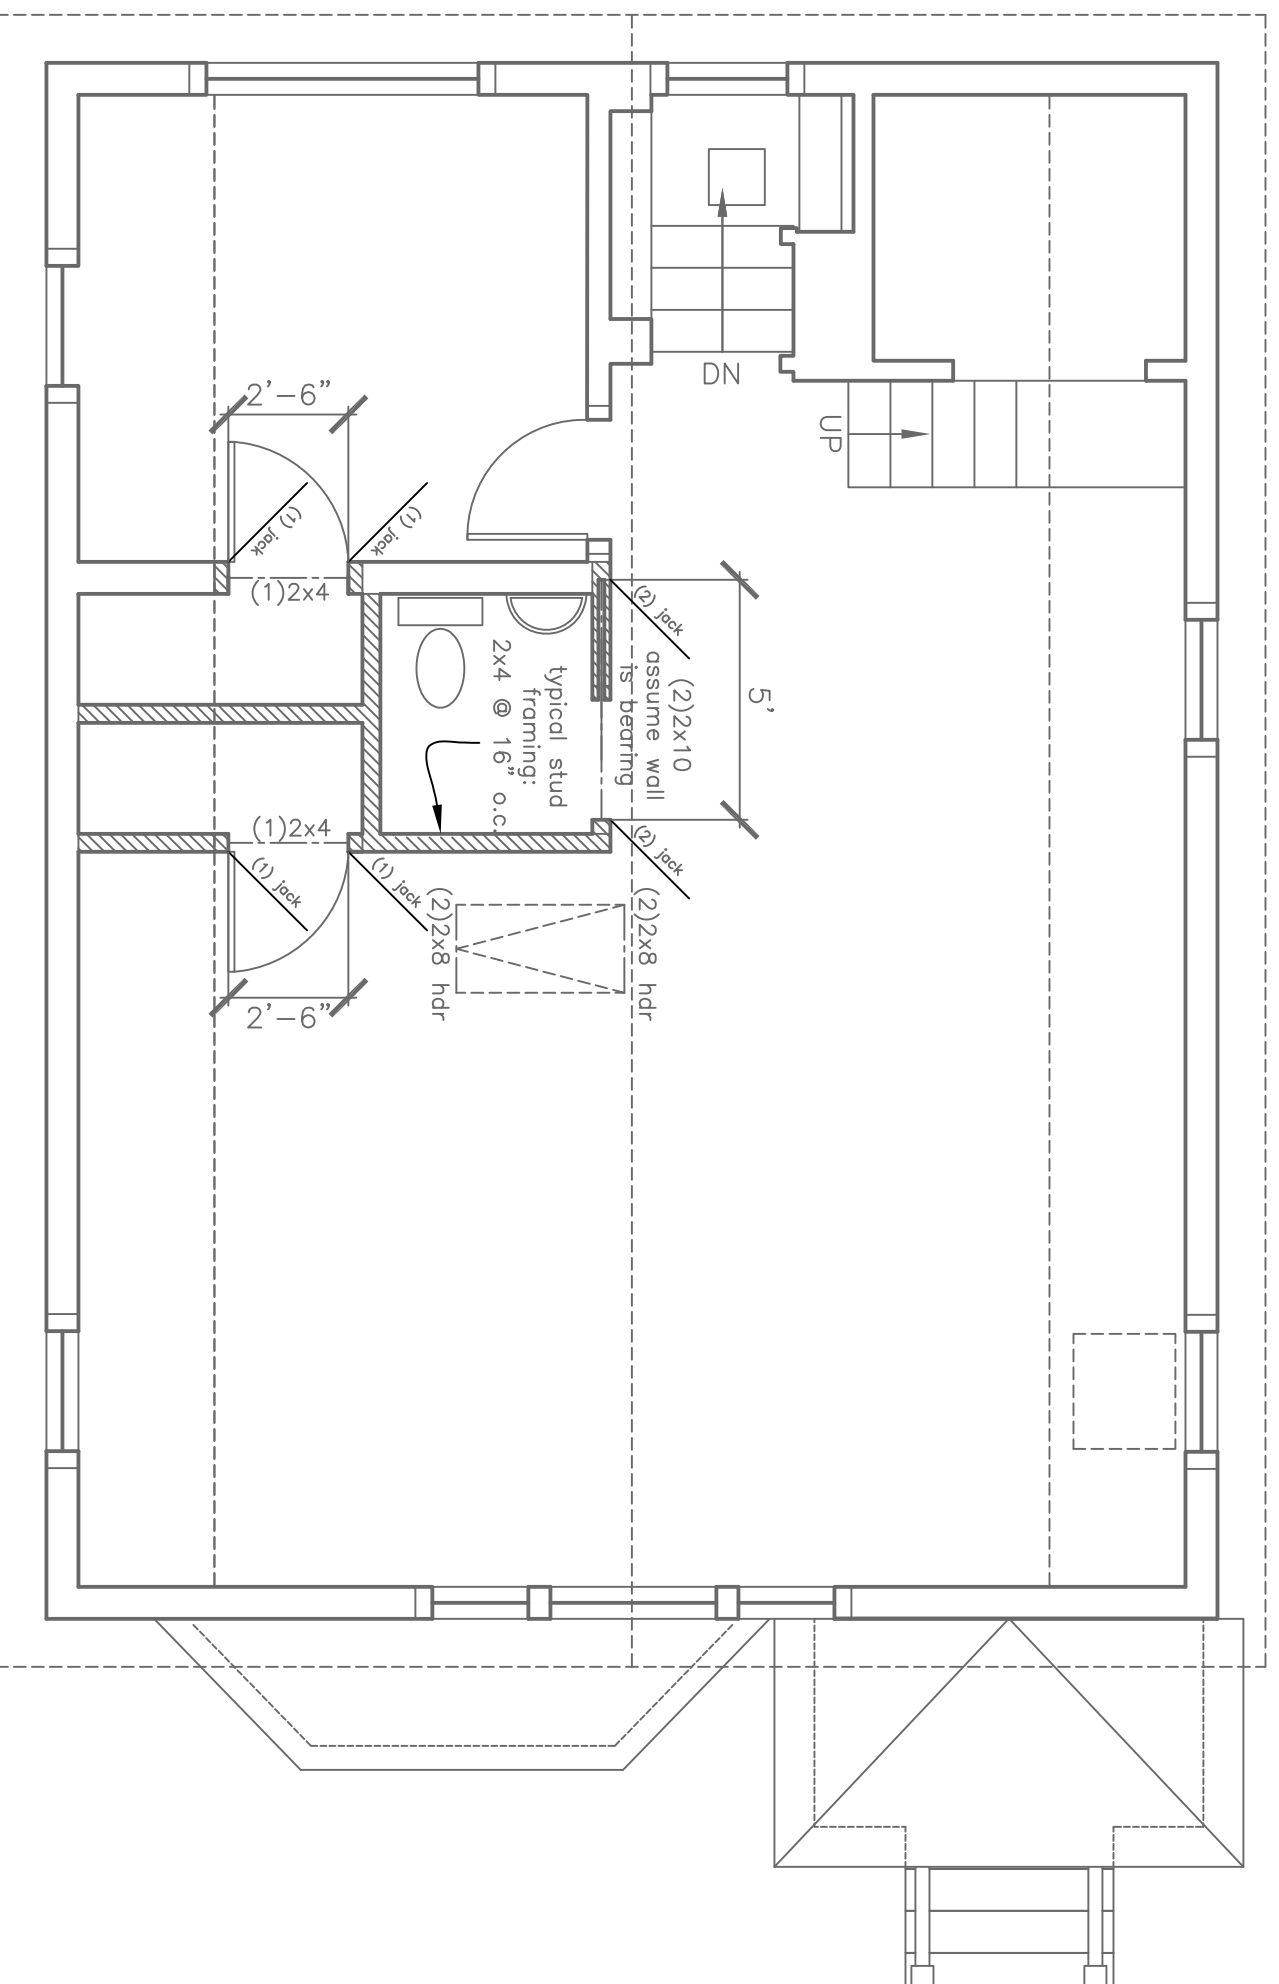

B Proposed Framing Plan
1/4" = 1'-0"

PROJECT
Mills Benedict
Residence

9 Sandpiper Road
Peaks Island, Me.
04108

DATE	REVISED
5.3.13	5.21.13

SCALE
1/4" = 1'-0"

NOTES

DRAWN BY
Rachel

A3