


First Floor  
Lighting Plan

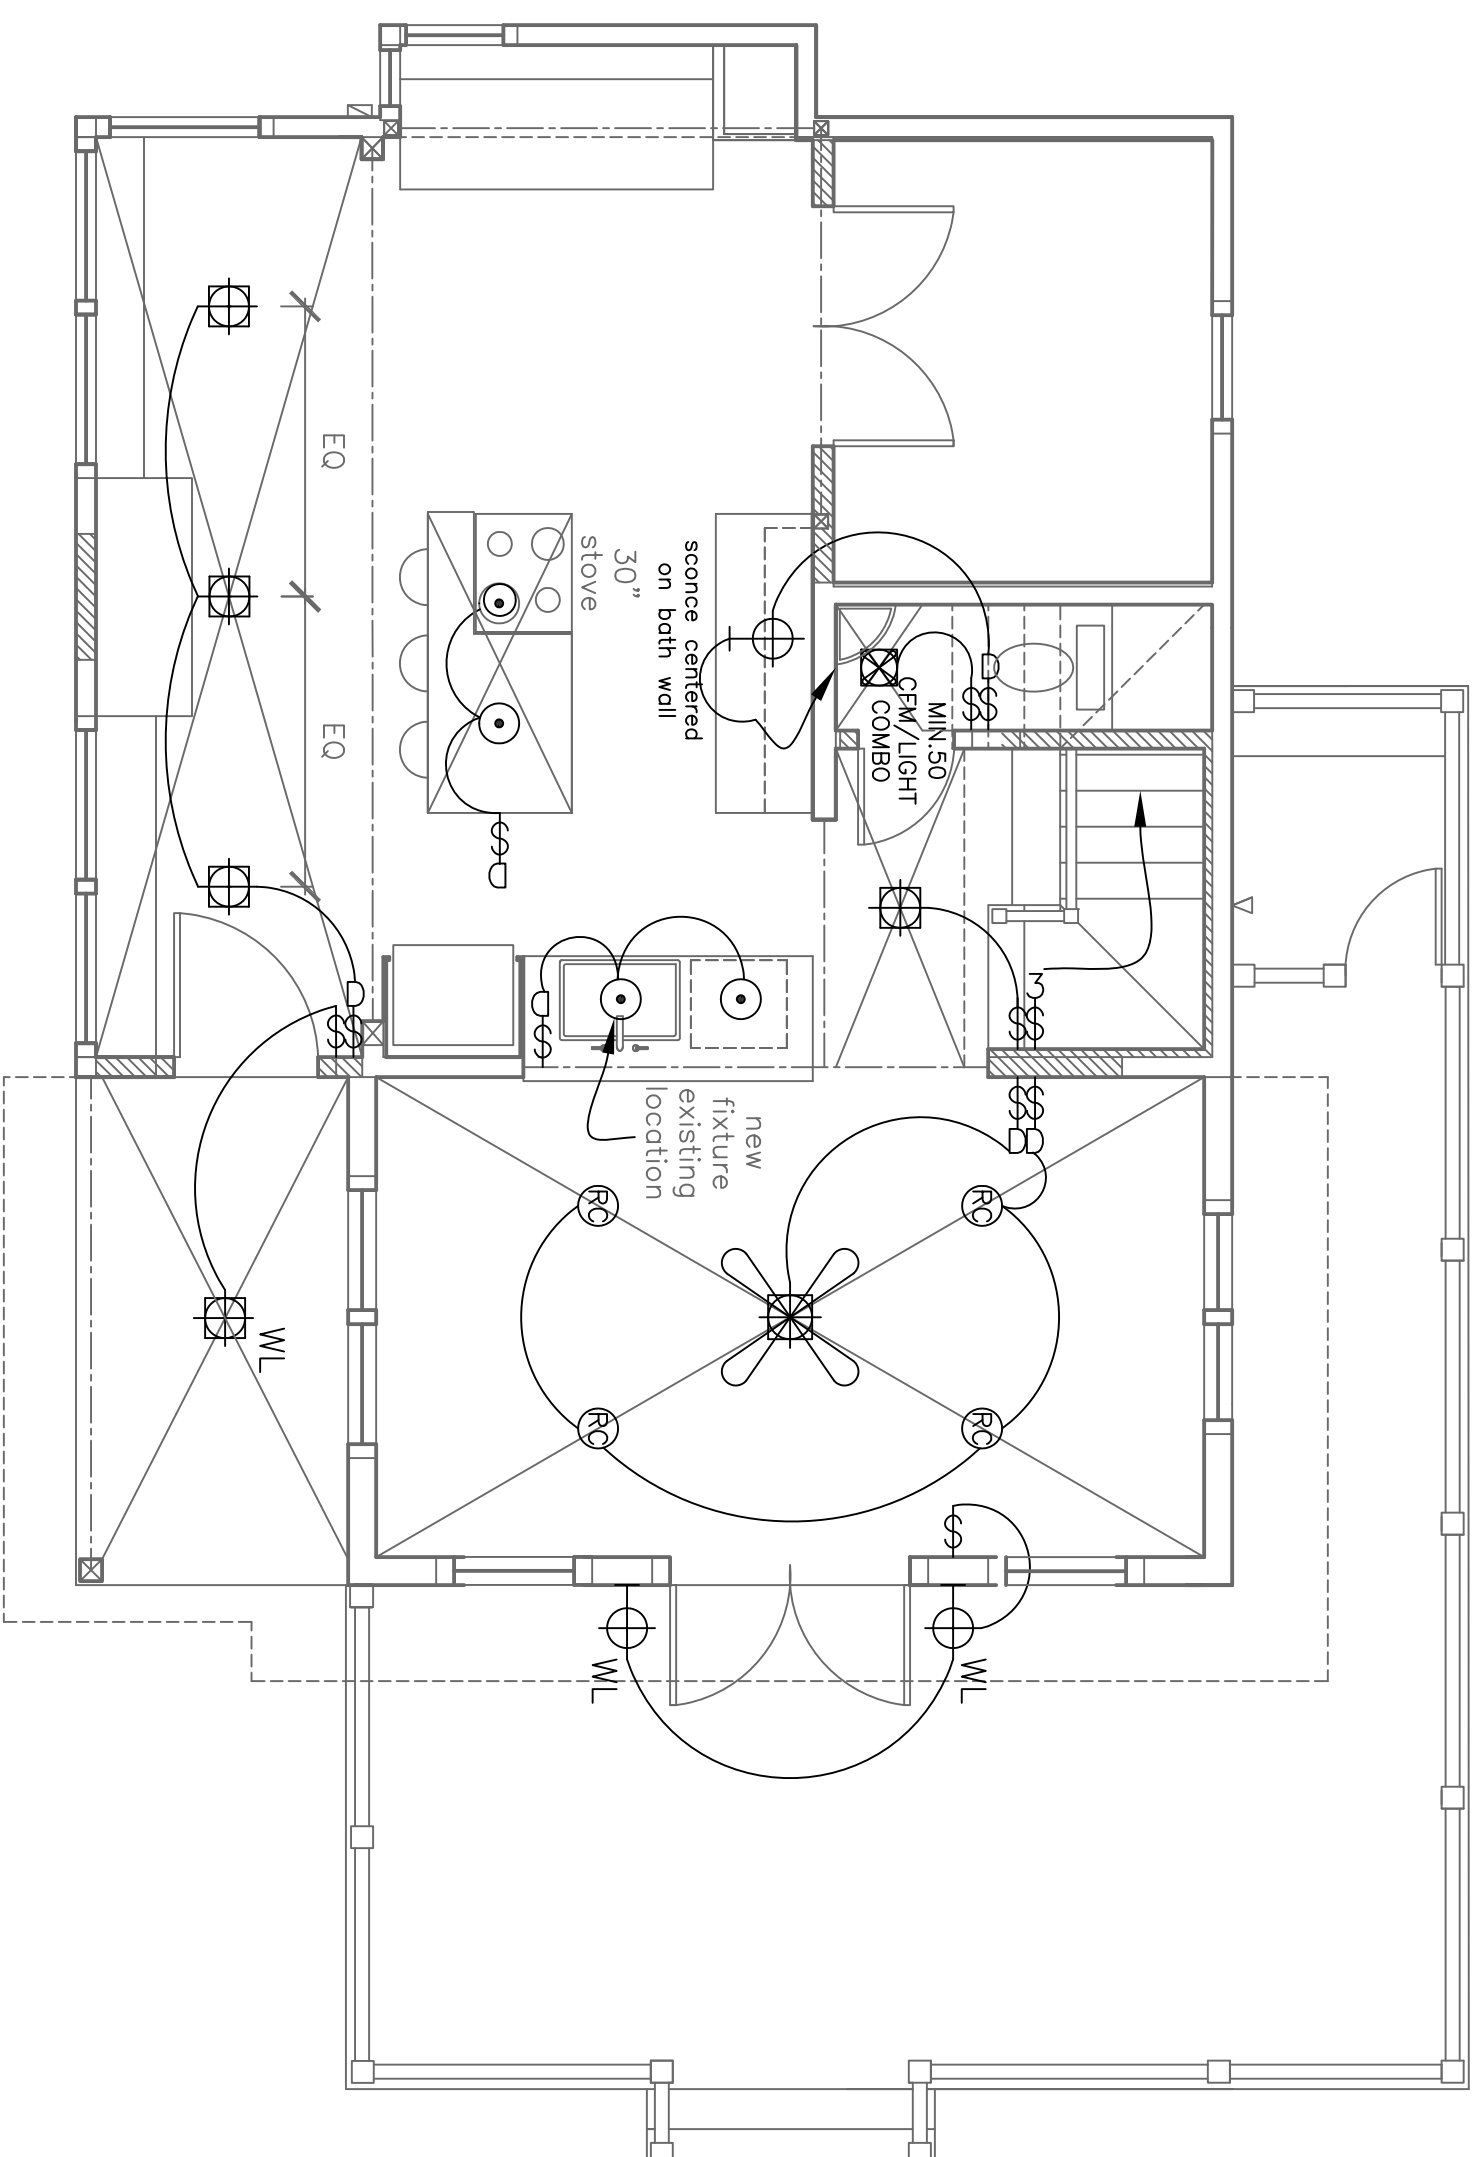

(A) Proposed First Floor Lighting Plan  
1/4" = 1'-0"

PROJECT

Moan Residence

186 Seashore Avenue  
Peaks Island, Me.  
04108

DATE 12.6.12 REVISED 1.4.13

SCALE 1/4" = 1'-0" DRAWN BY Rachel

NOTES

- ⊕ duplex
- ⊕ ground-fault circuit interrupter 220 volt
- ⊕ switch
- ⊕ 3-way switch
- ⊕ dinner switch
- ⊕ smoke detector
- ⊕ minimum 50 dfm vent fan
- MIN.50 CFM
- ⊕ ceiling mount pendant light fixture
- ⊕ recessed can light fixture
- ⊕ wall sconce light fixture
- ⊕ wet location wall sconce light fixture
- ⊕ track lighting
- ⊕ fluorescent body switched
- undercounter
- ⊕ ceiling fan / integral light
- ⊕ ceiling fan
- ⊕ phone jack
- ⊕ DSL
- ⊕ CAT5
- ⊕ central vacuum
- ⊕ compact fluorescent recessed can