


**Basement
Power & Lighting
Plan Revision**

PROJECT
Shaw Residence

DATE 2.1.10 REVISED 7.27.12

SCALE 1/4" = 1'-0"
DRAWN BY Rachel

NOTES

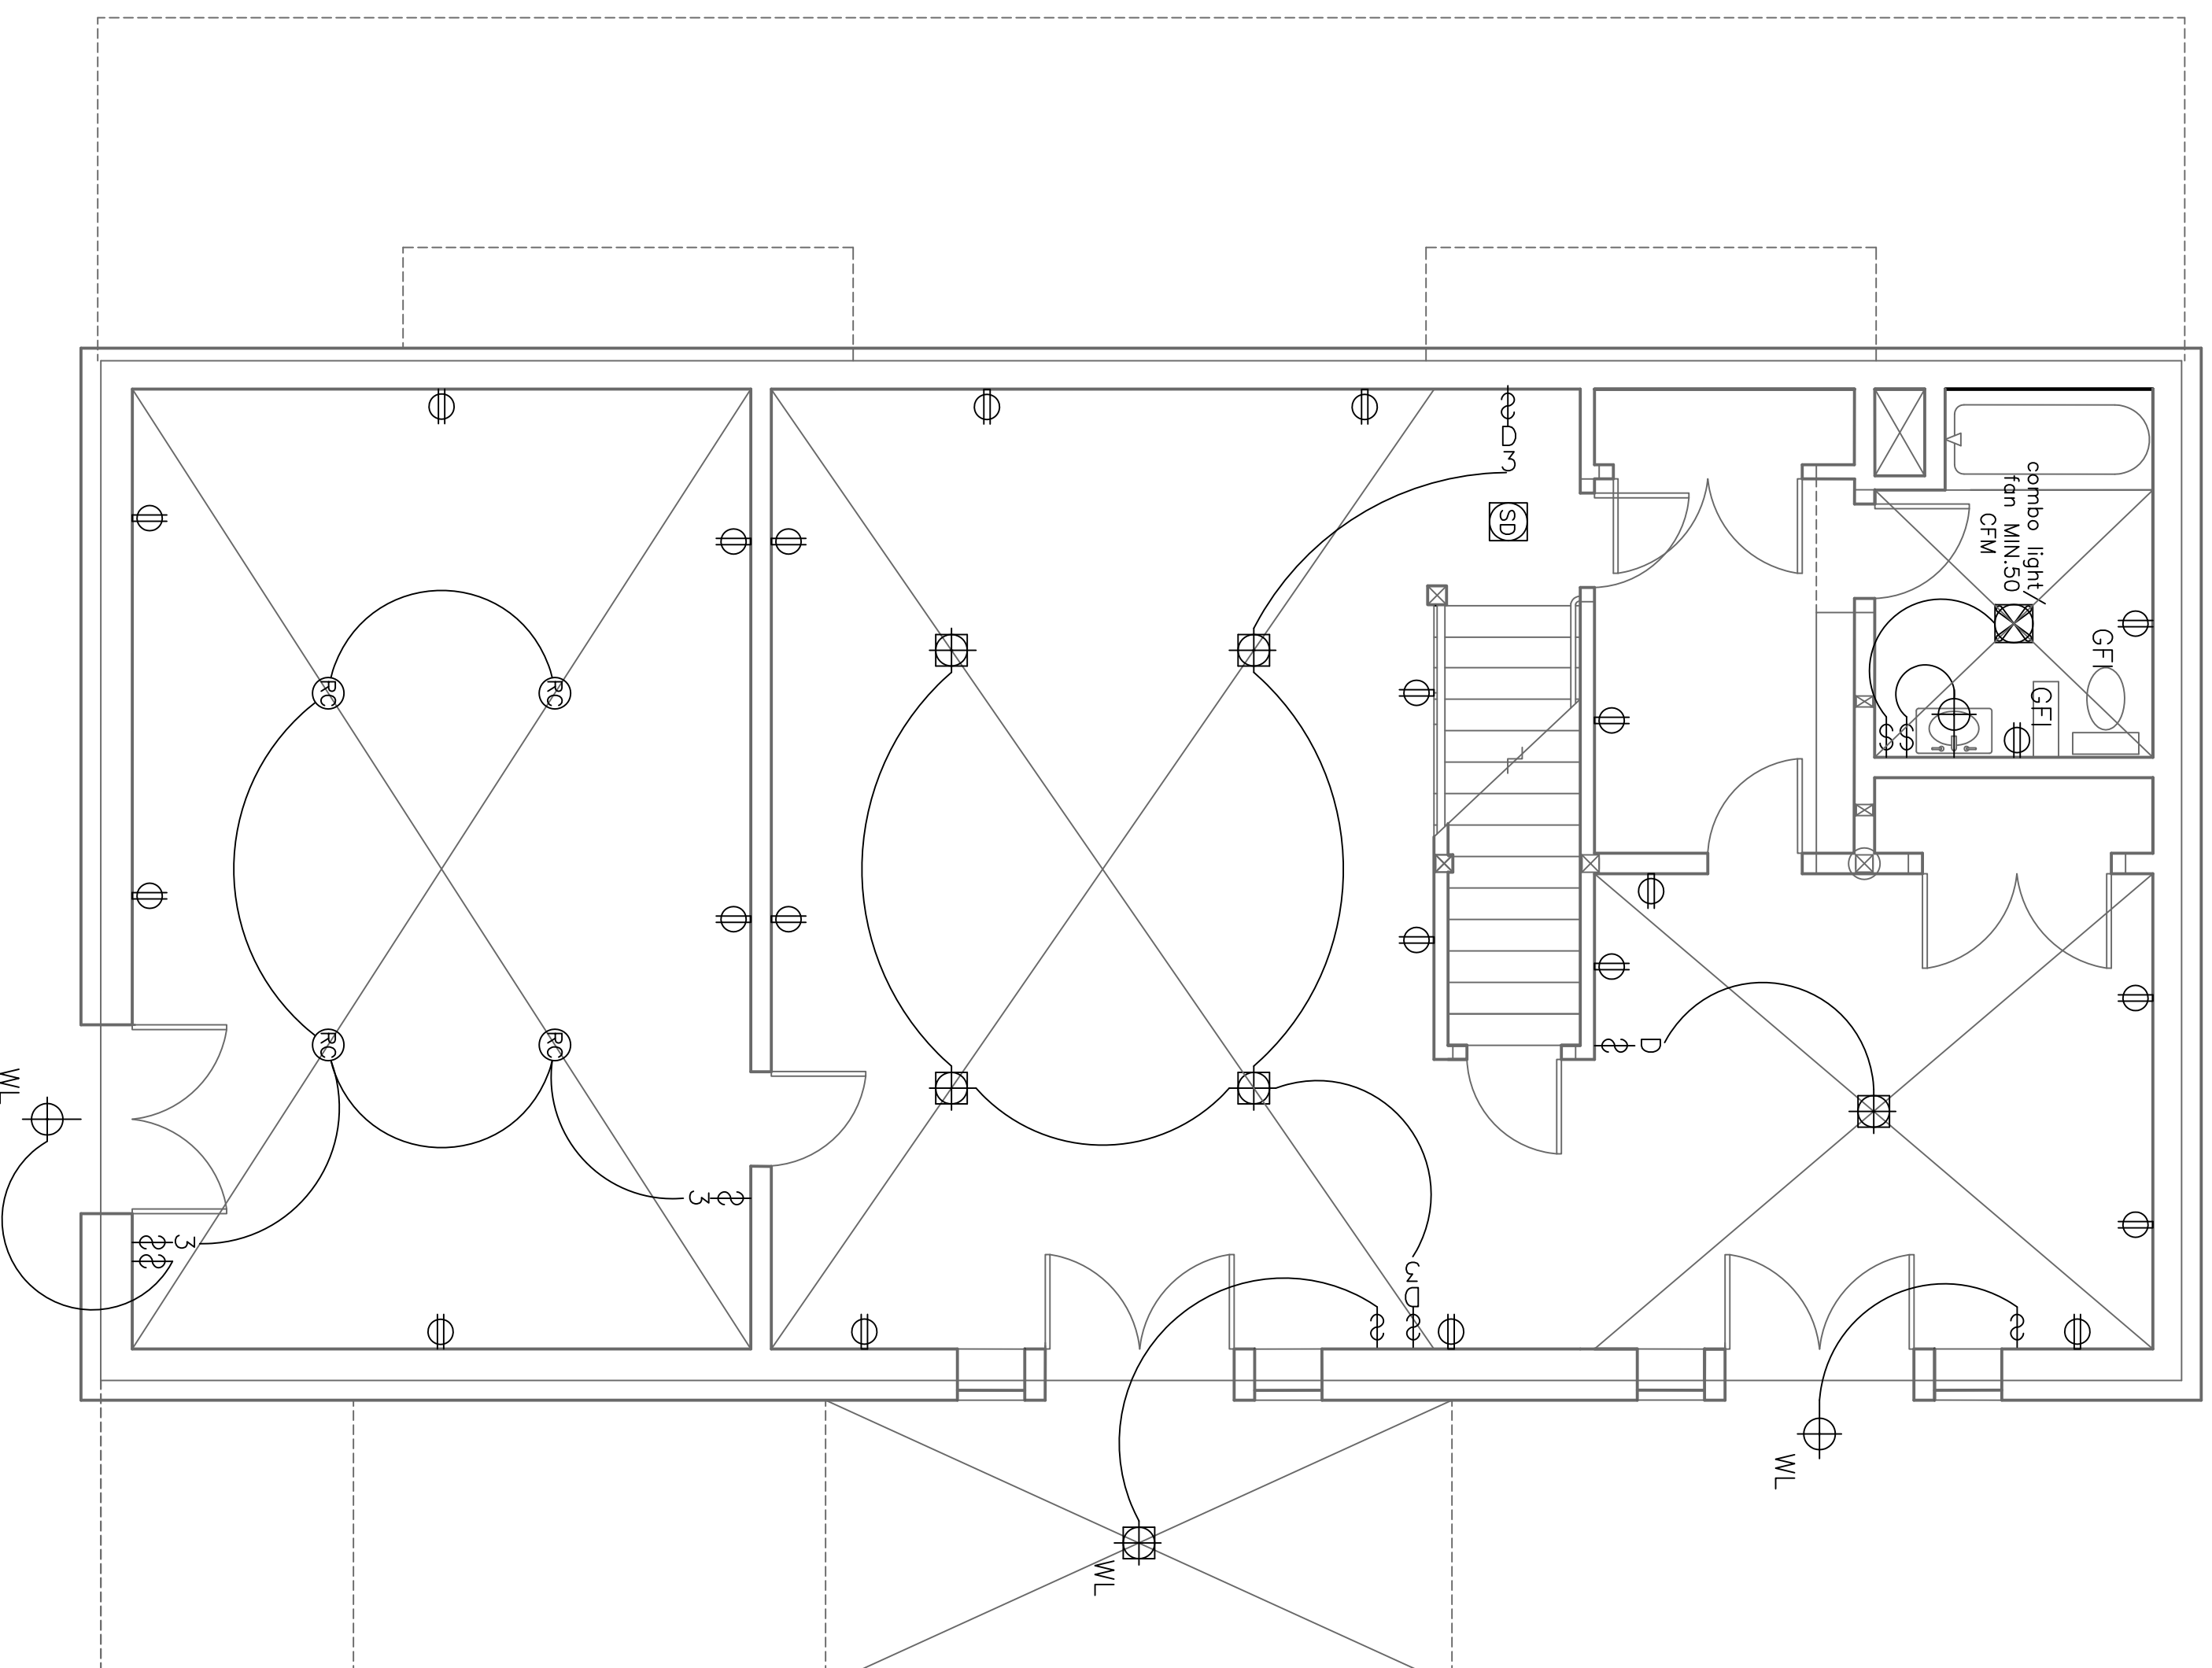

Basement Power
& Lighting Plan
A
1/4" = 1'-0"