

WALL MOUNT A/C UNIT SCHEDULE	
MANUFACTURER:	AIRSYS
MODEL #:	13E1C3-5K (4070132100)
DESCRIPTION:	VERTICAL WALL PACK UNIT (WPU) WITH INTEGRATED FREE COOLING.
SIZE:	39.76"W x 27.56"D x 83.86"H
# OF UNITS:	2
COOLING (BTU/HR):	41,900
POWER SUPPLY:	197VAC~264VAC/1Ø/60HZ
CIRCUIT BREAKER*:	40A HACR
* CONTRACTOR SHALL VERIFY BREAKER SIZES WITH MANUFACTURER'S SPECIFICATIONS	


**MECHANICAL NOTES:**

- CONTRACTOR SHALL INSTALL PER MANUFACTURER RECOMMENDATIONS AND SPECIFICATIONS.
- CONTRACTOR SHALL INSTALL THERMOSTATS, BOXES, SMOKE DETECTORS, TIME CLOCK, AND ASSOCIATED TO CONTROL AIR HANDLER OPERATIONS IN MAINTAINING REQUIRED VERIZON WIRELESS ROOM TEMPERATURE.
- HVAC UNIT WEIGHS 52ØLBS.
- CONTRACTOR TO ROUTE CONDENSATE AWAY FROM VERIZON WIRELESS SHELTER.
- CONTRACTOR TO REINFORCE WALL FRAMING TO SUPPORT THE HVAC UNIT PER MANUFACTURERS RECOMMENDATIONS.

**HVAC DETAIL**

SCALE: N.T.S.

1

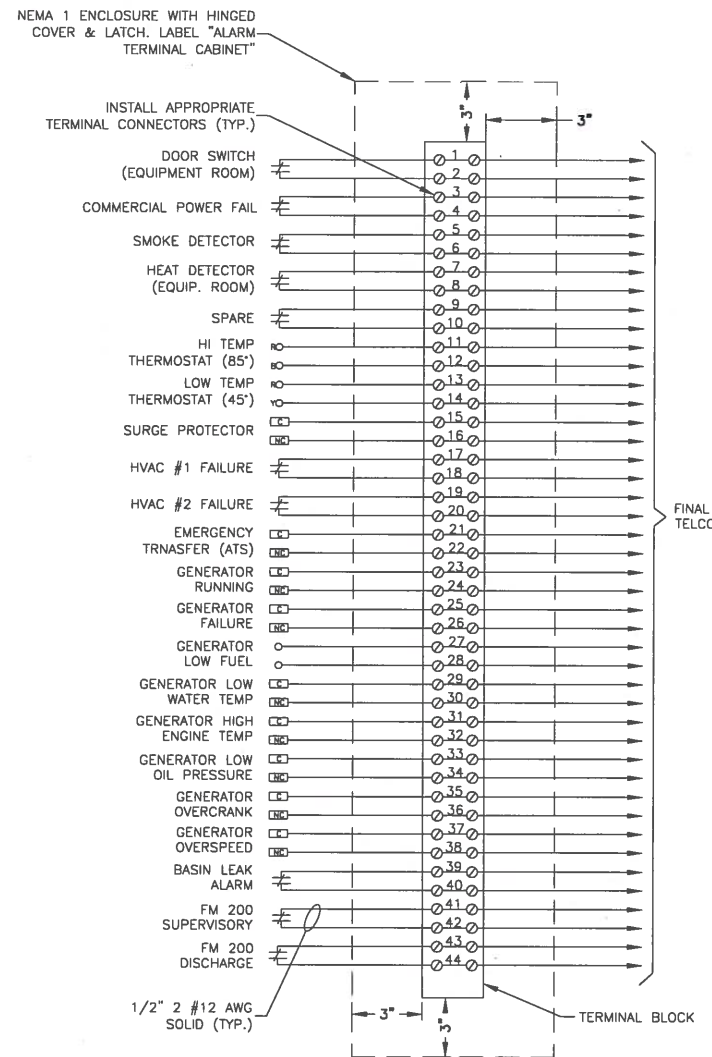

**NOTE:**

- CONTRACTOR TO PROVIDE TYPED DIRECTORY OF AS-BUILT PANEL.

**ALARM TERMINAL PLAN**

SCALE: N.T.S.

2



VERIZON WIRELESS  
400 FRIBERG PARKWAY  
WESTBOROUGH, MA 01581-3956

**PORTLAND 6 ME**

**CONSTRUCTION DRAWINGS**

NO.	DATE	DESCRIPTION
2	09/23/14	FOR SUBMITTAL
1	08/25/14	FOR SUBMITTAL
A	08/18/14	FOR COMMENT



Dewberry Engineers Inc.  
280 SUMMER STREET  
10TH FLOOR  
BOSTON, MA 02210  
PHONE: 617.885.3400  
FAX: 617.885.3310



DRAWN BY:	MR
REVIEWED BY:	MFT
CHECKED BY:	BBR
PROJECT NUMBER:	50002925
JOB NUMBER:	50062235
SITE ADDRESS:	

25 CHURCH AVE  
PEAKS ISLAND, ME 04108

SHEET TITLE

MECHANICAL DETAILS

SHEET NUMBER

M-1