


LIGHT FIXTURE LEGEND (SEE ALSO ELECTRICAL DWGS.)


- 2'x2' RECESSED FLUORESCENT LIGHT FIXTURE
- 1'x4' RECESSED FLUORESCENT LIGHT FIXTURE
- WALL SCONCE
- RECESSED DOWN LIGHT
- 6"x4" SURFACE MOUNTED LIGHT FIXTURE
- SURFACE MOUNTED LIGHT FIXTURE
- WALL MOUNTED LIGHT FIXTURE
- EXTERIOR WALL MOUNTED LIGHT FIXTURE
- 8" RECESSED PARABOLIC LIGHT FIXTURE
- CEILING HEAT LAMP/LIGHT FIXTURE

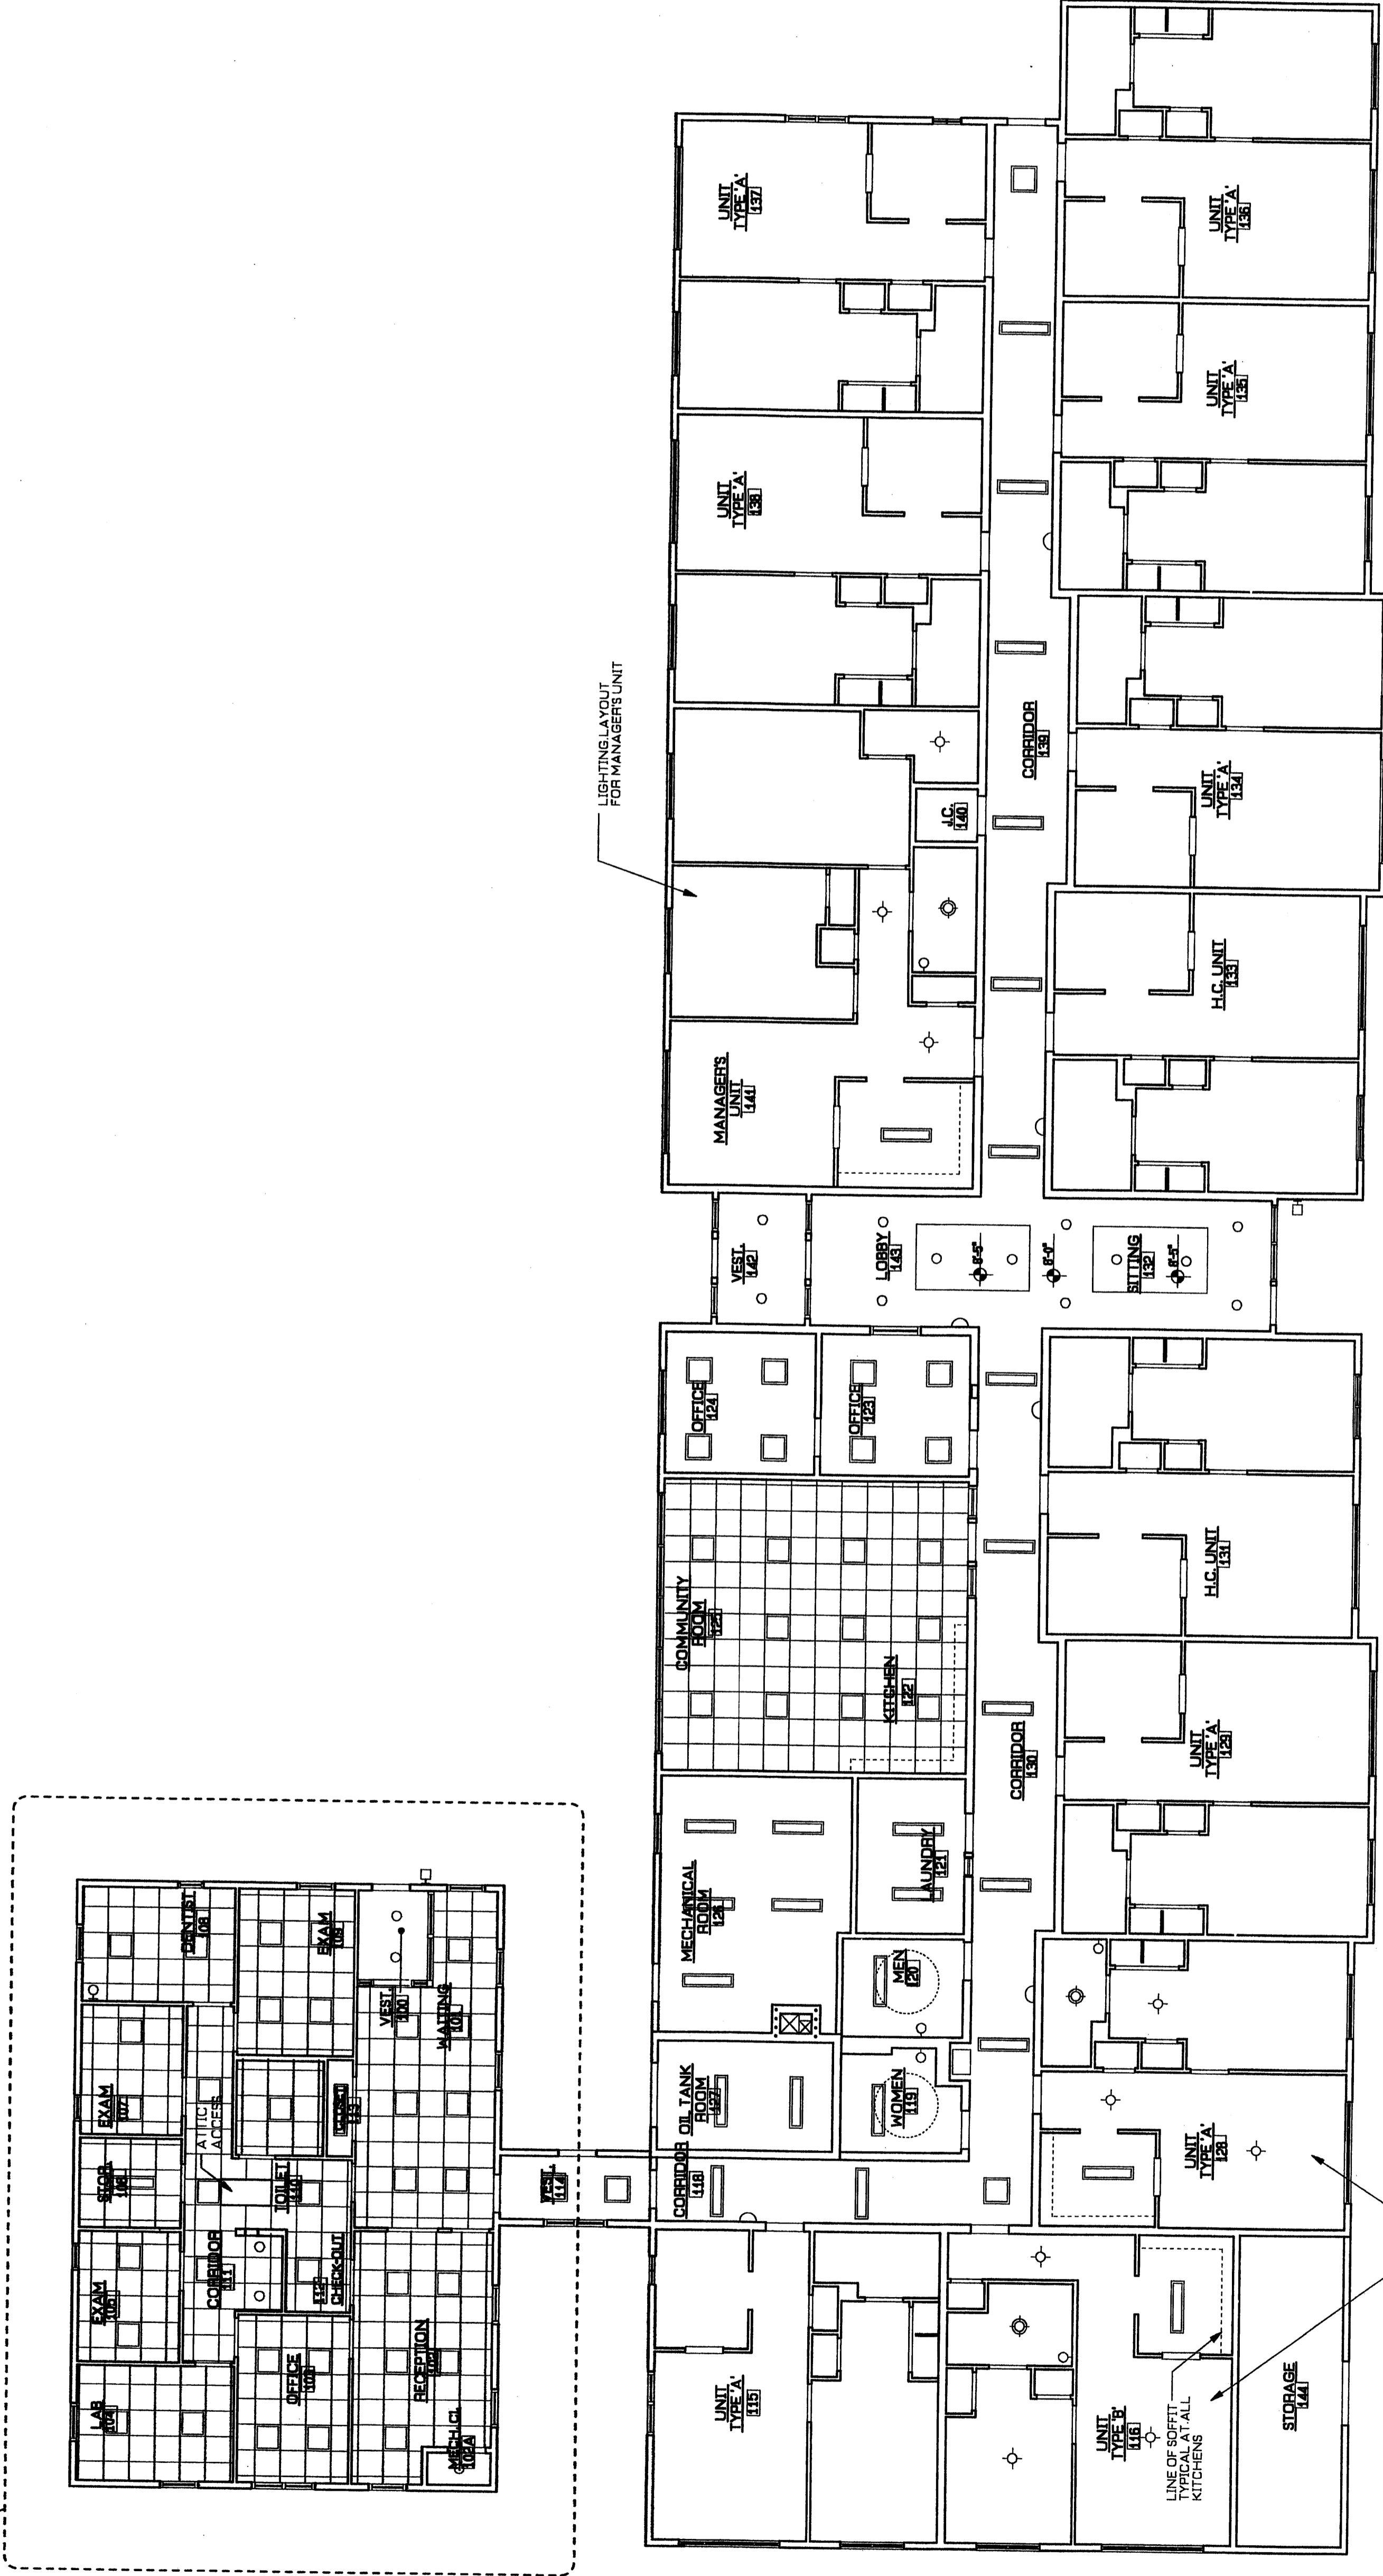

HEALTH CENTER UNIT  
NOT IN HUD CONTRACT

LIGHTING LAYOUT  
FOR MANAGER'S UNIT

TYPICAL LIGHTING LAYOUT  
FOR UNIT TYPE A AND  
H.C. UNIT (S.M.)

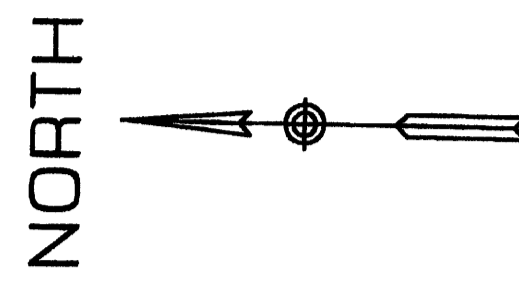

Revisions	No.	Date

Project:  
**PEAKS ISLAND V.O.A.  
 SENIOR HOUSING FACILITY  
 & HEALTH CENTER**  
 H.U.D. Project # 024-EE058  
 Central Avenue  
 Peaks Island, Maine

Drawing Title:  
**FIRST FLOOR  
 REFLECTED CEILING  
 PLAN**

Tsomides  
 Associates  
 Architects  
 Planners  
 Echo Bridge Office Park  
 388 Elliot Street  
 Newton Upper Falls, MA 02464  
 617.969-4774  
 Fax 617.969-4793  
 WWW.TSOMIDES.COM

DRAWN BY: DP  
 DATE ISSUED: 02/23/04  
 SCALE: 1/8" = 1'-0" OR AS NOTED  
 DRAWING NUMBER:  
**A-300**

FIRST FLOOR REFLECTED CEILING PLAN  
 SCALE 1/8" = 1'-0" (11 1 BRM UNITS 1 MANAGER'S UNIT)