



FIXTURE SCHEDULE					
ITEM	FIXTURE	WASTE	VENT	COLD WATER	HOT WATER
P-1	APARTMENT TOILET	3"	2"	1/2"	1/2"
P-1A	H.C. TOILET	3"	2"	1"	
P-1B	PUBLIC TOILET	3"	2"	1"	
P-2	APARTMENT LAVATORY	2"	1-1/2"	1/2"	1/2"
P-2A	H.C. LAVATORY	2"	1-1/2"	1/2"	1/2"
P-3	APARTMENT SHOWER UNIT	2"	1-1/2"	1/2"	1/2"
P-3A	H.C. SHOWER UNIT	2"	1-1/2"	1/2"	1/2"
P-4	APARTMENT KITCHEN SINK	2"	1-1/2"	1/2"	1/2"
P-4A	H.C. KITCHEN SINK	2"	1-1/2"	1/2"	1/2"
P-5	URINAL	2"	1-1/2"	1/2"	1/2"
P-6	DRINKING FOUNTAIN	1-1/2"	1-1/2"	1/2"	1/2"
P-7	COMMUNITY RM KITCHEN SINK	1-1/2"	1-1/2"	1/2"	1/2"
P-8	TUB/SHOWER MANAGERS APT	1-1/2"	1-1/2"	1/2"	1/2"
P-9	MOP SINK	3"	1-1/2"	1/2"	1/2"
P-10	WASHING MACHINE BOX	2"	1-1/2"	1/2"	1/2"
P-11	HEALTH CARE EXAM SINK	2"	1-1/2"	1/2"	1/2"


PIPING LEGEND	
SYMBOL	DEFINITION
M	GATE VALVE
X	BALL VALVE
⊥	BUTTERFLY VALVE
⊘	BALANCING VALVE
∩	STAINER
⊕	UNION
⊔	THERMOMETER
⊙	PRESSURE GAUGE
⊖	PIPE RISE
⊖	PIPE DROP
→	DIRECTION OF FLOW
HWR	HOT WATER RECIRCULATION
HW	HOT WATER
CW	COLD WATER
—	CAP
HB#	HOSE BIB

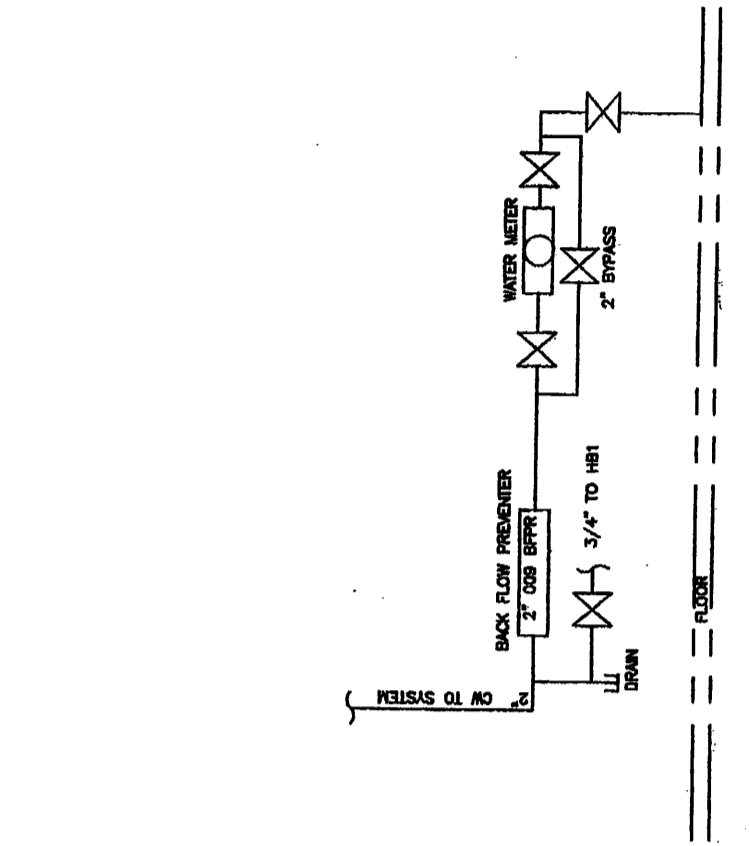

1 WATER METER DETAIL
N.T.S.

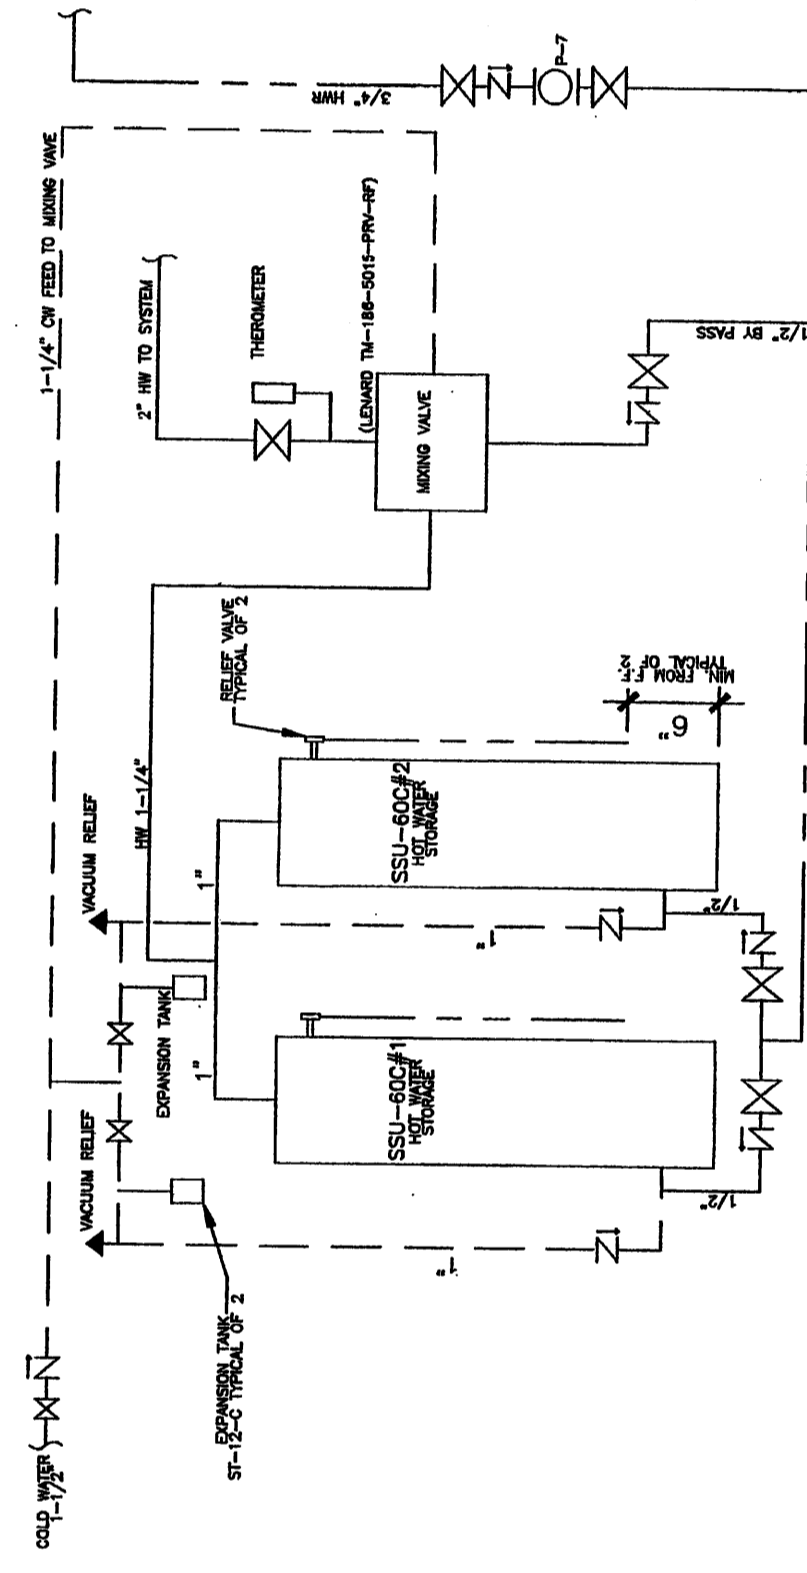

1 MIXING VALVE & STORAGE TANK DETAIL
N.T.S.

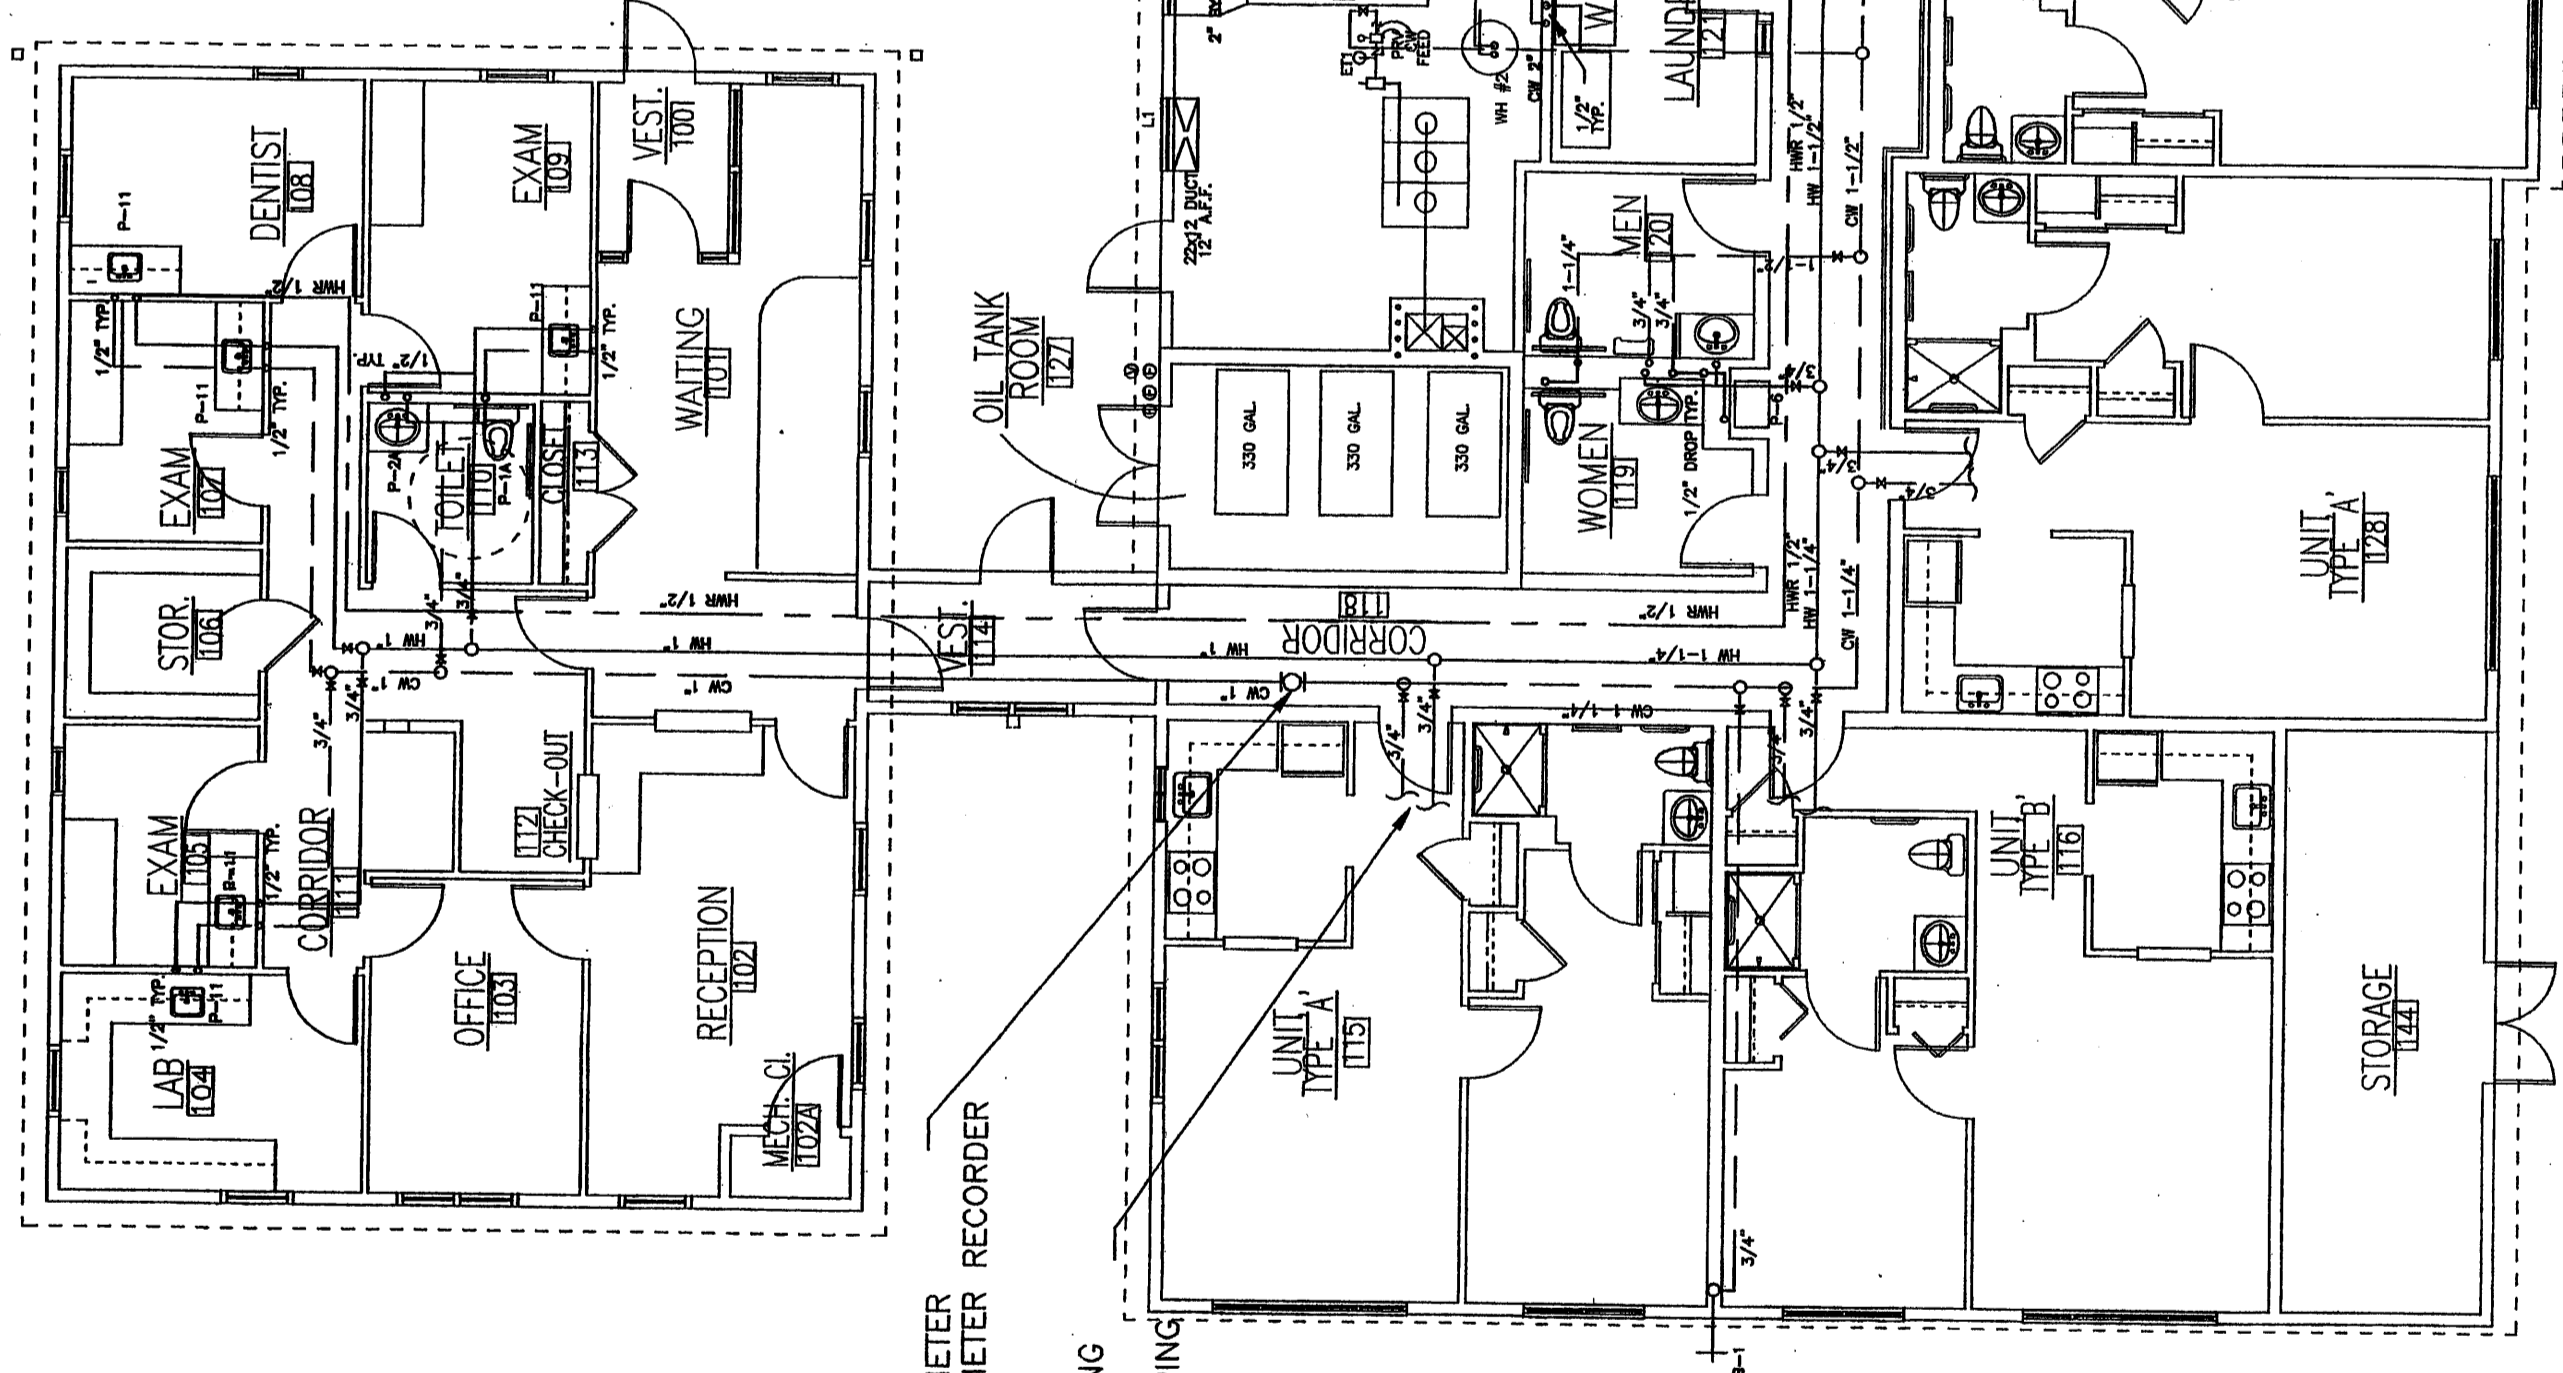


NOTE:
1. HEALTH CARE SUB METER
2. HEALTH CARE SUB METER RECORDER
BY OTHERS
NOTE:
1. 3/4" HOT AND COLD WATER PIPING
TYPICAL FOR ALL APARTMENTS
2. 1/2" HOT AND COLD WATER PIPING
DROPS TYPICAL

NOTE:
1. 3/4" HOT AND COLD WATER PIPING
TYPICAL FOR ALL APARTMENTS
2. 1/2" HOT AND COLD WATER PIPING
DROPS TYPICAL

NOTE:
1. 3/4" HOT AND COLD WATER PIPING
TYPICAL FOR ALL APARTMENTS
2. 1/2" HOT AND COLD WATER PIPING
DROPS TYPICAL

NOTE:
1. 3/4" HOT AND COLD WATER PIPING
TYPICAL FOR ALL APARTMENTS
2. 1/2" HOT AND COLD WATER PIPING
DROPS TYPICAL

1 FIRST FLOOR PLAN
1/8" = 1'-0"

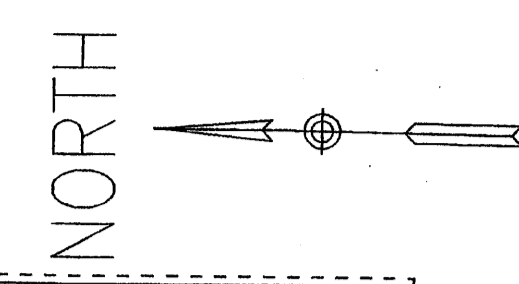

Revisions: No. Date

Project: PEAKS ISLAND V.O.A. SENIOR HOUSING FACILITY & HEALTH CENTER H.U.D. Project # 024-EE058
Central Avenue
Peaks Island, Maine

Drawing Title: FIRST FLOOR WATER PIPING PLAN

Edno Pringle, Office Park
188 Main Street
Newton Upper Falls, MA 02464

Tsomides Associates Architects Planners
517.988-4774
Fax: 517.989-488
WWW.TSOMIDES.COM

Drawn By: FMC/ZJR
Date Issued: 2/20/04
Scale: 1/8" = 1'-0"
Drawing Number: P-2

THE CERBERUS CO. PLUMBING MECHANICAL
PLUMBING CONTRACTORS
12071 197-0600

