


LIGHT FIXTURE LEGEND
 1- WALL LIGHT (BEGA 3825 LED WALL LIGHT)
 11- PATH LIGHT (BK LIGHT-STICK)

Soren deNiord Design Studio
 43 Wellwood Road
 Portland, ME
 04103
 T: 207-400-2450
 E: soren@sorendeniord.com

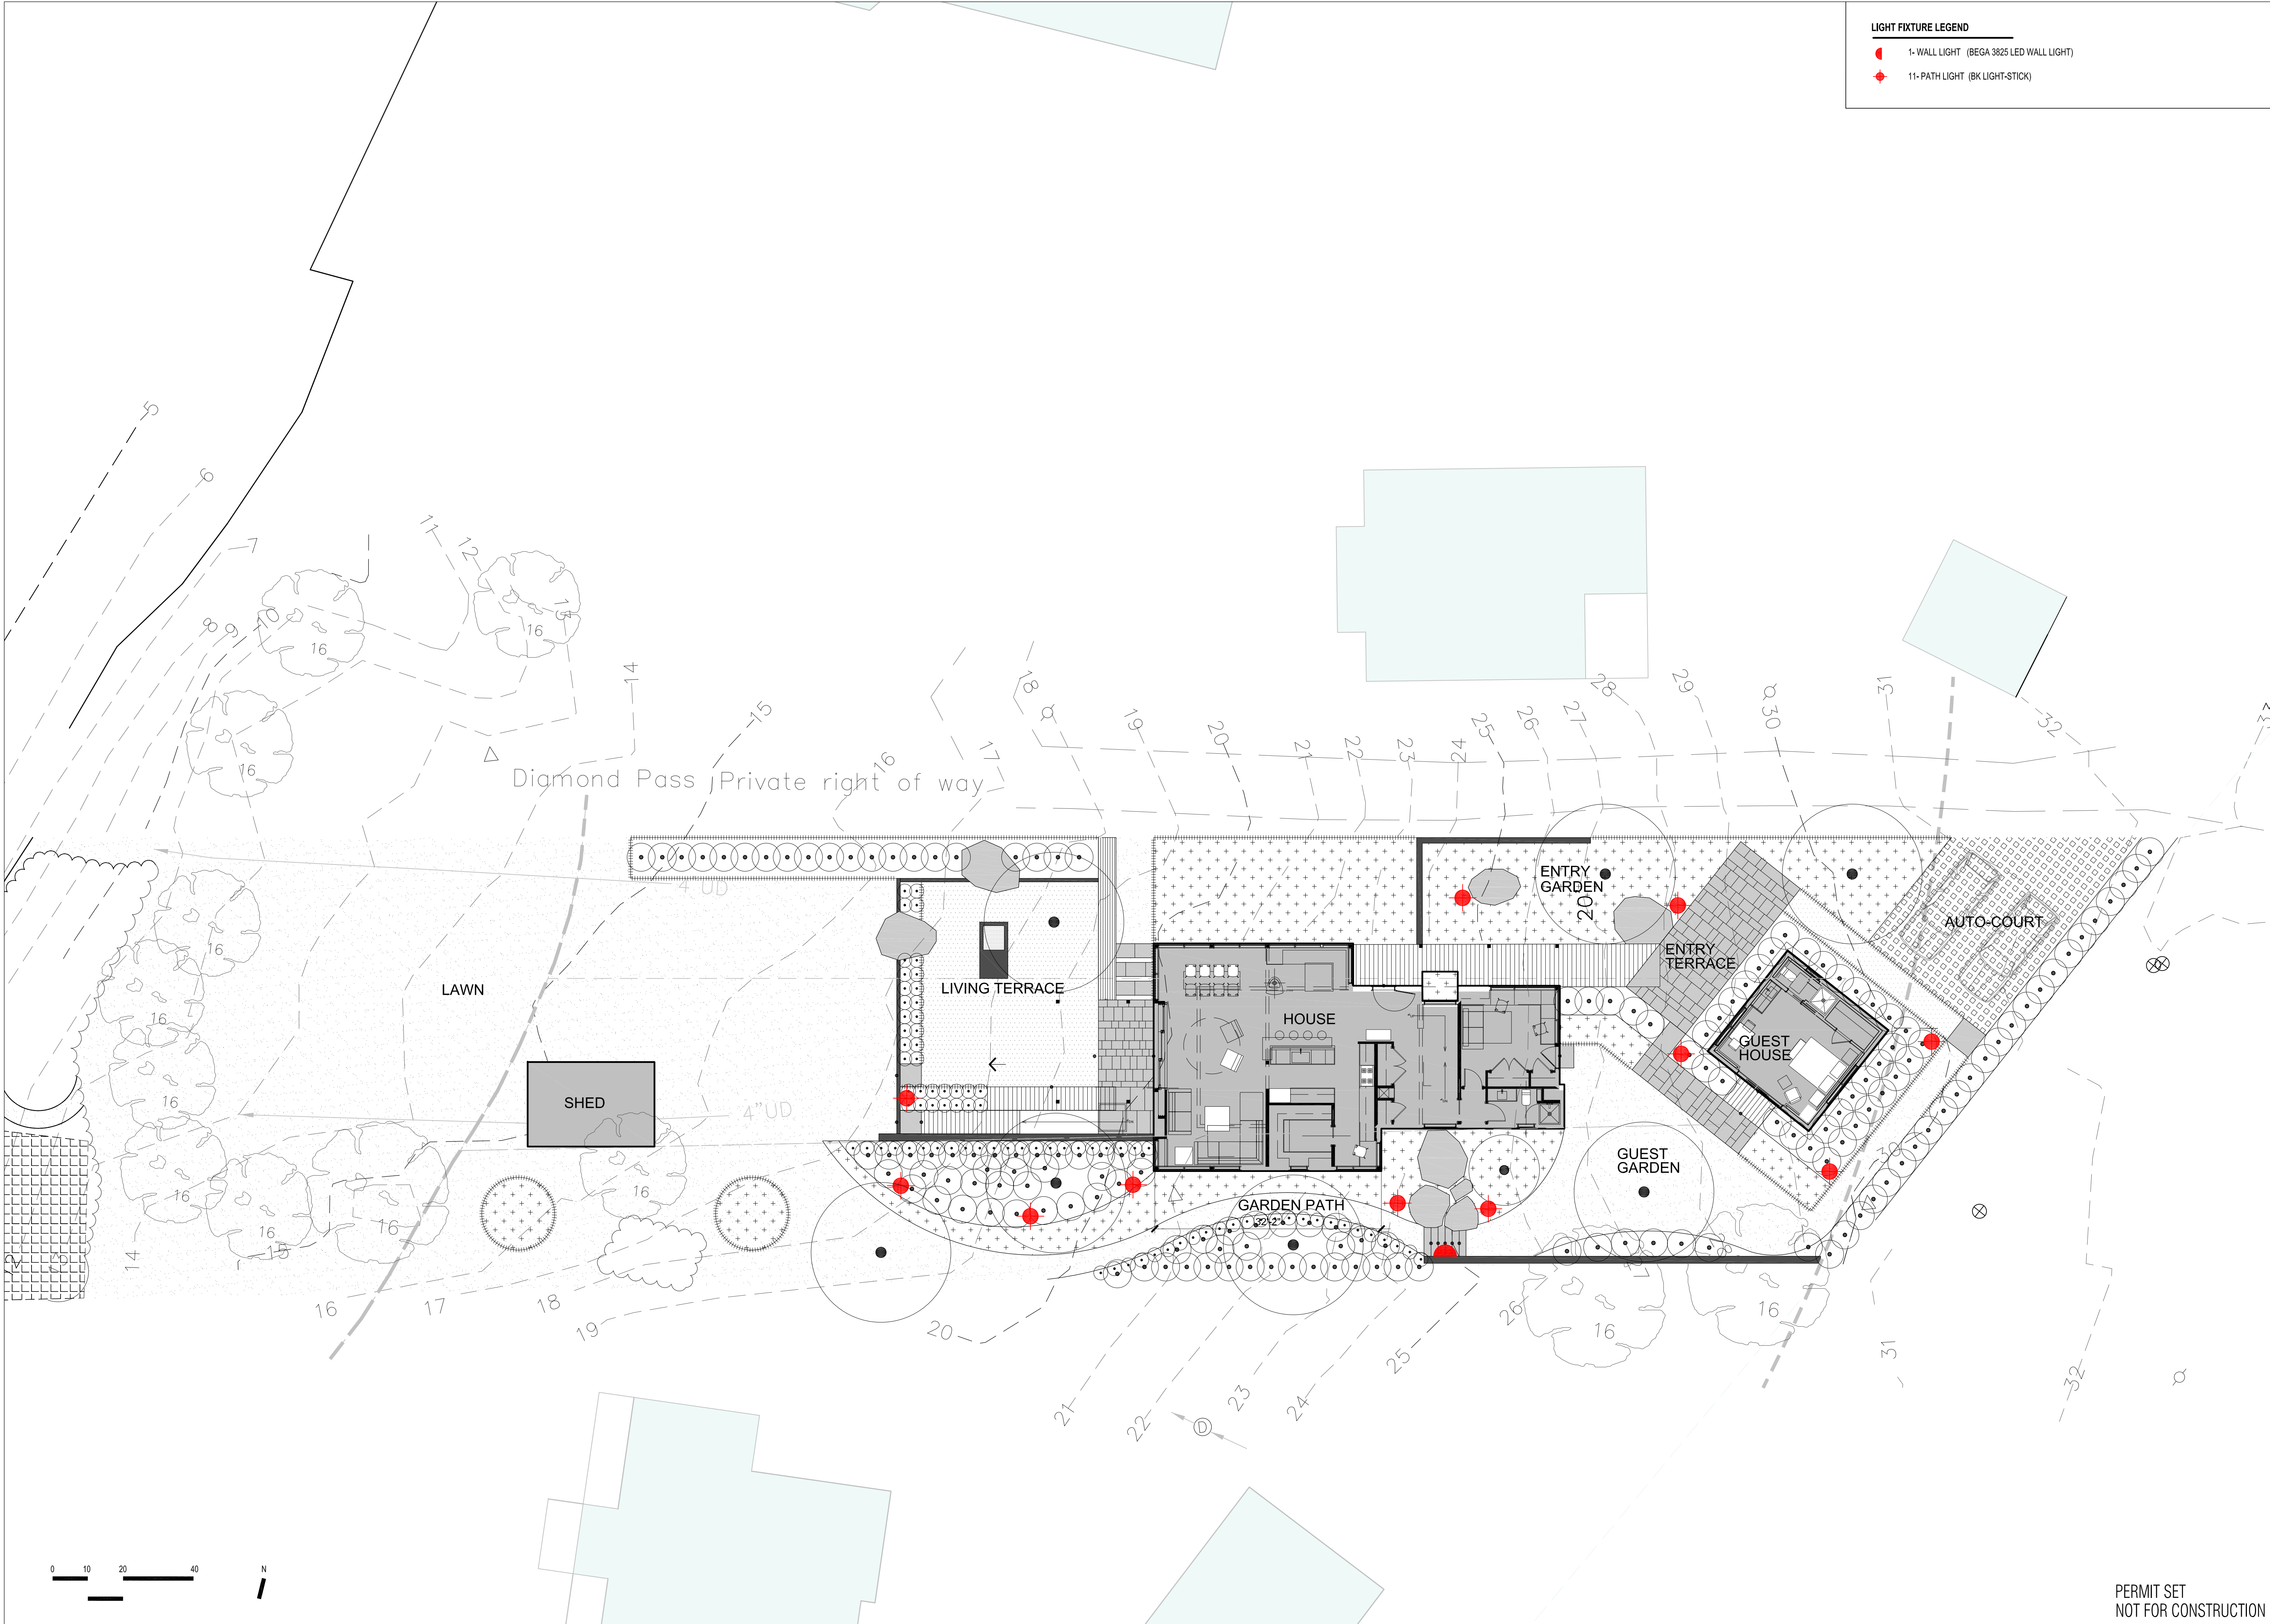

SPIRN GULLIVER RESIDENCE
 BARTRAM ROAD
 PEAKS ISLAND, MAINE

Revision: _____ Date: _____
 ▲
 ▲
 ▲
 ▲
 ▲
 revisions:
 date: JUNE 15, 2017
 scale: As Noted
 drawn: XX
 checked: XX

L4.1
 LANDSCAPE
 LIGHTING PLAN

PERMIT SET
 NOT FOR CONSTRUCTION