

Rachel Conly
Architectural Design

26 Sterling Street
Peaks Island, Maine 04108
207.766.5625

**Proposed Third
Floor Power Plan**

PROJECT
Branson Residence

5 Beach Road
Peaks Island, Me.
04108


DATE 11.12.13

REVISED

SCALE 1/4" = 1'-0"

DRAWN BY
Rachel

NOTES

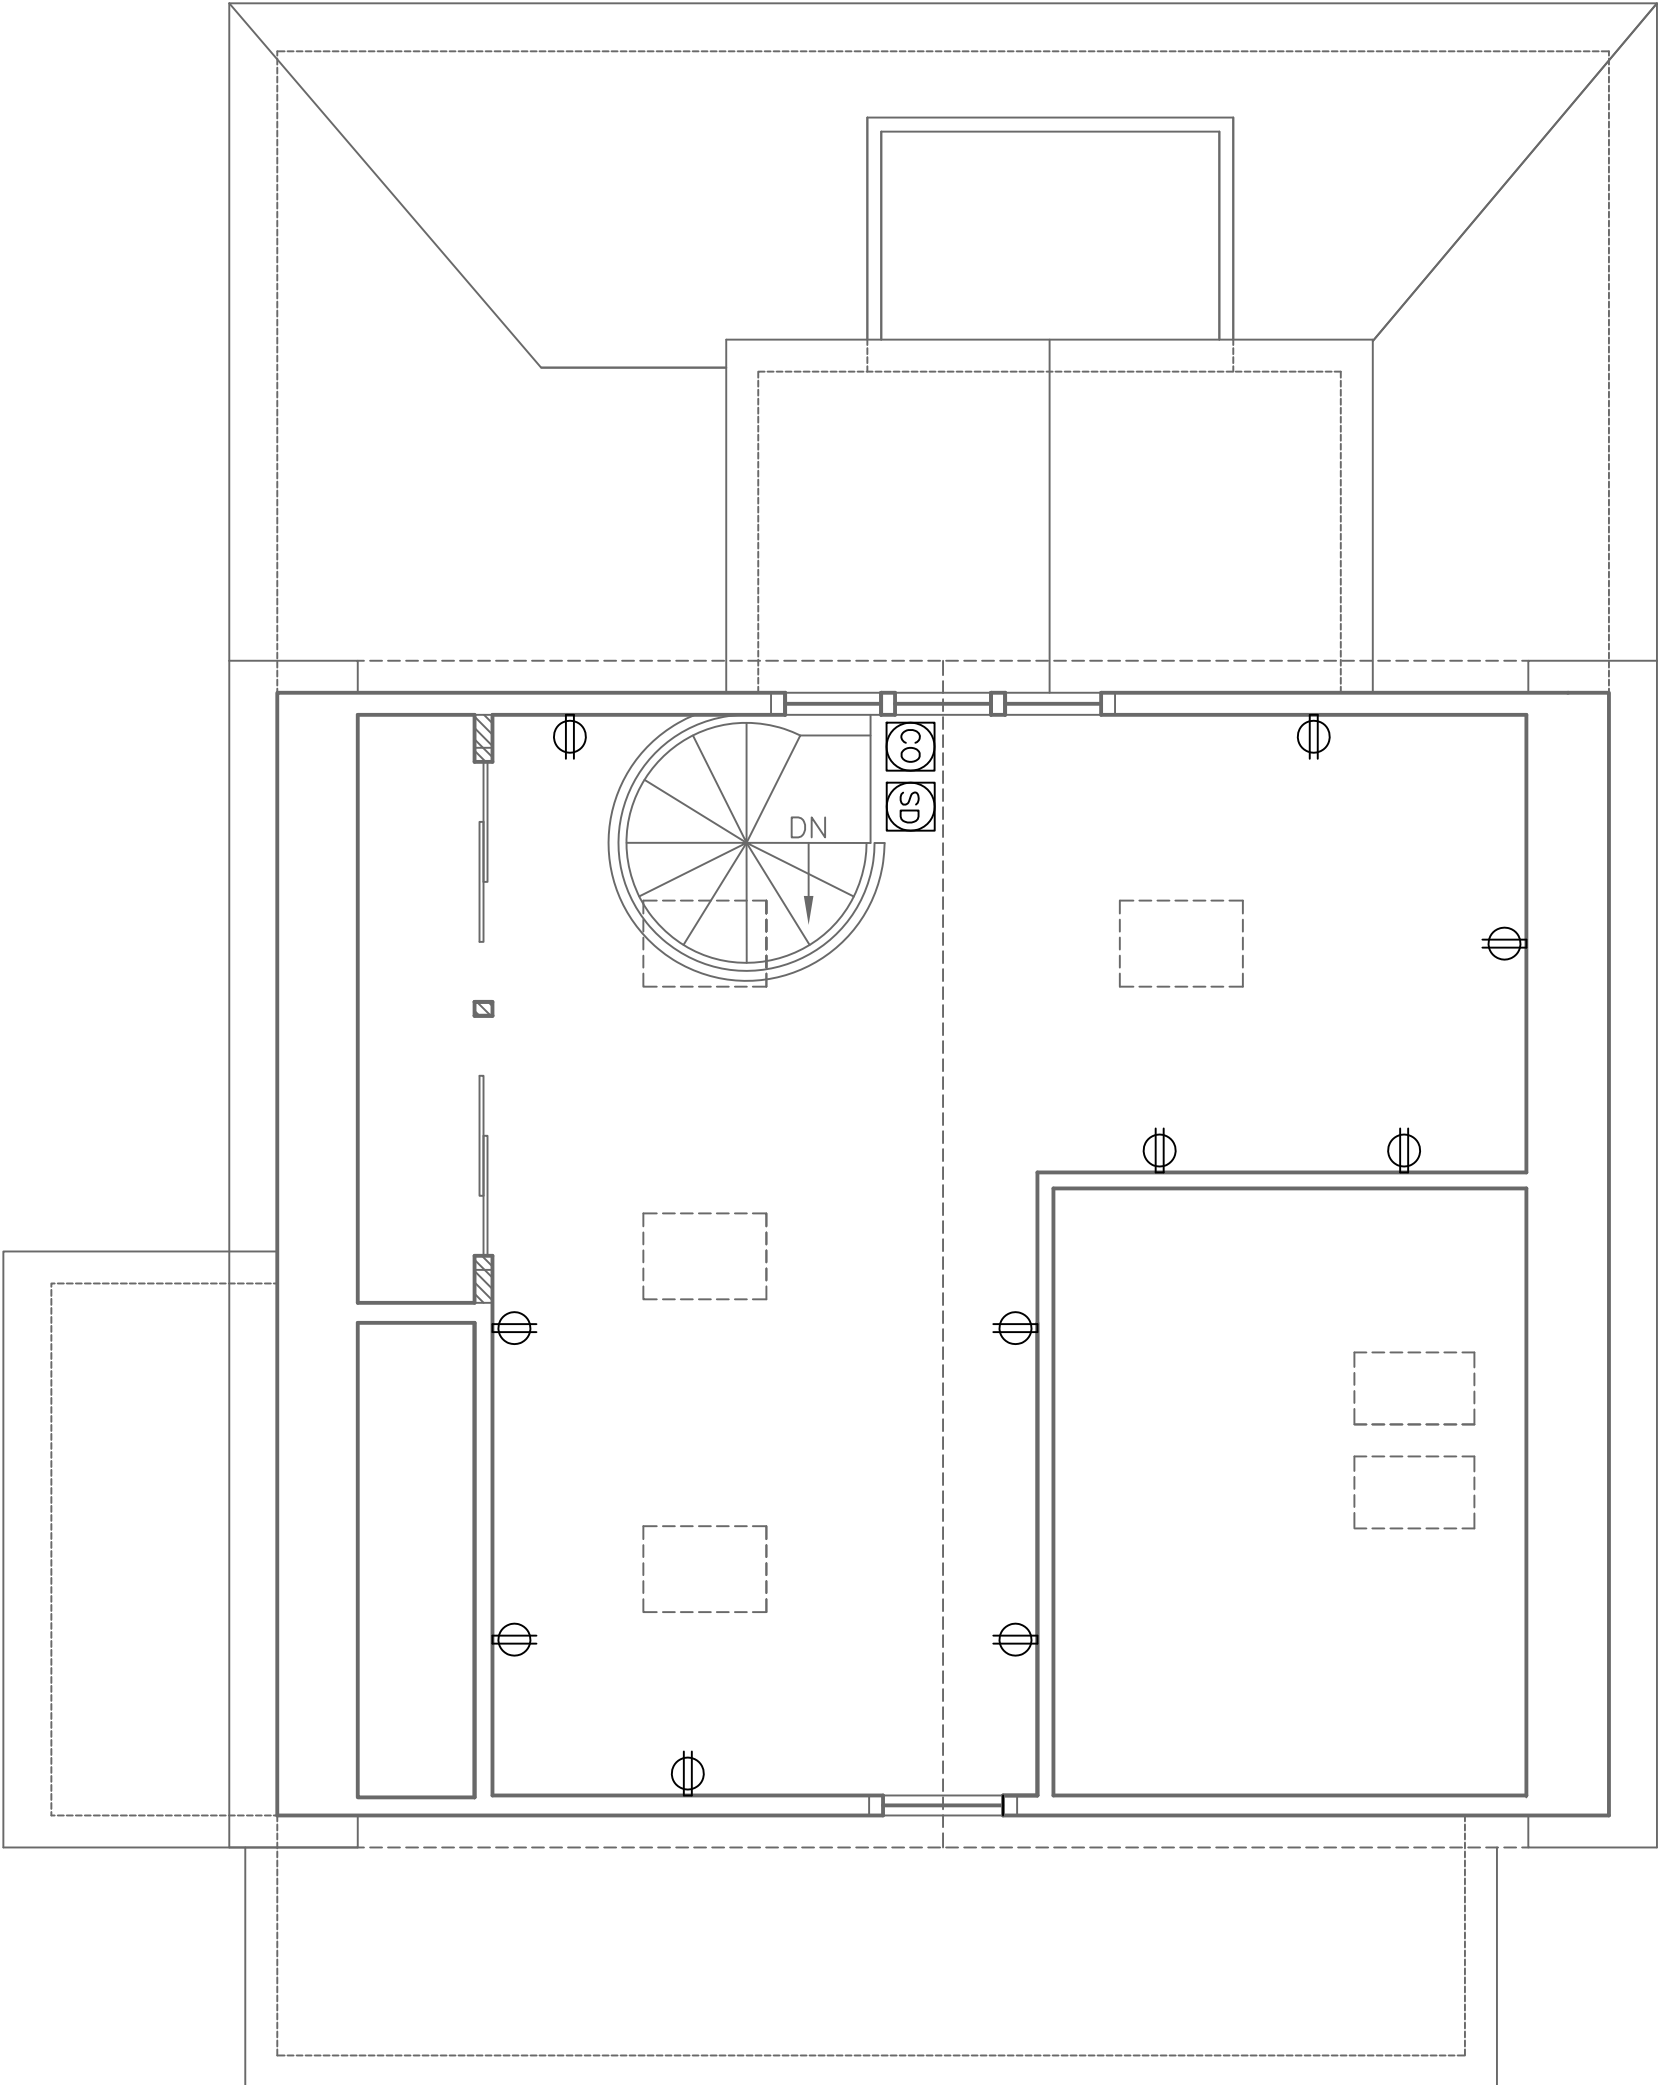

Proposed Third Floor Power Plan
1/4" = 1'-0"

A