


**Rachel Conly**  
Architectural Design  
26 Sterling Street  
Peaks Island, Maine 04108  
207.766.5625

Proposed Third  
Floor Power Plan

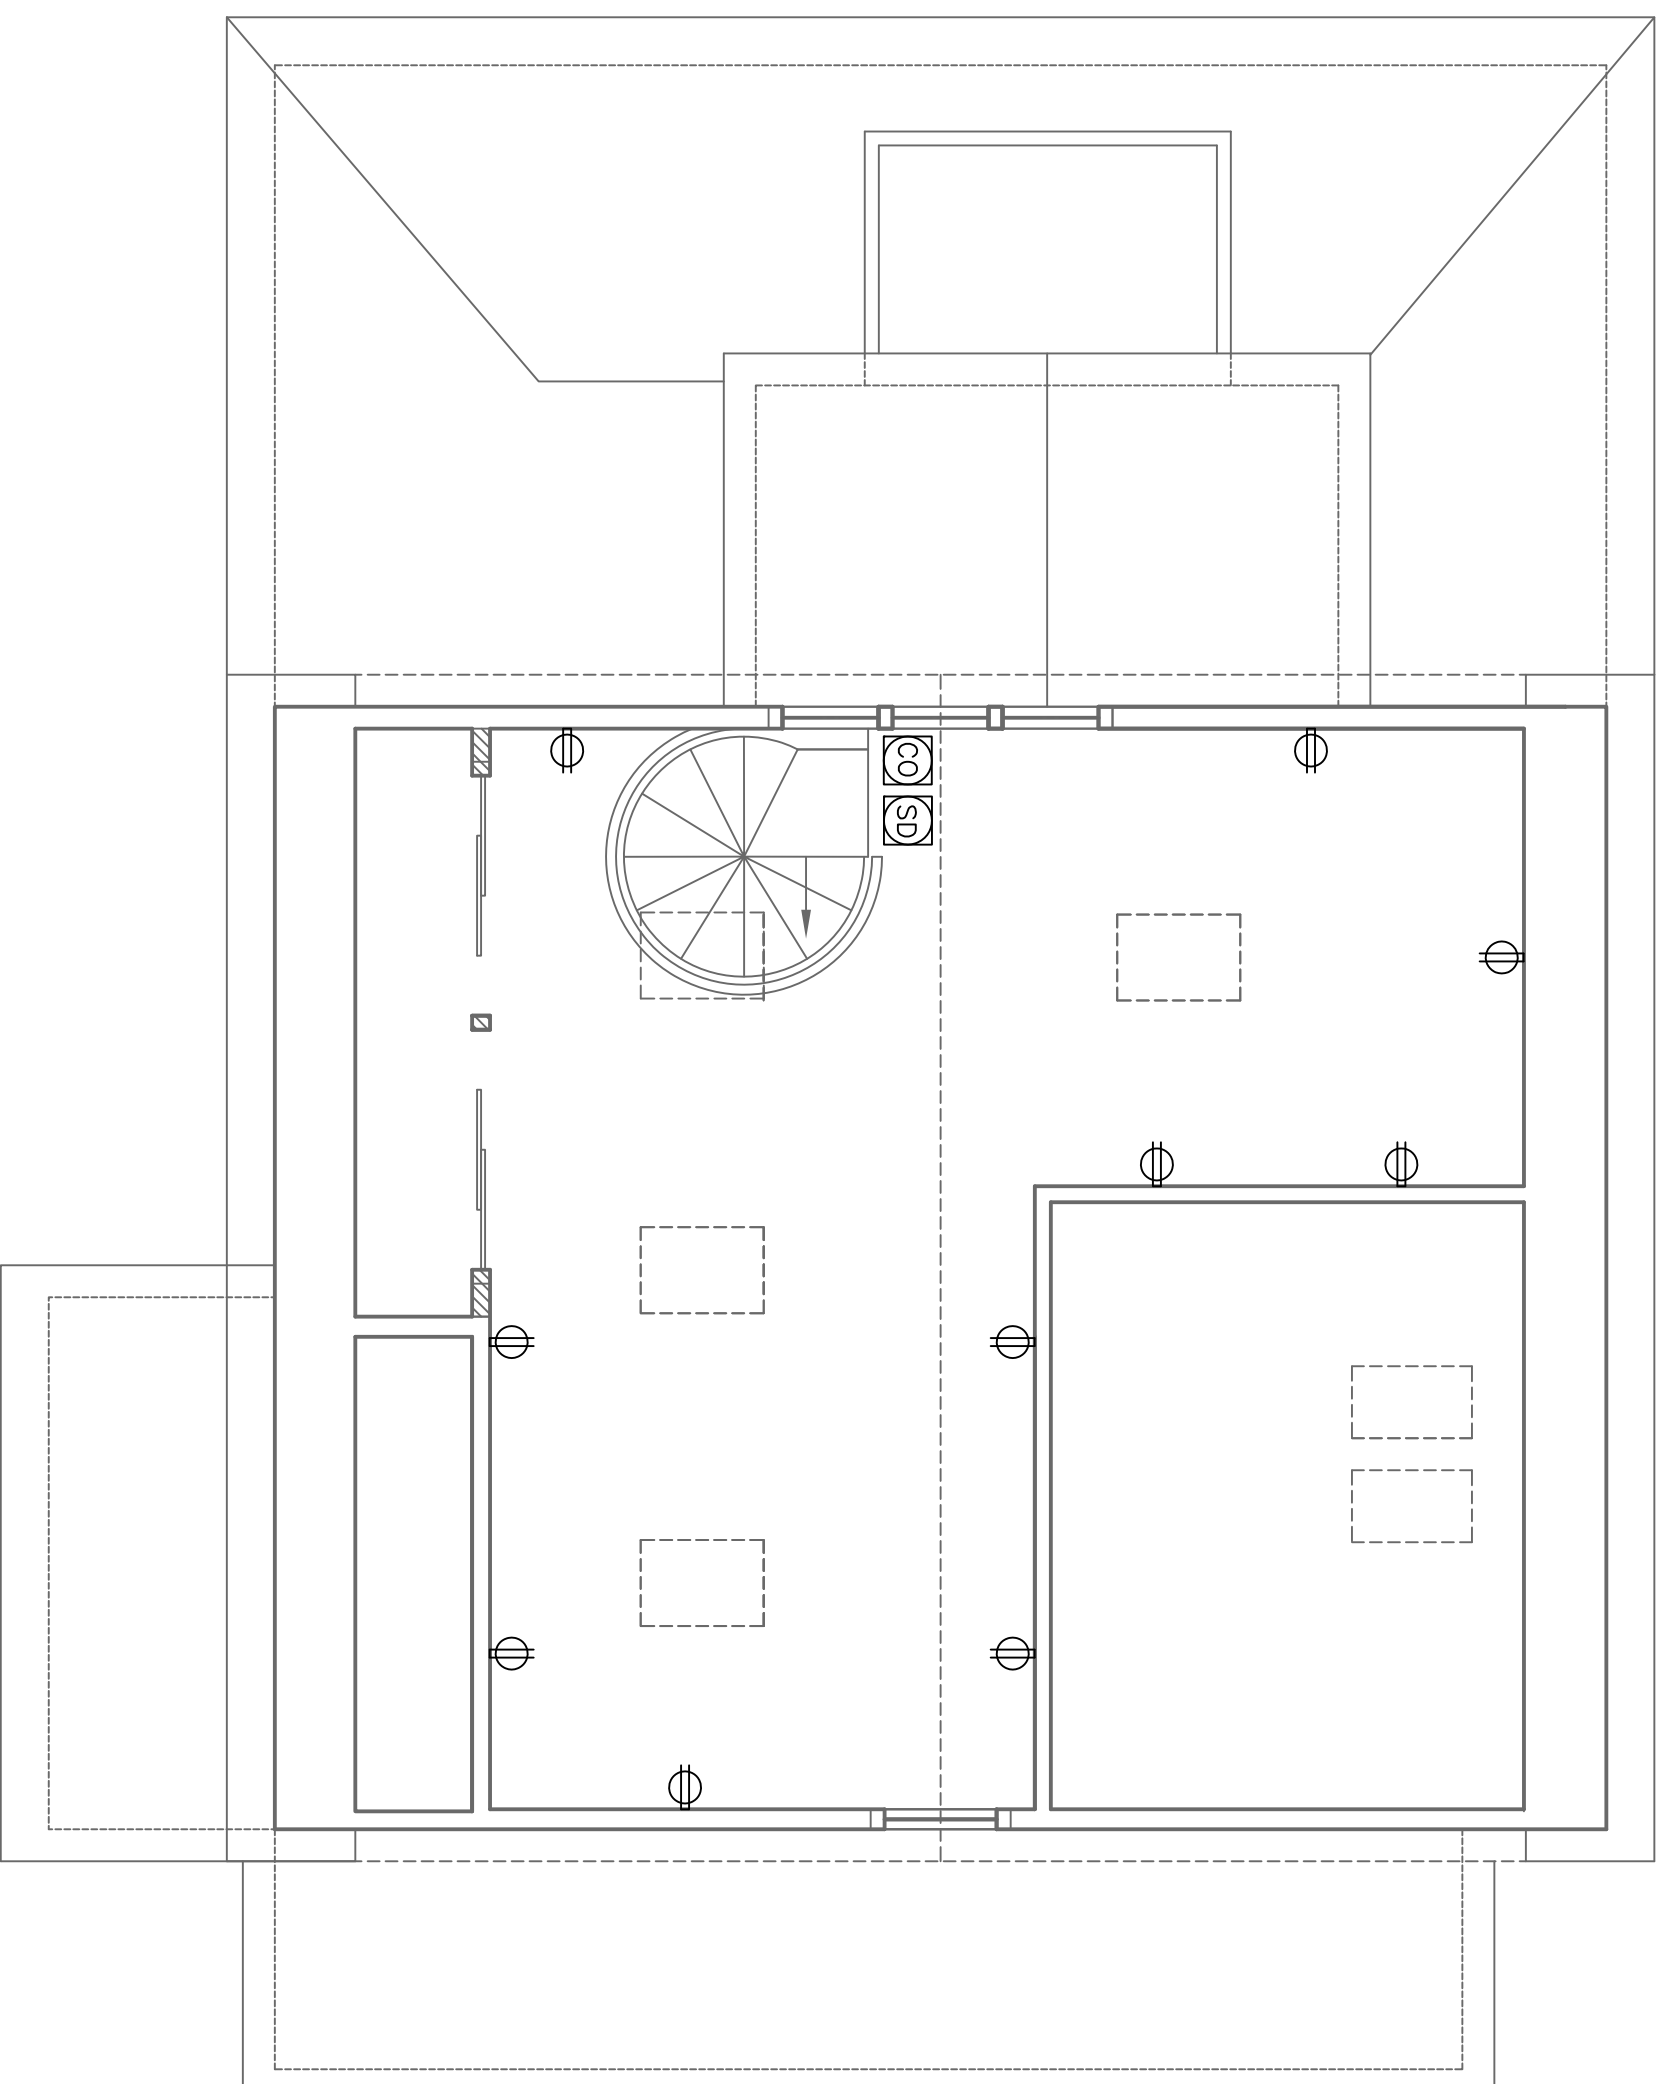

PROJECT  
**Branson Residence**  
5 Beach Road  
Peaks Island, Me.  
04108

DATE	REVISED
5.9.14	

SCALE  
1/4" = 1' - 0"

NOTES

DRAWN BY
Rachel

Proposed Third Floor Power Plan  
1/4" = 1' - 0"

A