



DATE	DESCRIPTION

DATE: BUILDING PERMIT APPN. 4-21-16  
 CHECKED BY: JAD  
 DRAWN BY: JR  
 JOB:   
 SHEET TITLE: ELECTRICAL PLANS

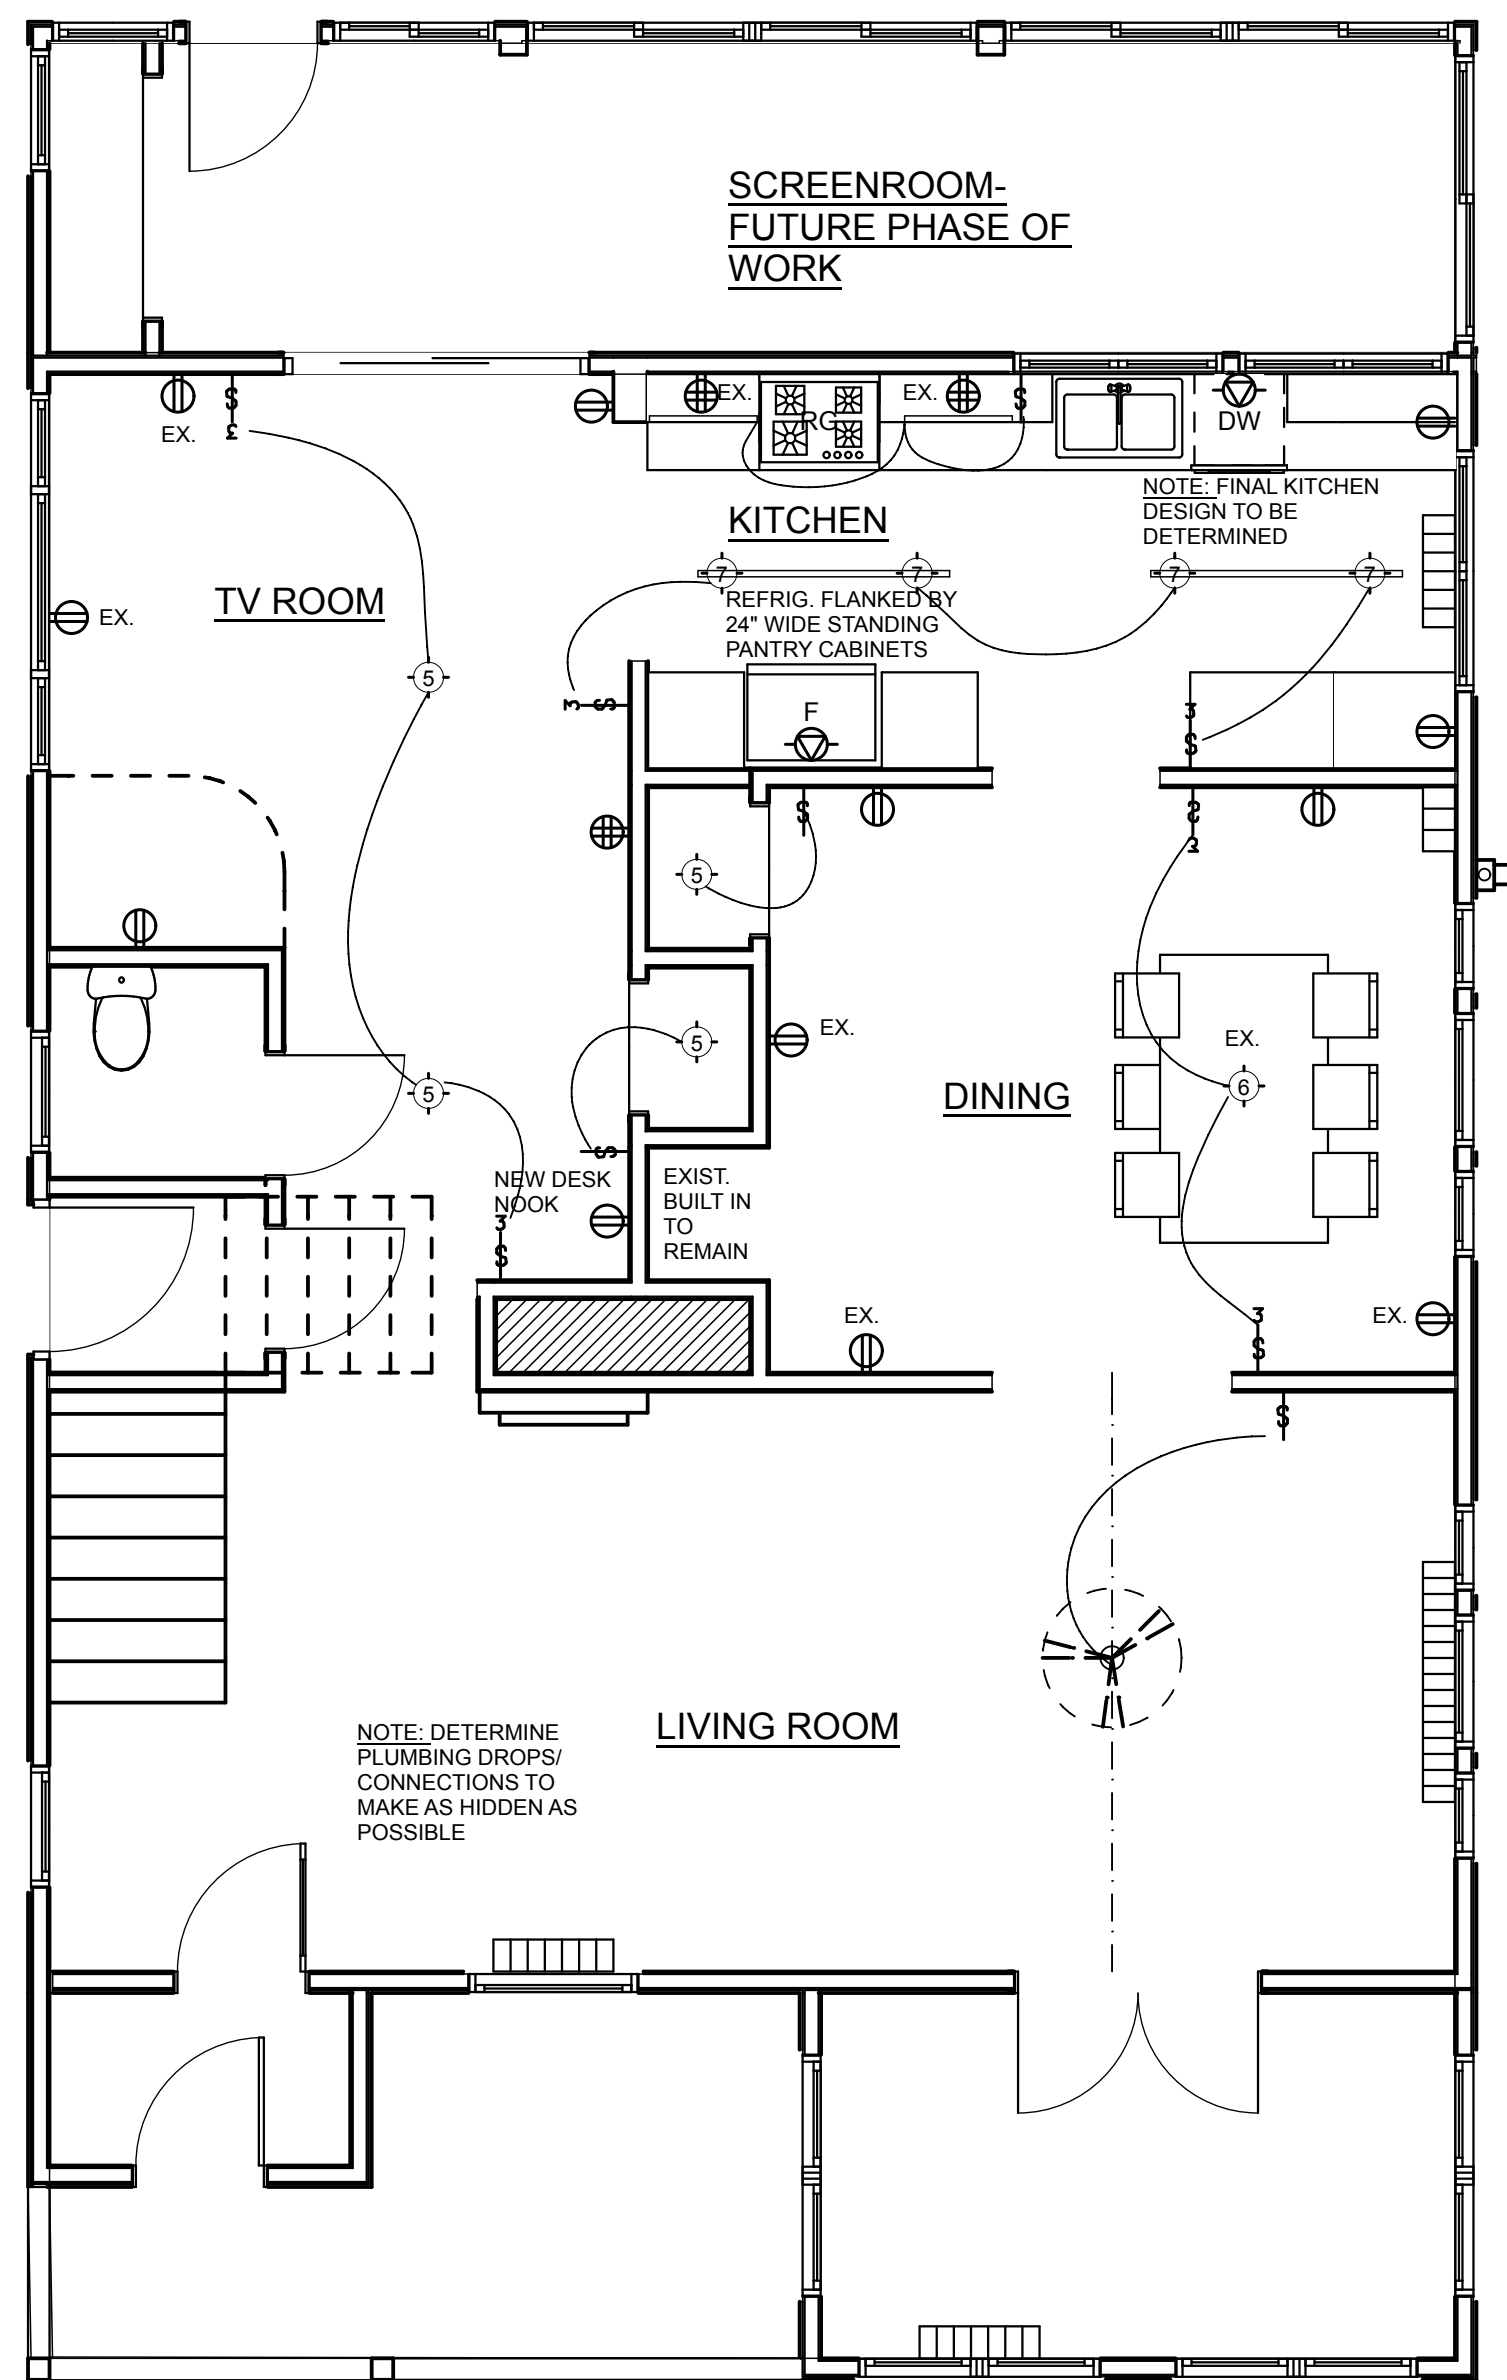

1 1st Floor Electric  
 E-1 SCALE: 1/4" = 1'-0"

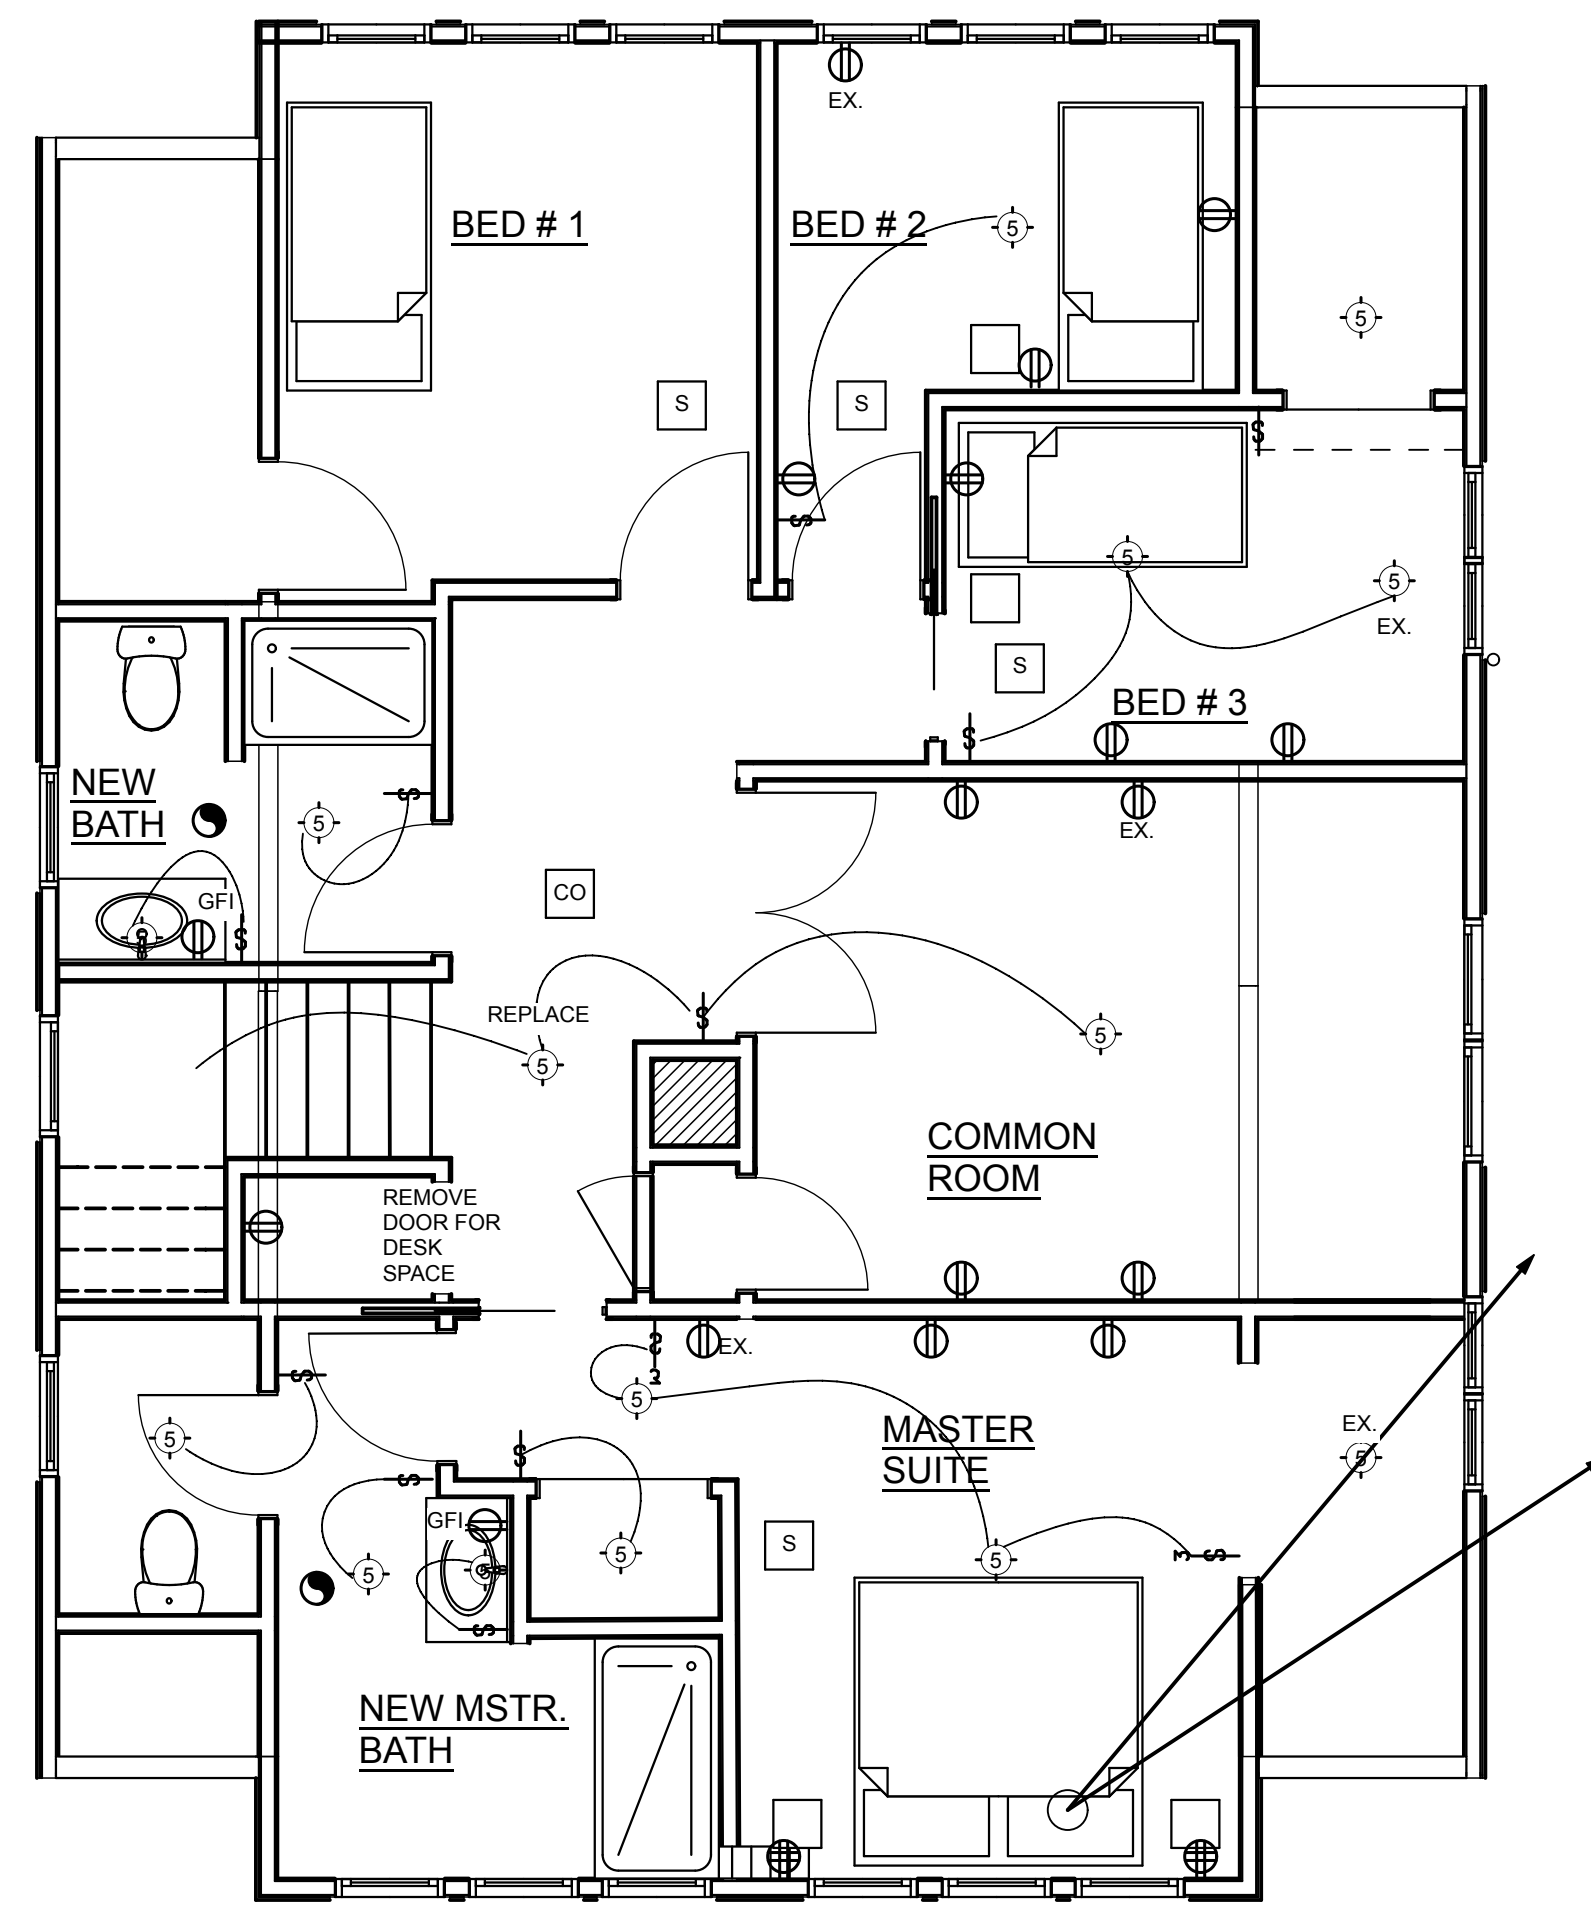

2 2nd Floor Electric  
 E-1 SCALE: 1/4" = 1'-0"

- LIFE SAFETY SYMBOLS**
- [S] SMOKE DETECTOR
  - [CO] CARBON MONOXIDE DETECTOR
  - [E] ELECTRICAL SYMBOLS - "E" BESIDE SYMBOL DENOTES EXISTING ROUGH ELECTRICAL WORK
  - [DUPL] DUPLEX OUTLET 18" A.F.F. UNLESS NOTED OTHERWISE  
 \*"WP" INDICATES WATERPROOF OUTLET  
 PROVIDE GFI WHERE NOTED
  - [DDUPL] DOUBLE DUPLEX OUTLET 18" A.F.F. UNLESS NOTED OTHERWISE  
 \*"WP" INDICATES WATERPROOF OUTLET  
 PROVIDE GFI WHERE NOTED
  - [SPP] SPECIAL PURPOSE POWER OUTLET - CONSULT OWNER - RE STOVE, MICROWAVE, DISPOSAL
  - [WPH] WALL PHONE JACK 18" A.F.F. UNLESS NOTED OTHERWISE
  - [CTV] CABLE TV IF REQ'D - ASK OWNER
  - [SW] SWITCH
  - [3SW] THREE-WAY SWITCH
  - [COM] COMPUTER - CONSULT OWNER - RE INTERNET CONNECTION
  - [DFO] DUPLEX FLOOR OUTLET
  - [CF] CEILING FAN
  - [EF] EXHAUST FAN
- LIGHTING SYMBOLS**
- [1] RECESSED CAN FIXTURE- LED WARM LIGHT TYPICAL
  - [2] WALL SCONCE
  - [3] EXTERIOR WALL SCONCE
  - [4] UTILITY LIGHT
  - [5] SURFACE MOUNTED FIXTURE
  - [6] PENDANT
  - [TL] TRACK LIGHTS
  - [UL] UNDERCOUNTER LIGHTING