


FAN/LIGHT SCHEDULE

- TYPE A BATHROOM WALL SCONCE
- TYPE B EXHAUST FAN
- TYPE C RECESSED PORCH LIGHT
- TYPE D RECESSED HALL LIGHT
- TYPE E EXTERIOR DECK SCONCE
- TYPE F SHOWER WALL SCONCE

TO GARAGE LIGHT

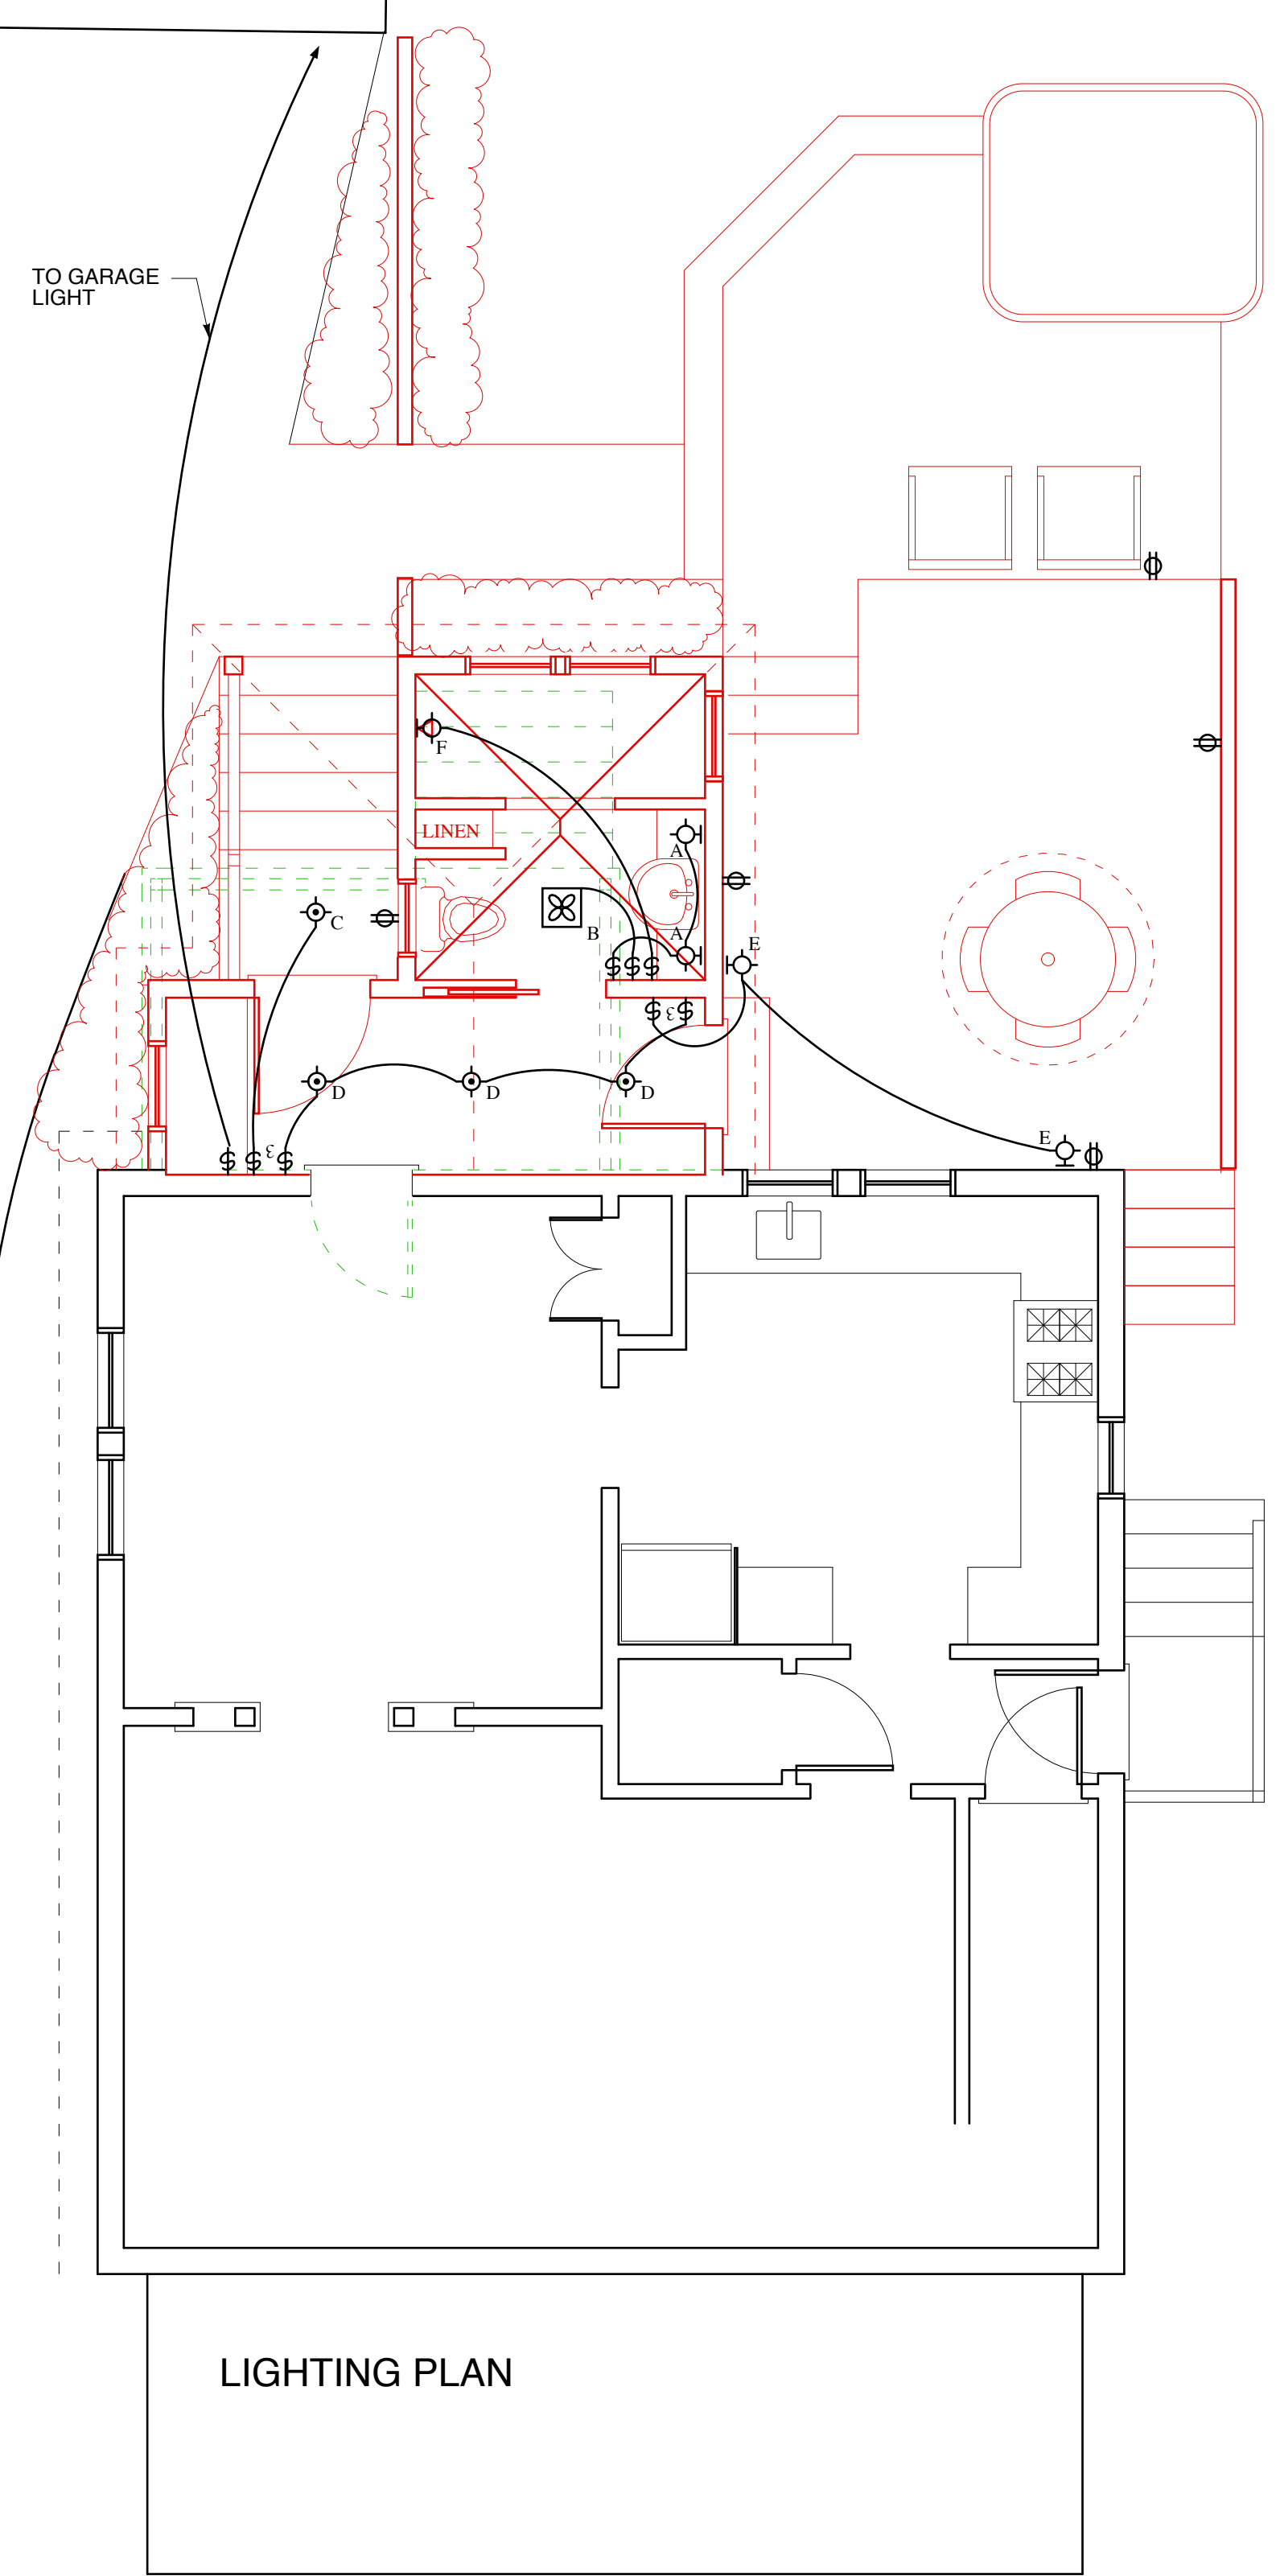

LIGHTING PLAN

McMurray
Residence


11 Deerfield Road
Portland, Maine

SCALE 1/4" = 1' - 0"

DRAWN BY: **BBB**

DATE: 10/16/12

Copyright 2012 by By Design.
All rights reserved. All drawings and
written material appearing herein
constitute original and unpublished
work of the Architect and may not be
reproduced, stored, or disclosed without
written consent of By Design.

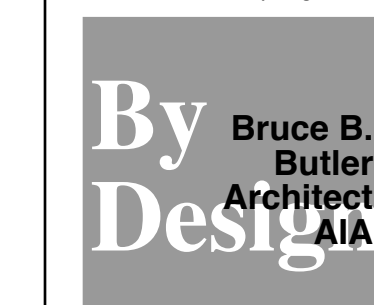

PROPOSED
LIGHTING PLAN

A400f