


FOODSERVICE EQUIPMENT SCHEDULE																						
MK.	QTY	DESCRIPTION	ELECTRICAL						WATER		WASTE	GAS		STEAM				VENTILATION				REMARKS
			FLAMPS	KW	HP	VOLTS	PHASE	DIRECT	PLUG	COLD	HOT	DIRECT	INDIRECT	SIZE	MBTUH	LBS/HR	PSIG	INLET	RETURN	EXHAUST		
																			SIZE	CFM	SIZE	CFM
1	2	UTILITY CART																				
2	5	SHELVING UNIT																				
3	2	HAND SINK							1/2"	1/2"	1-1/2"											
4	1	SINK, 3-COMPARTMENT							1/2"	1/2"	3 @ 2"											
5	1	DISHWASHER, UNDERCOUNTER	30.5			120/208	1	X	1/2"	3/4"	1-1/2"											
6	1	MOP SINK CABINET							1/2"	1/2"	2"											
7	2	SHELVING UNIT																				
8	1	REFRIGERATOR, 2-SECTION	5.9		1/2	115	1	X														
9	1	FREEZER, 2-SECTION	9.0		3/4	115	1	X														
10	1	REFRIGERATOR, 2-SECTION	5.9		1/2	115	1	X														
11	1	SHEET PAN RACK																				
12	1	EXHAUST HOOD SYSTEM	15.0			115	1	X										14" DIA.	1783	4 @ 16" DIA.	401 EA.	
	1	EXHAUST FAN	15.0			115	1	X														
	1	MAKE-UP AIR SYSTEM	15.0			115	1	X														
13	1	RANGE, 4-BURNER, 36"-GRIDDLE											1"	238								
14	1	FRYER DUMP STATION																				
15	1	FRYER, DEEP FAT										3/4"	90									
16	1	WORK TABLE WITH SINK							1/2"	1/2"	2"											
17	2	SHELVING UNIT																				
18	1	PLATE DISPENSER, HEATED	4.5	0.54		120	1	X														
19	1	HOT FOOD WELLS	12.3	2.55		208	1	X				3/4"										
20	2	FOOD PROTECTOR																				
21	1	COLD FOOD WELL	6.0		1/4	120	1	X				3/4"										
22	1	SINK, DROP-IN							1/2"	1/2"	1-1/2"											
23	1	HOT BEVERAGE DISP. (BY OTHERS)	15.0	1.8		120	1	X	1/4"													
24	1	JUICE DISPENSER (BY OTHERS)	6.0			120	1	X	3/8"													
25	1	ICE MACHINE W/BIN	7.0		0.44	115	1	X	3/8"		1/2"											

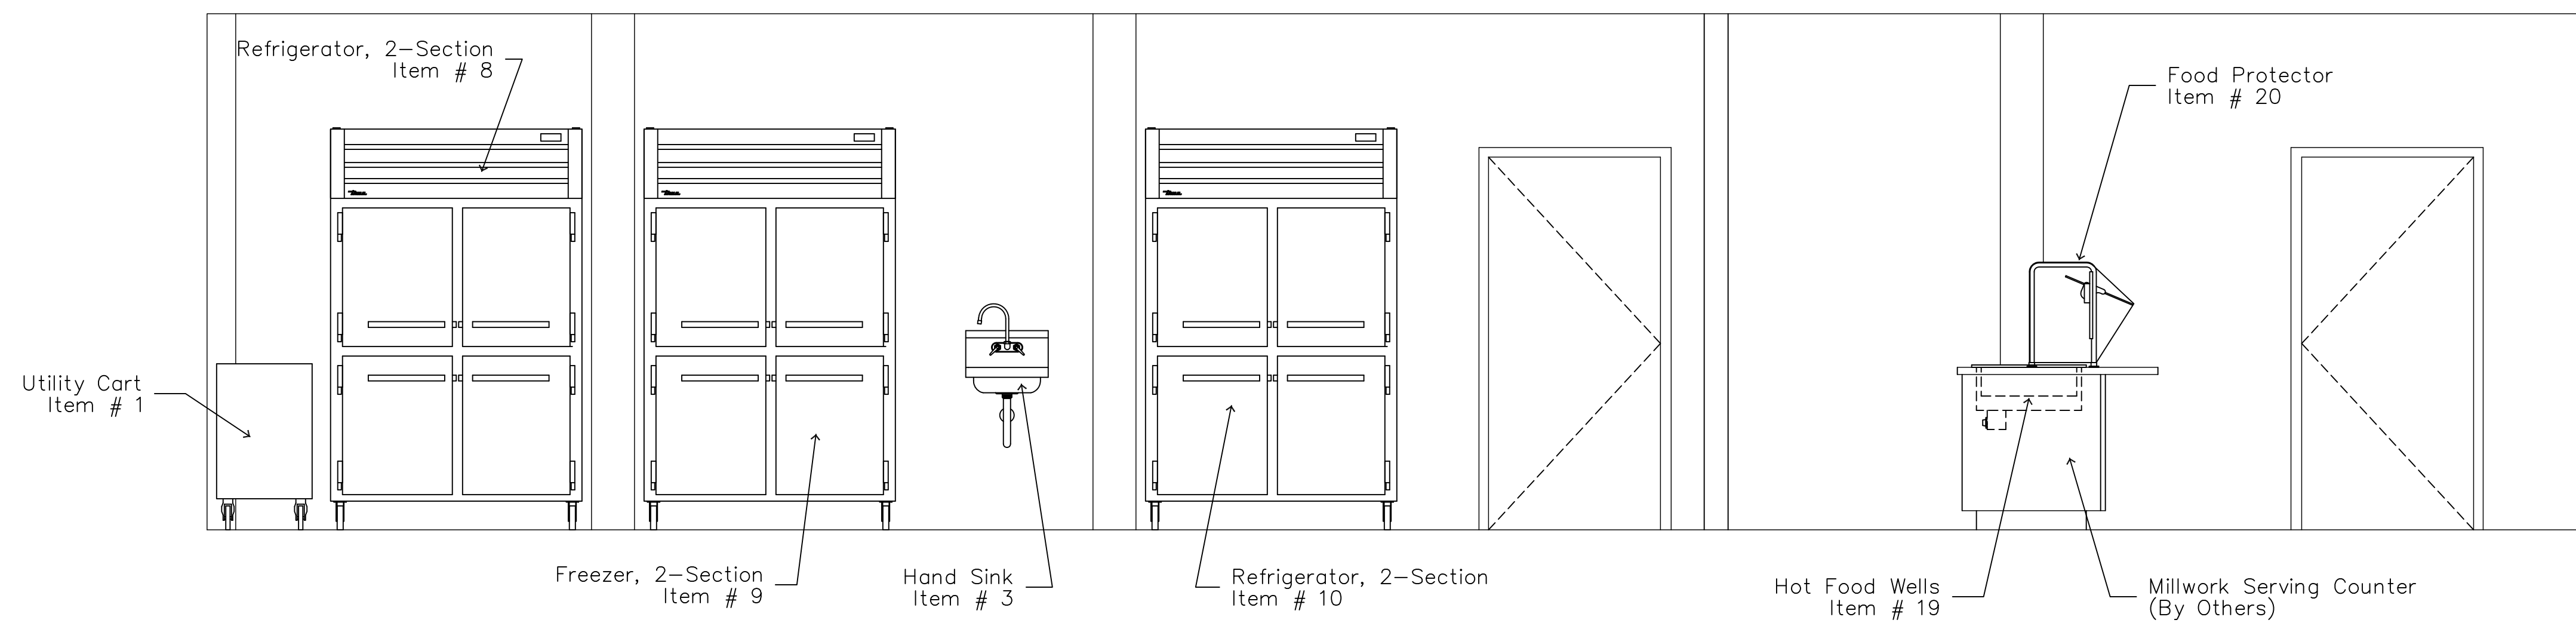

Kitchen North Wall Elevation

SCALE - 1/2" = 1' - 0"

Foodservice Consultant:
TJM Consulting, Inc.
 273 Main Street, Suite 5
 Yarmouth, Maine 04096
 (207) 847-3337 tjmconsulting@maine.rr.com

Architect:
Whipple Callender Architects
 136 Pleasant Avenue
 Portland, Maine 04103

Project:
Liberty Bay Kitchen
 343 Forest Avenue
 Portland, Maine 04101

Drawing:
**Foodservice Equipment
 Mechanical Schedule**

Revisions:

Scale: 1/4" = 1'-0"
 Date: June 30, 2017

SHEET:
FS-2