






Reviewed for Code Compliance
Permitting and Inspections Department
Approved with Conditions
01/03/2020

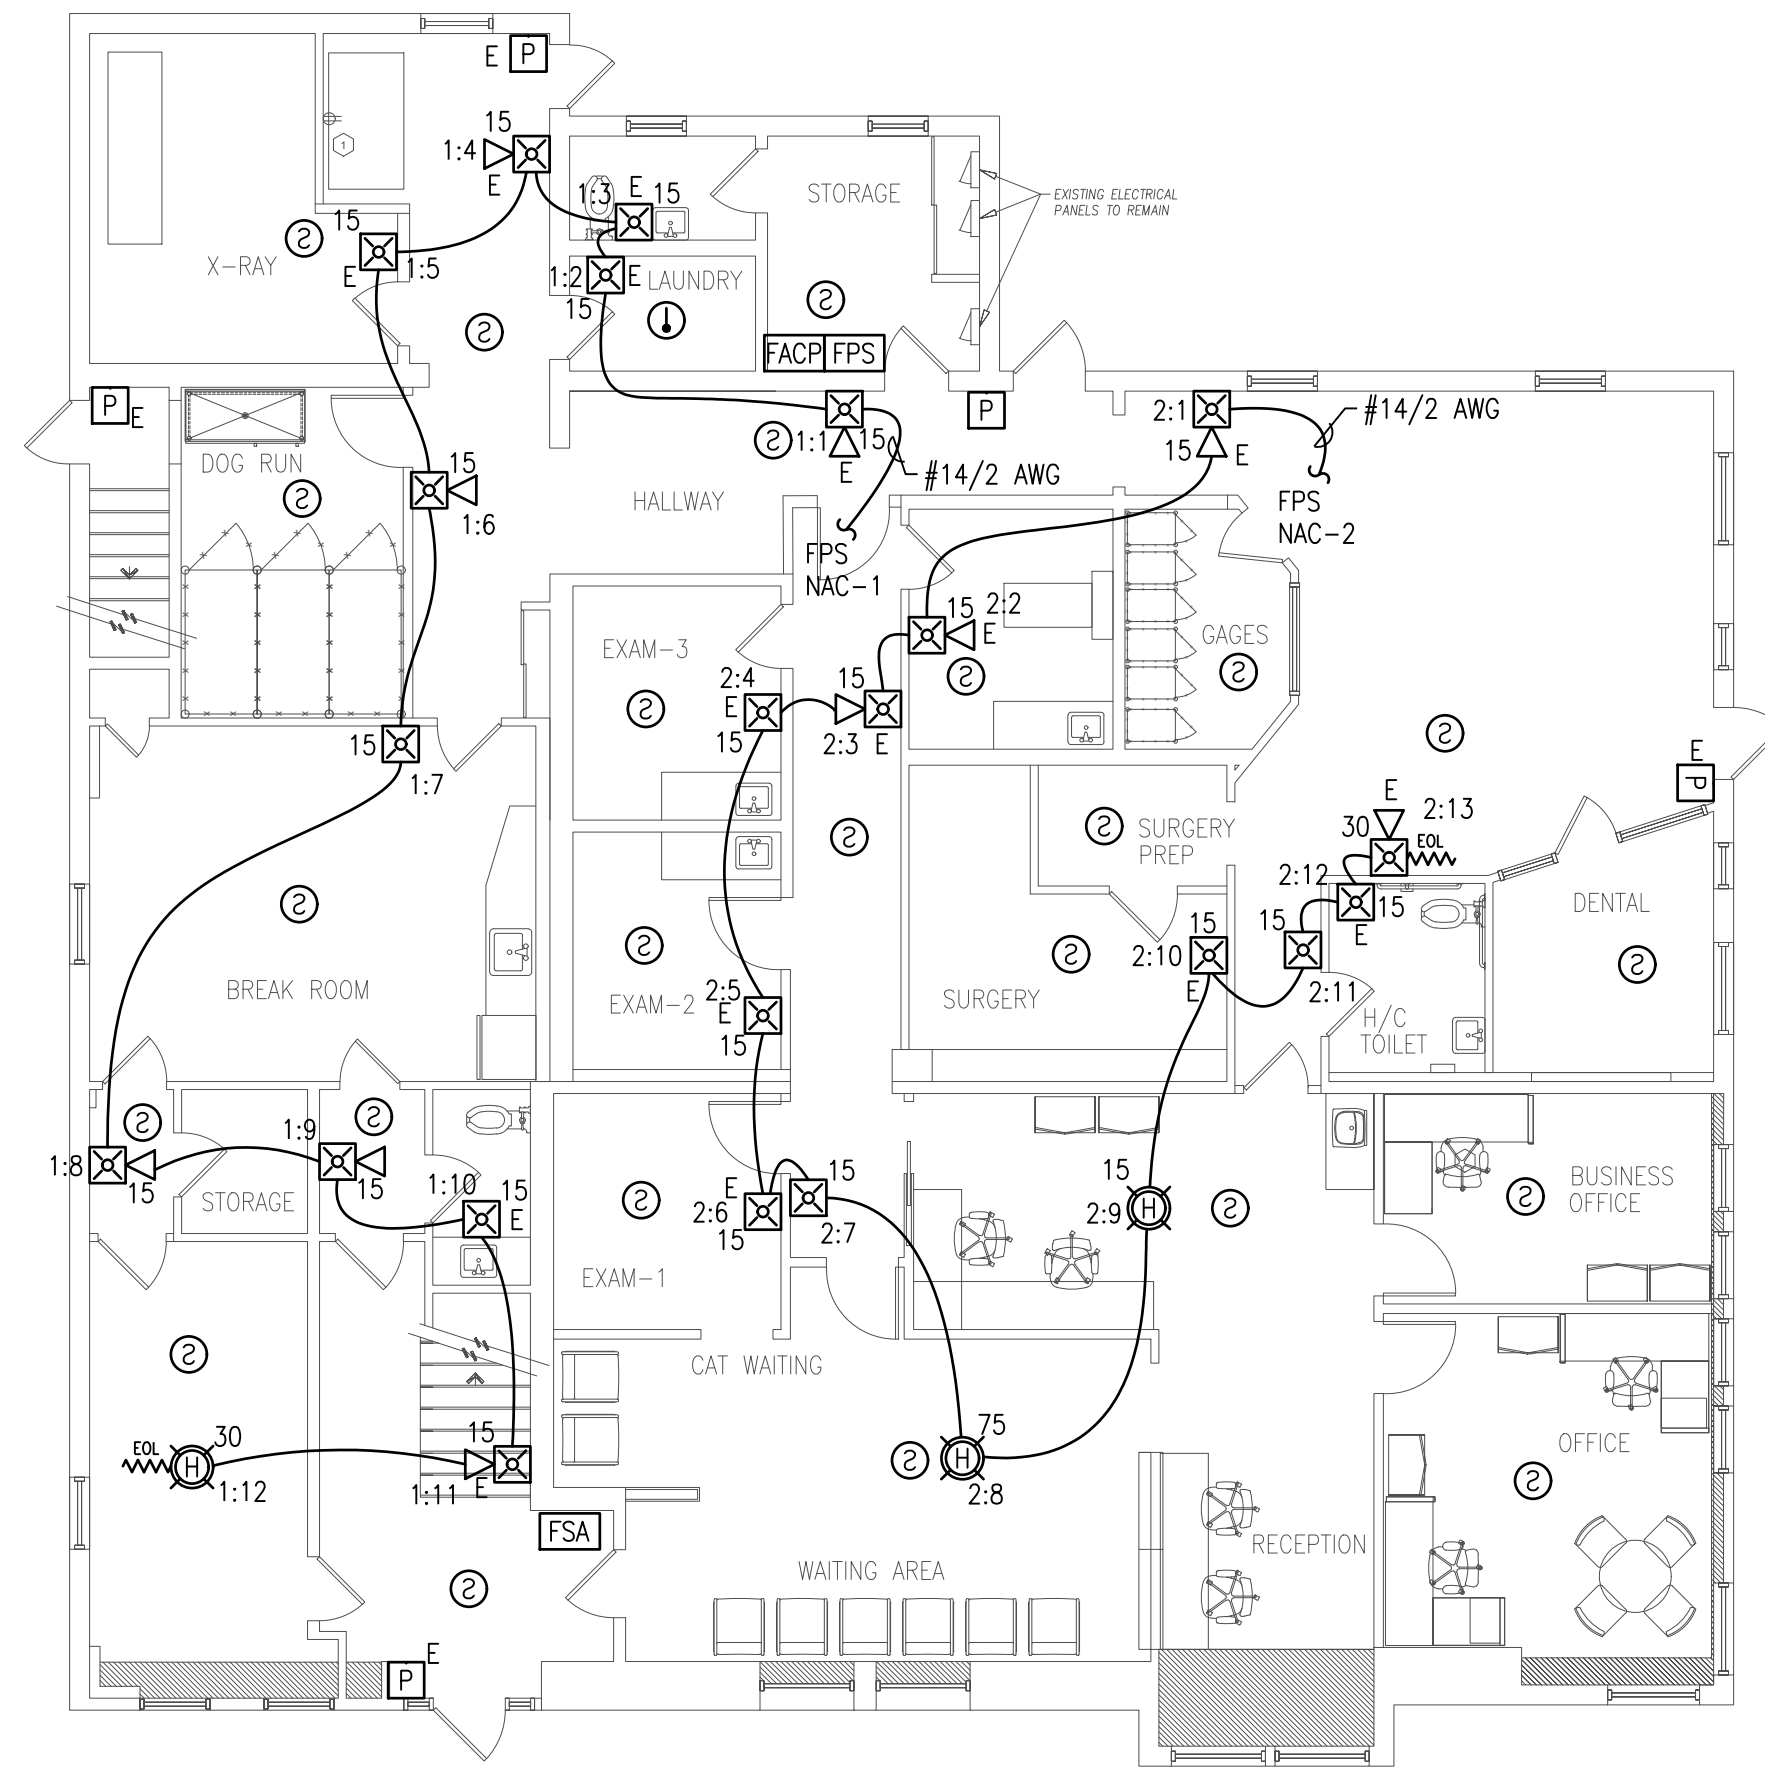


LEVEL 1
FIRE ALARM PLAN
SCALE: 1/8"=1'-0"

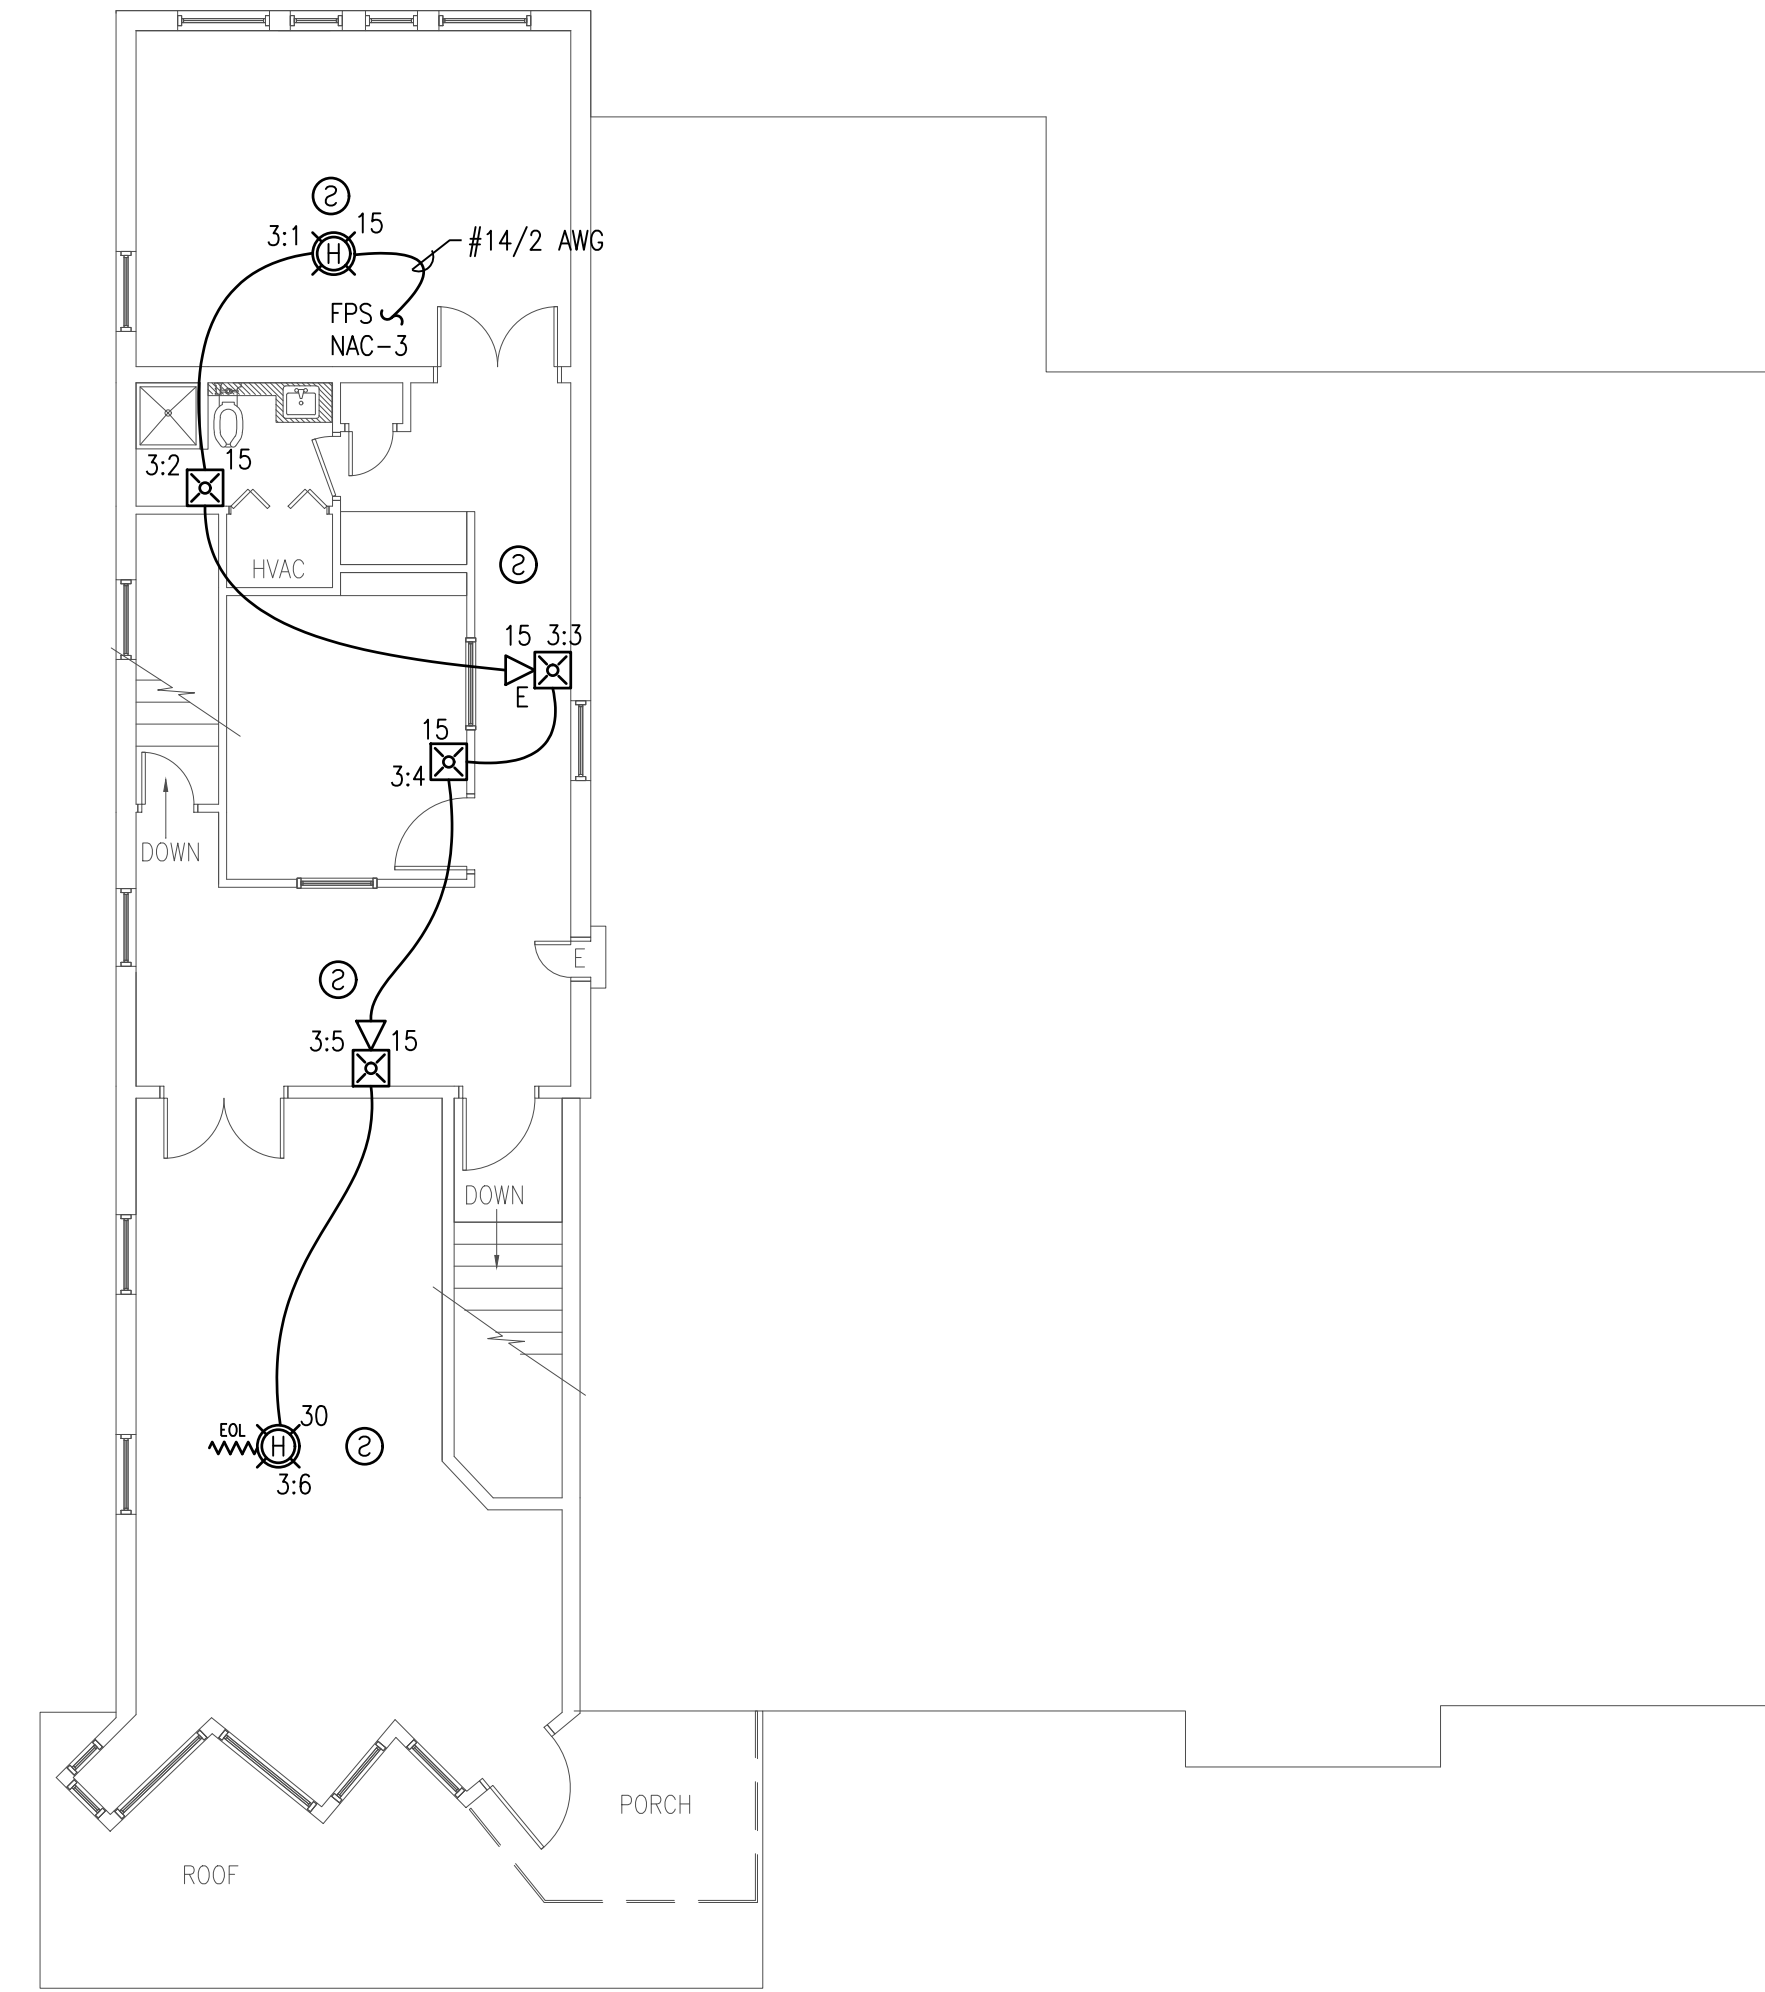

LEVEL 2
FIRE ALARM PLAN
SCALE: 1/8"=1'-0"

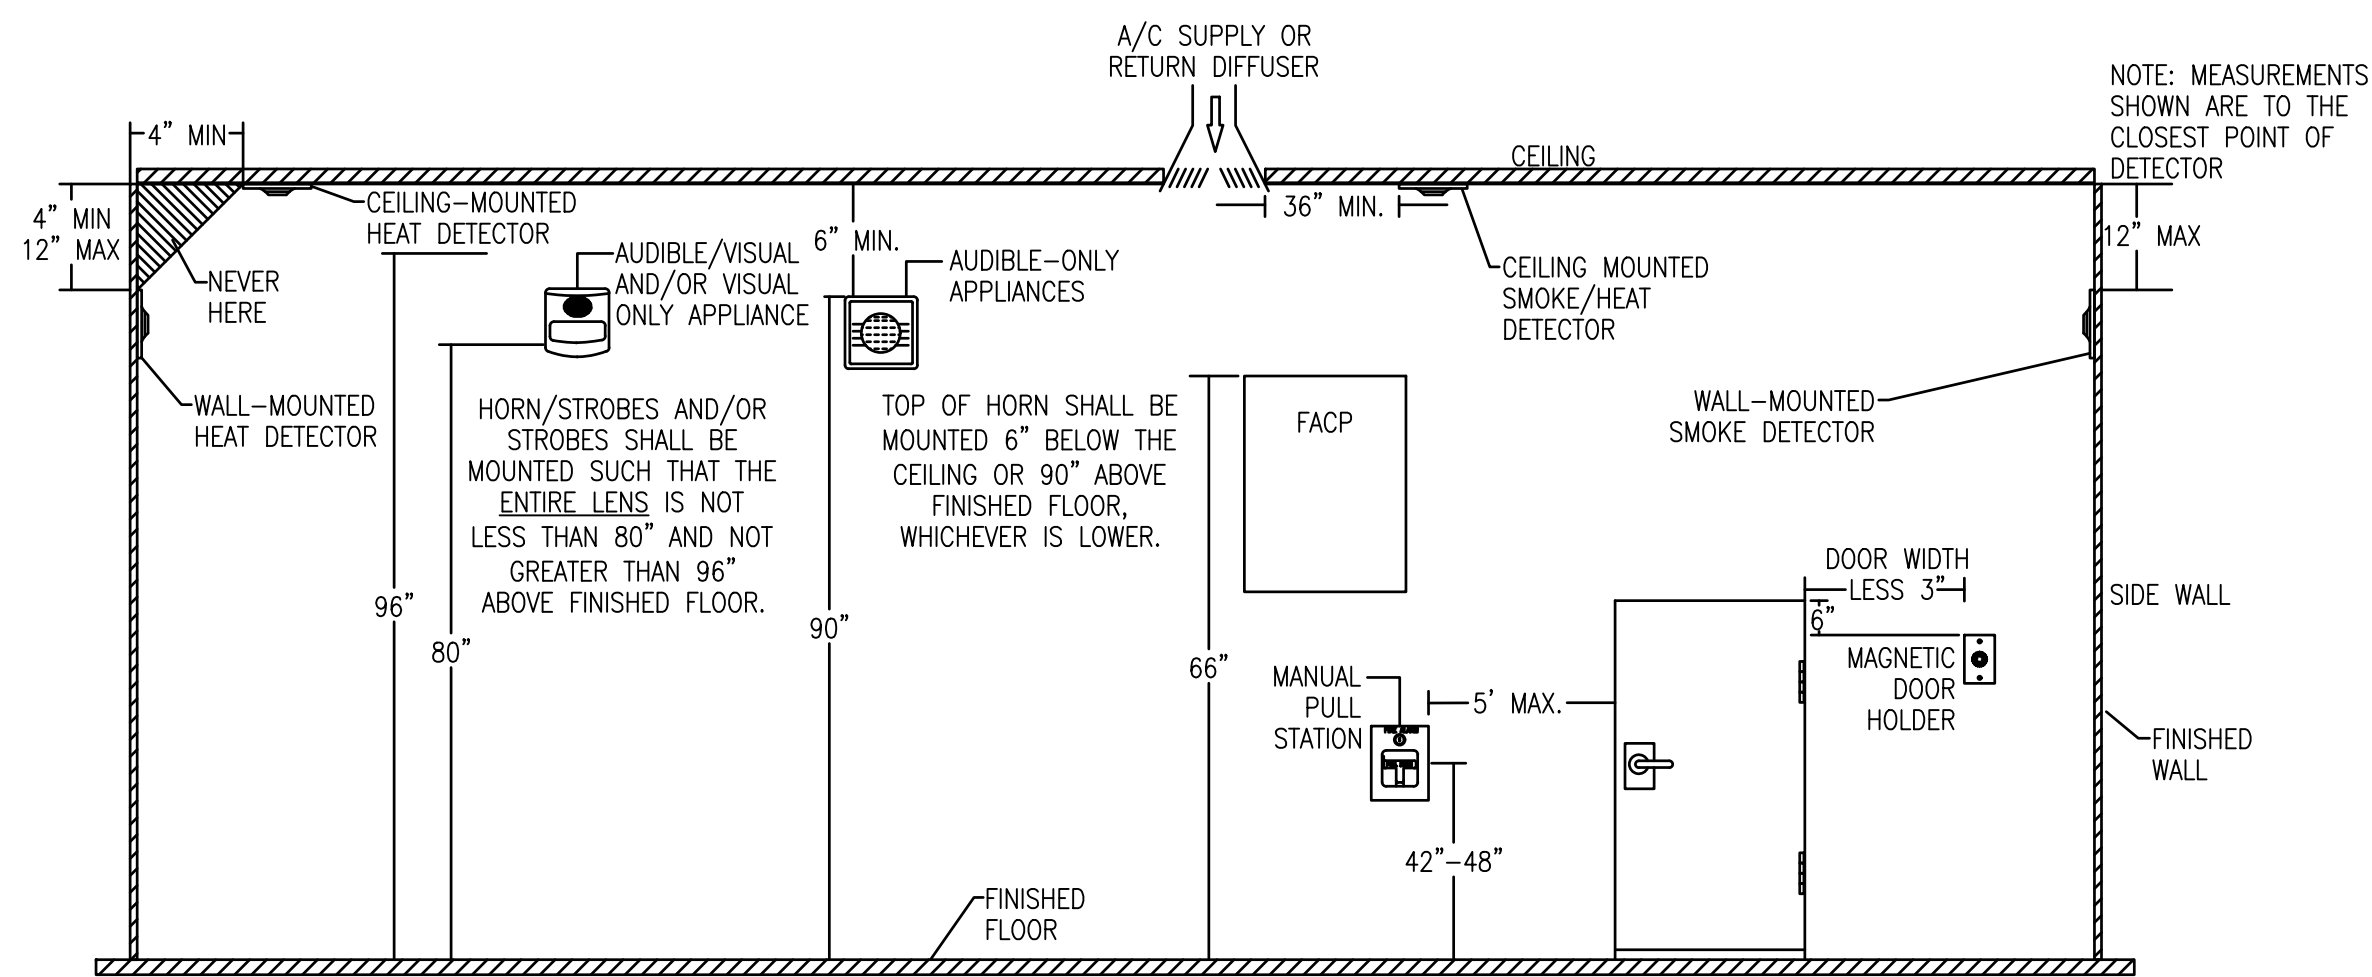

FIRE ALARM DEVICE MOUNTING HEIGHTS
SCALE: NOT TO SCALE

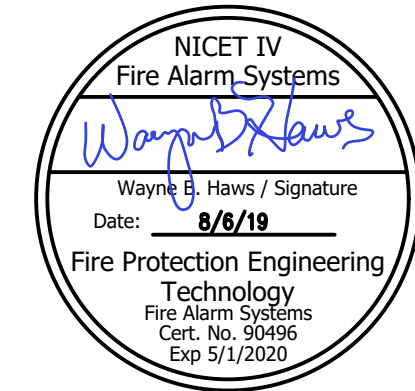

REVISION	DESCRIPTION	DATE
0	ISSUED FOR REVIEW & APPROVAL	8/6/2019

SEACOAST SECURITY

4 Summer Street • Freeport, Maine 04032
Office: (207) 706-3369 • Fax: (207) 865-0852

**BACK COVE VETERINARY
55 BAXTER BLVD.
PORTLAND, ME
FIRE ALARM PLAN**

DRAWN	JOHN STAMPS UNICAD JOB #19352
CHECKED	BRADY B. HAWS NICET III 138751
DATE	8/6/2019
REVISION	0
SCALE	1/8"=1'-0"

Shop drawings created by
5794 W. 4800 St.
Hesper, UT 84315
Office: 801.985.0410

UNICAD Inc.
Technology
Fire Alarm Systems
Exp. 5/1/2020

www.unicad.net Fire Alarm Design & Drafting Services

FA-2