


| Rev. No. | Date | Description | Drawn by: JFD |
|----------|------|-------------|---------------|
| | | | |
| | | | |

- ROOF NOTES:**
FINAL LOCATION OF MECHANICAL EQUIPMENT TO BE VERIFIED.
TAPERED INSULATION SADDLE AT ALL RTU'S
- FULLY ADHERED ROOF MEMBRANE:**
FIRESTONE RUBBERIZED FULLY ADHERED 60 MIL EPDM SHEET MEMBRANE
OVER 1/2" RECOVERY BOARD OVER MIN. R-23.6 POLYISOCYANURATE
BOARD INSULATION.
- SOFFIT & FASCIA:**
FIRESTONE UNA-CLAD UC-500 -032 ALUMINUM WITH KYNAR FINISH, COLOR: IBD.
- PARAPET WALL OPENINGS:**
1. SCUPPER (WELDED): 12" LONG x 9" HIGH.
w/ LEADER HEAD: 12" LONG x 15" HIGH.
w/ 6x6 DOWNSPOUT.
2. OVERFLOW SCUPPER (WELDED): 14" LONG x 8" HIGH.
3. REFER TO DETAILS 1 & 2 SHEET A4.5 FOR PRIMARY AND OVERFLOW SCUPPER DETAILS.
- PARAPET WALL CAP:**
1. STEEL 24 ga. ON-SITE ROLL FORM METAL CAP.
2. METAL FABRICATOR.

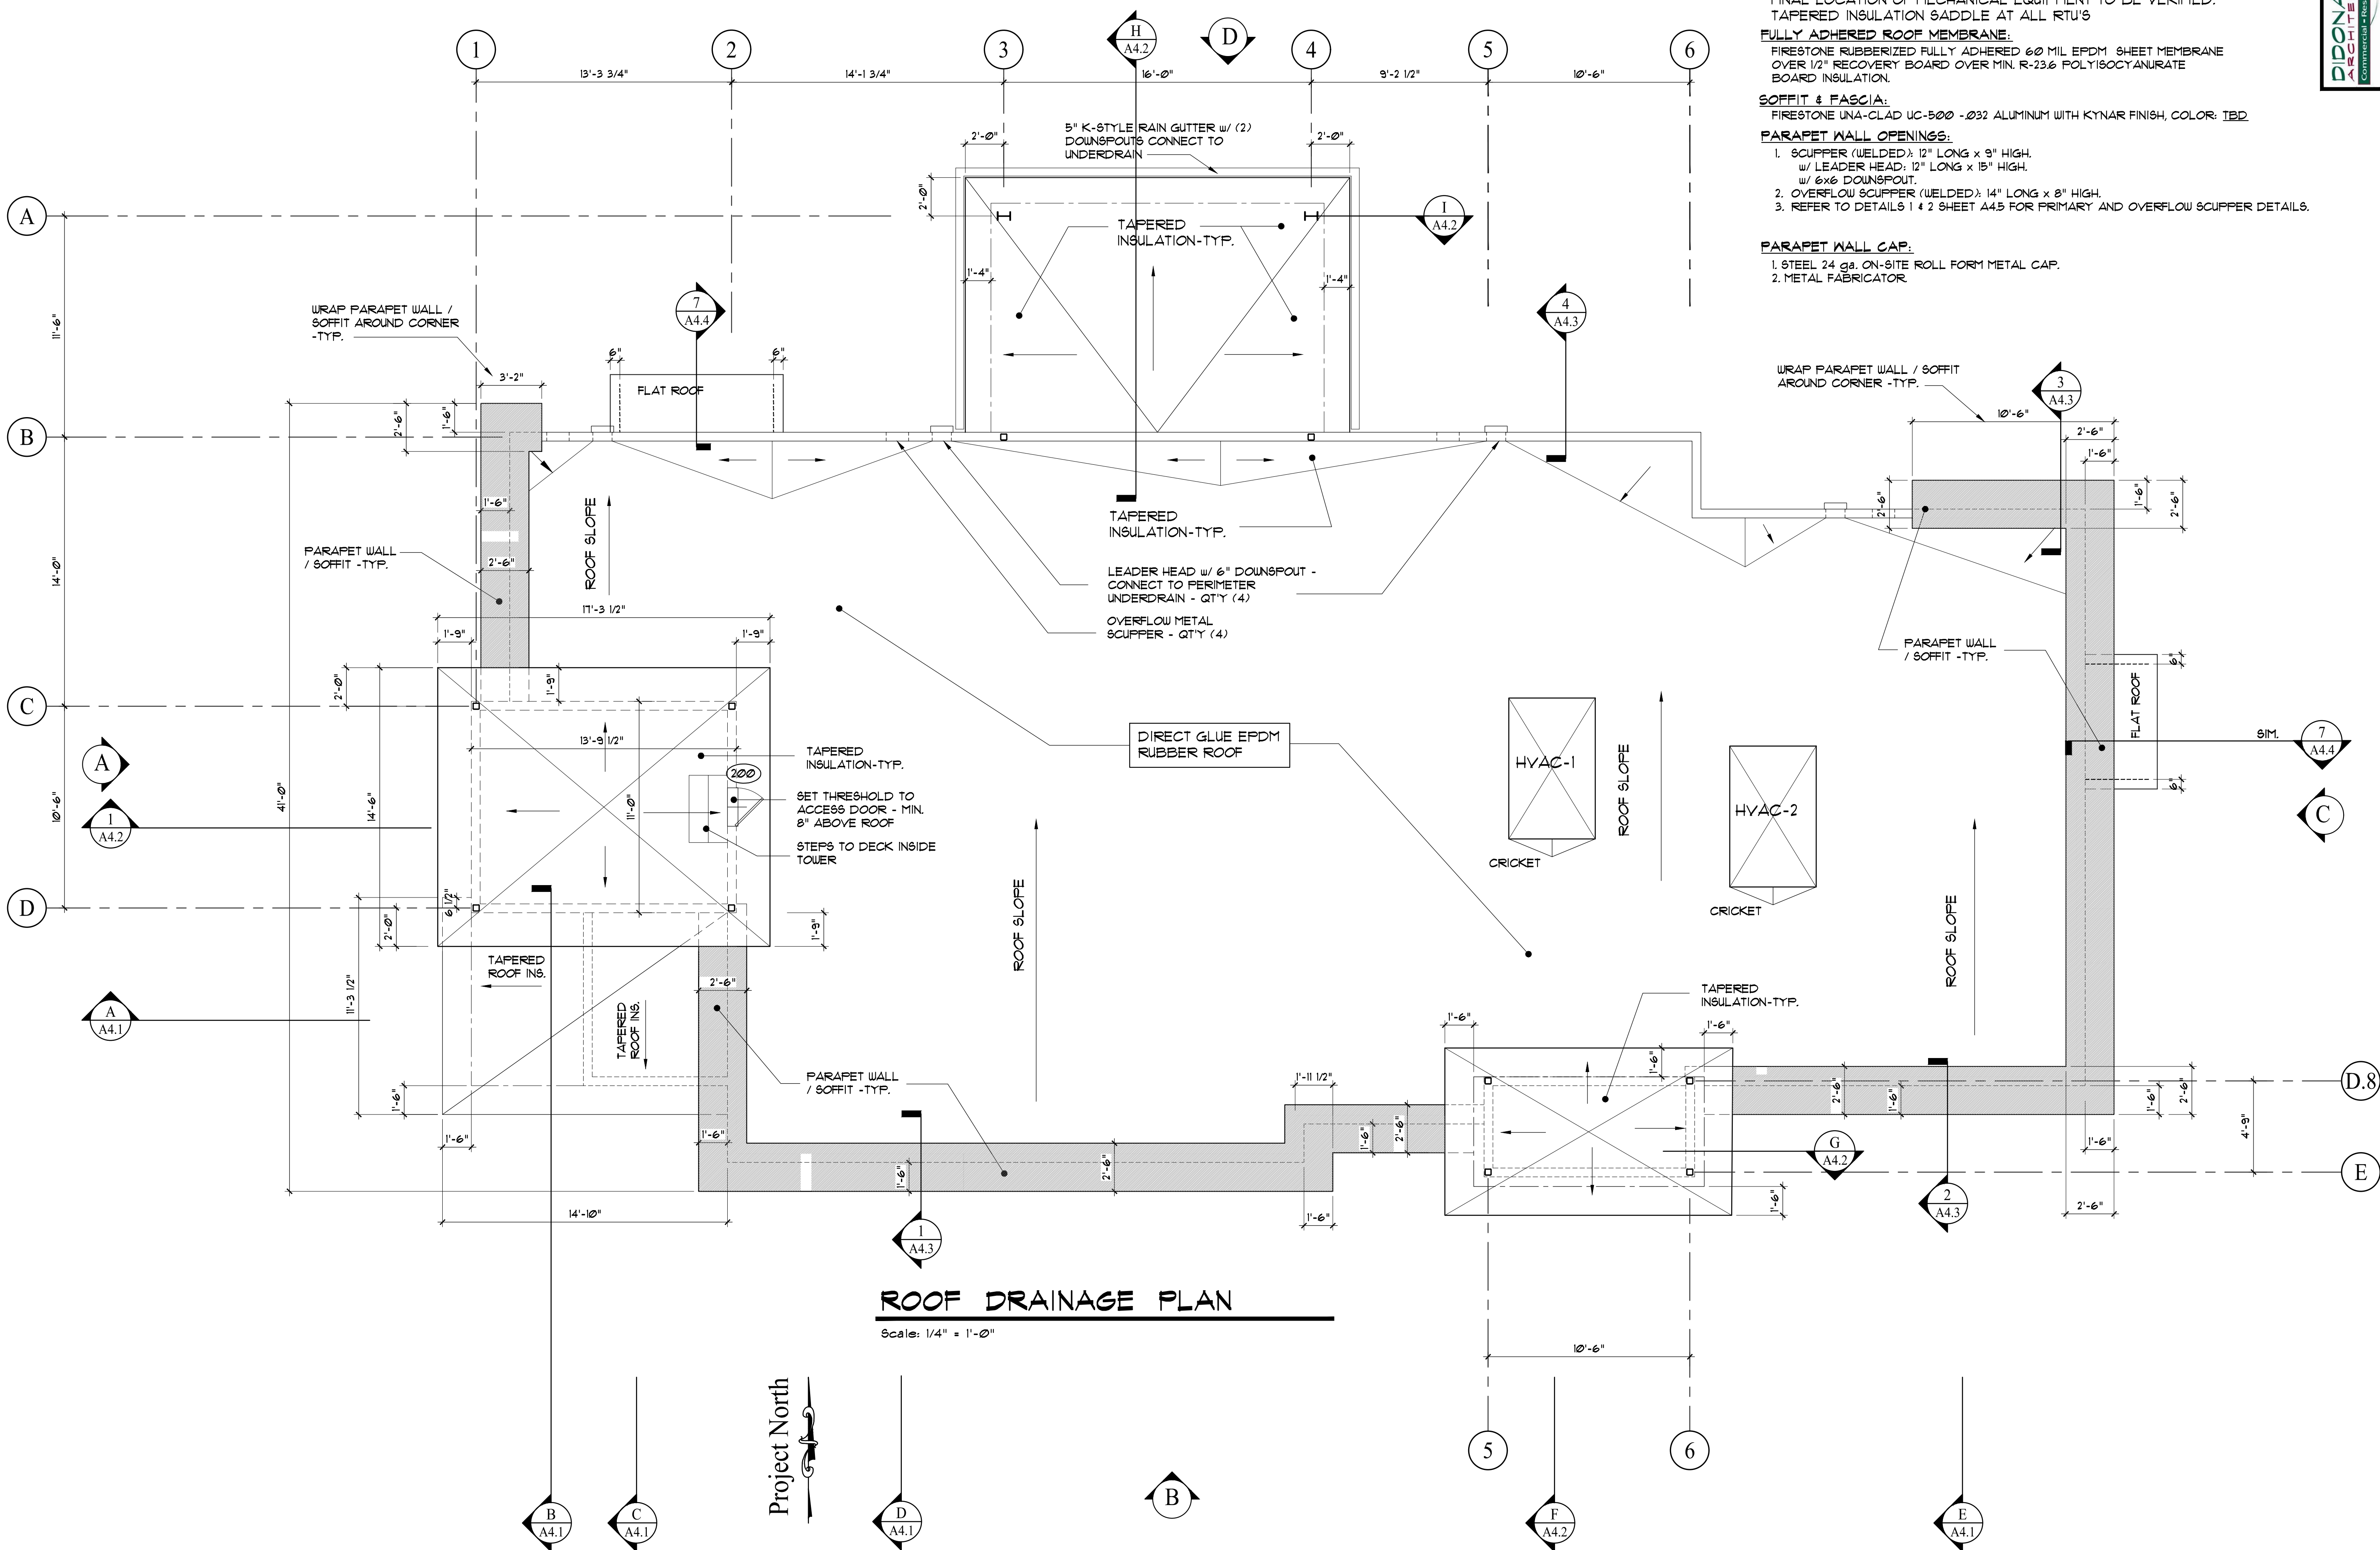

ROOF DRAINAGE PLAN
Scale: 1/4" = 1'-0"

