

400 US Route One, Suite A South
 Falmouth, ME 04105
 Tel: (207) 842-6260
 Fax: (207) 842-6271
 1 (800) 232-2253




| Rev. No. | Date | Description | Drawn by: JFD |
|----------|----------|----------------------|---------------|
| 1 | 10-21-16 | Electrical Revisions | |

Infinity Credit Union
 29 Baxter Boulevard
 Portland, ME
 PLUMBING PLAN

| |
|------------------|
| M2.1 |
| sheet number |
| issued: 10-17-16 |
| project no. - |

10-17-16 FOR CONSTRUCTION

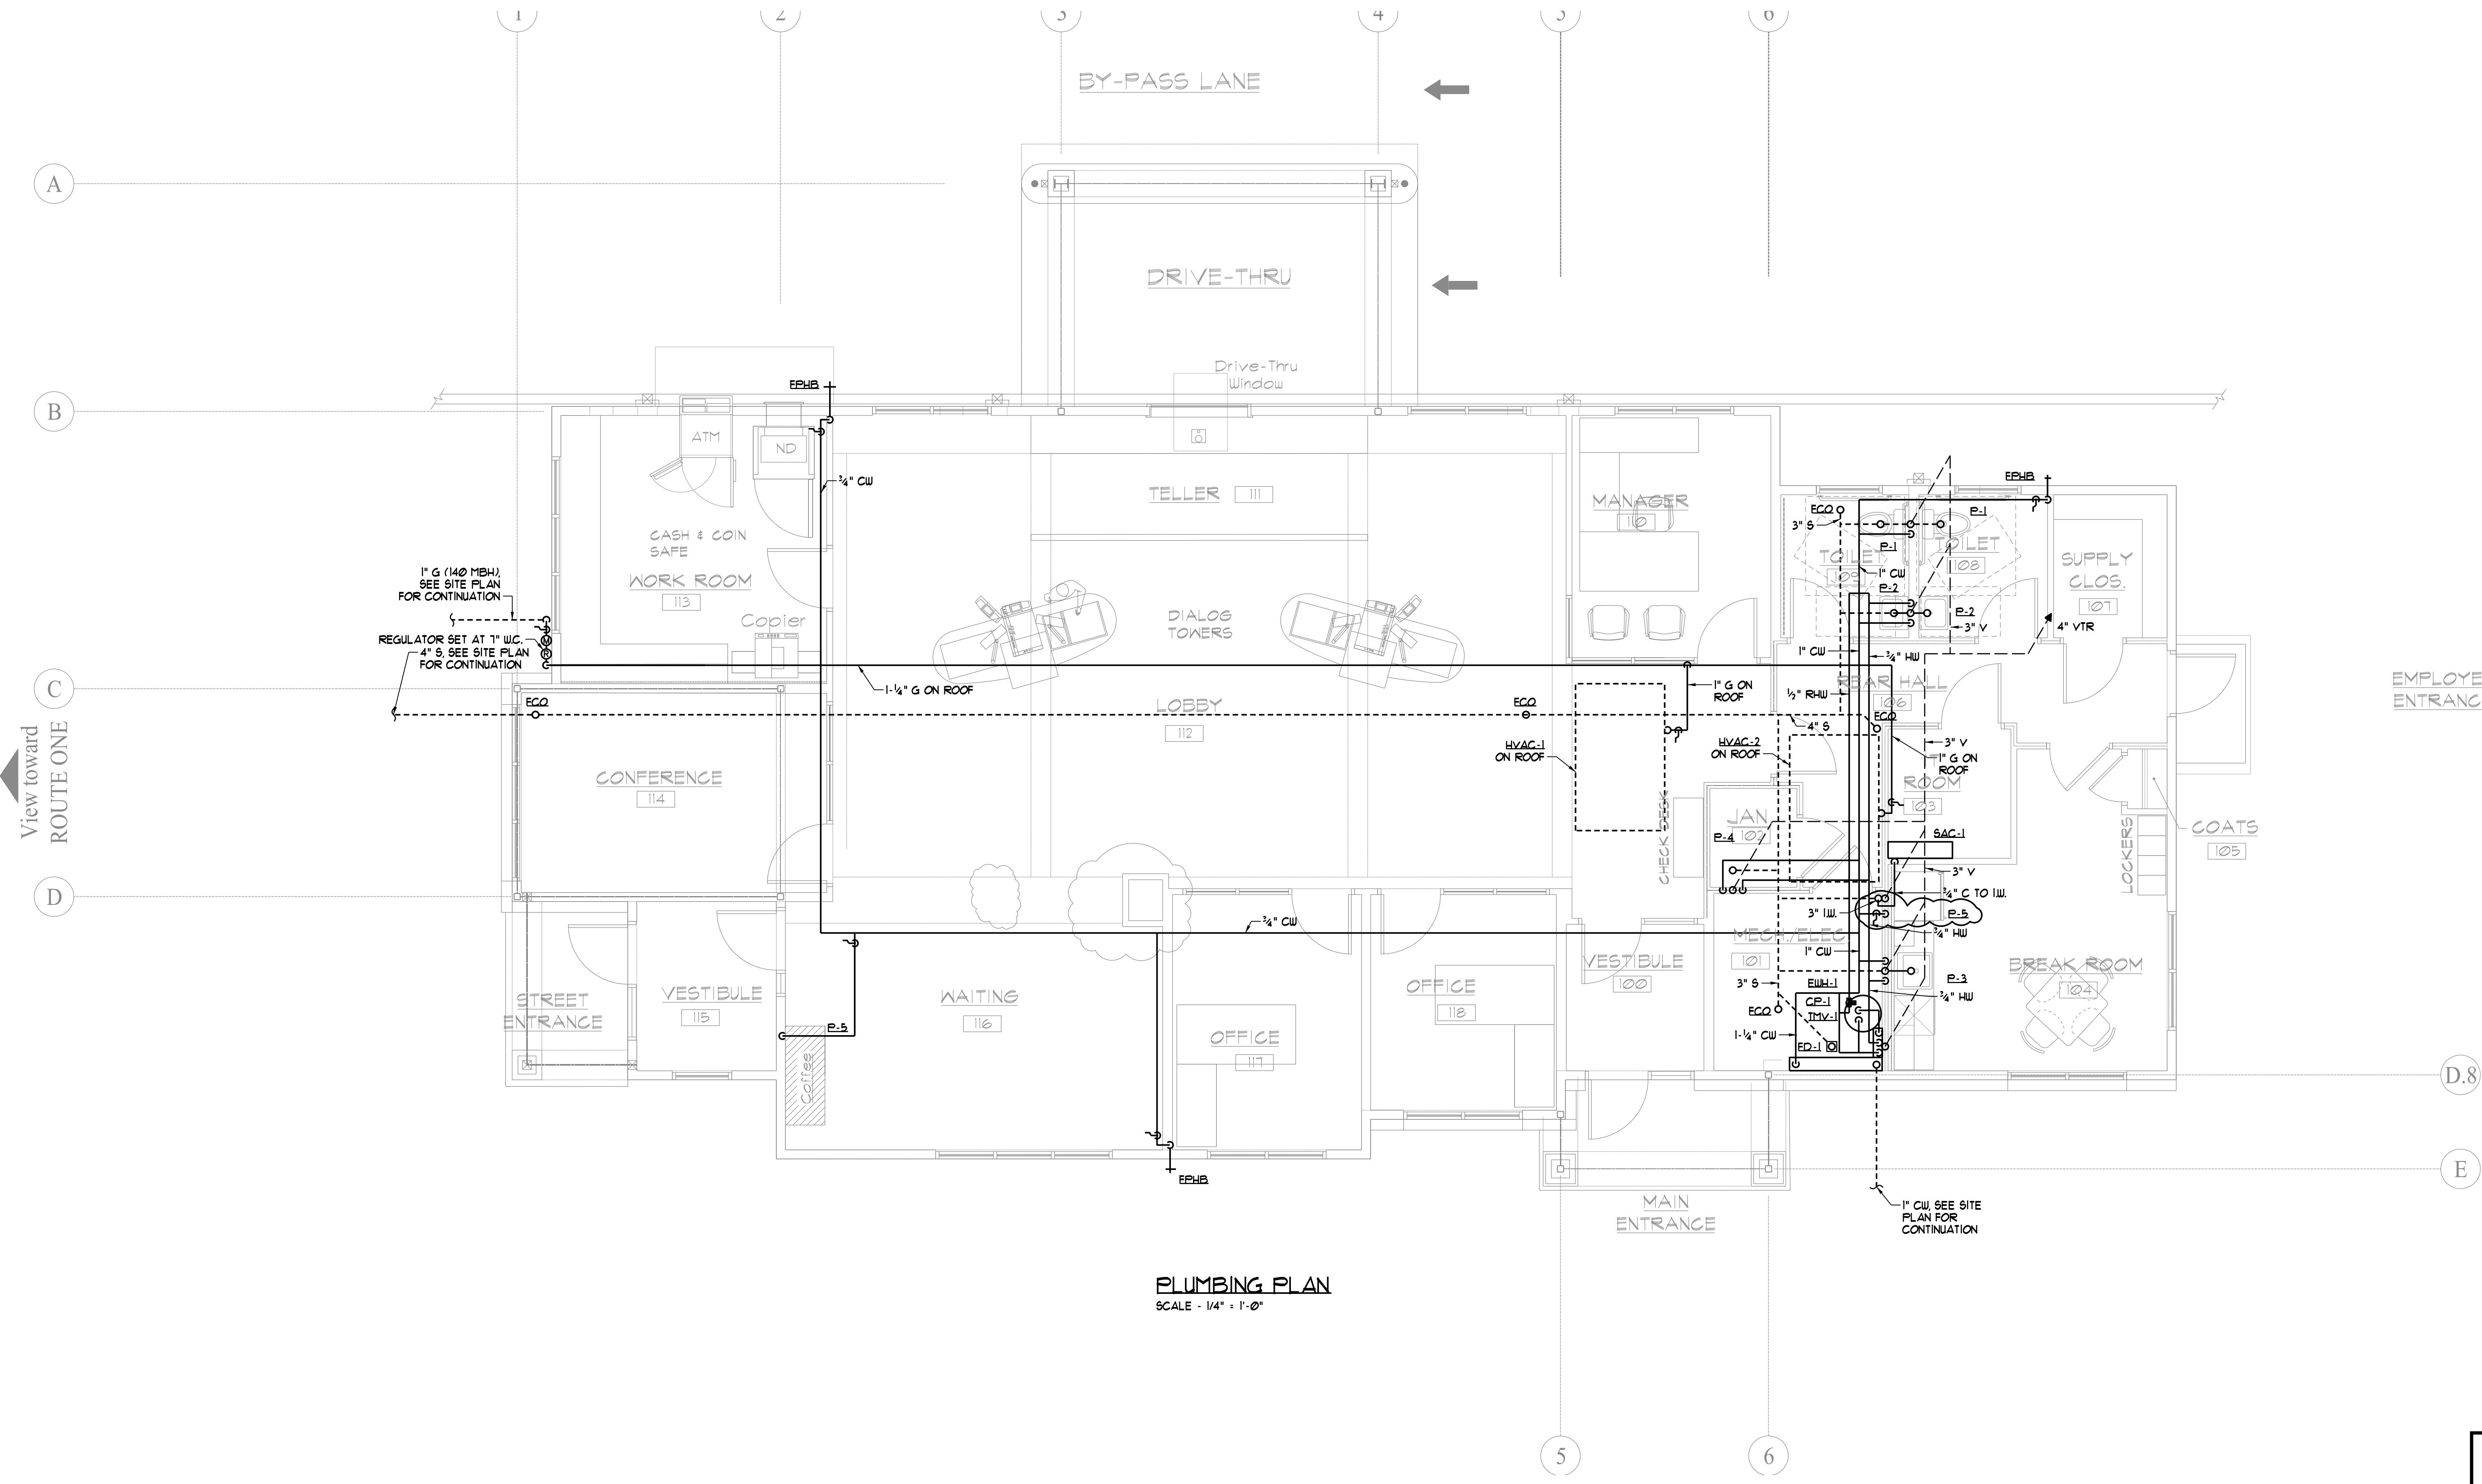

PLUMBING PLAN
 SCALE - 1/4" = 1'-0"

View toward
 ROUTE ONE

A

B

C

D

1

2

3

4

5

6

5

6

D.8

E