
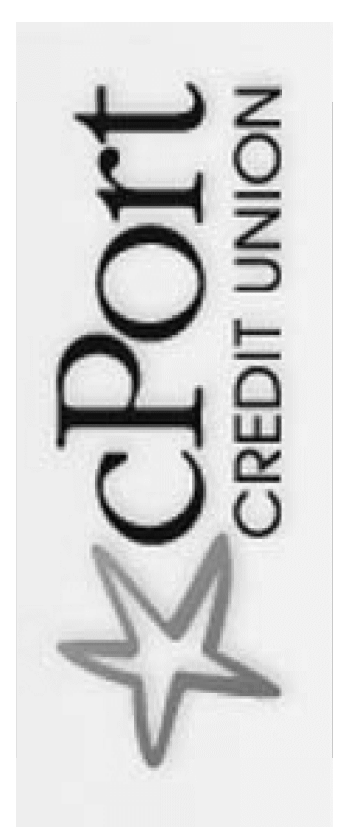


PROGRESS PRINT
NOT FOR CONSTRUCTION

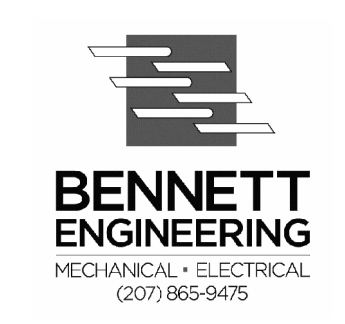


REVISIONS		
#	DATE	DESCRIPTION
1	8/19/11	Revised 90% Review Set

DATE:	08.19.11
PROJECT #:	090609
DRAWN BY:	twg
CHECKED BY:
DRAWING SCALE:	AS NOTED

SHEET TITLE
SITE POWER PLAN

E100

© COPYRIGHT 1985-2011
REPRODUCTION OR RELEASE OF THIS DOCUMENT WITHOUT WRITTEN PERMISSION OF GAWRON TURGEON ARCHITECTS IS PROHIBITED.

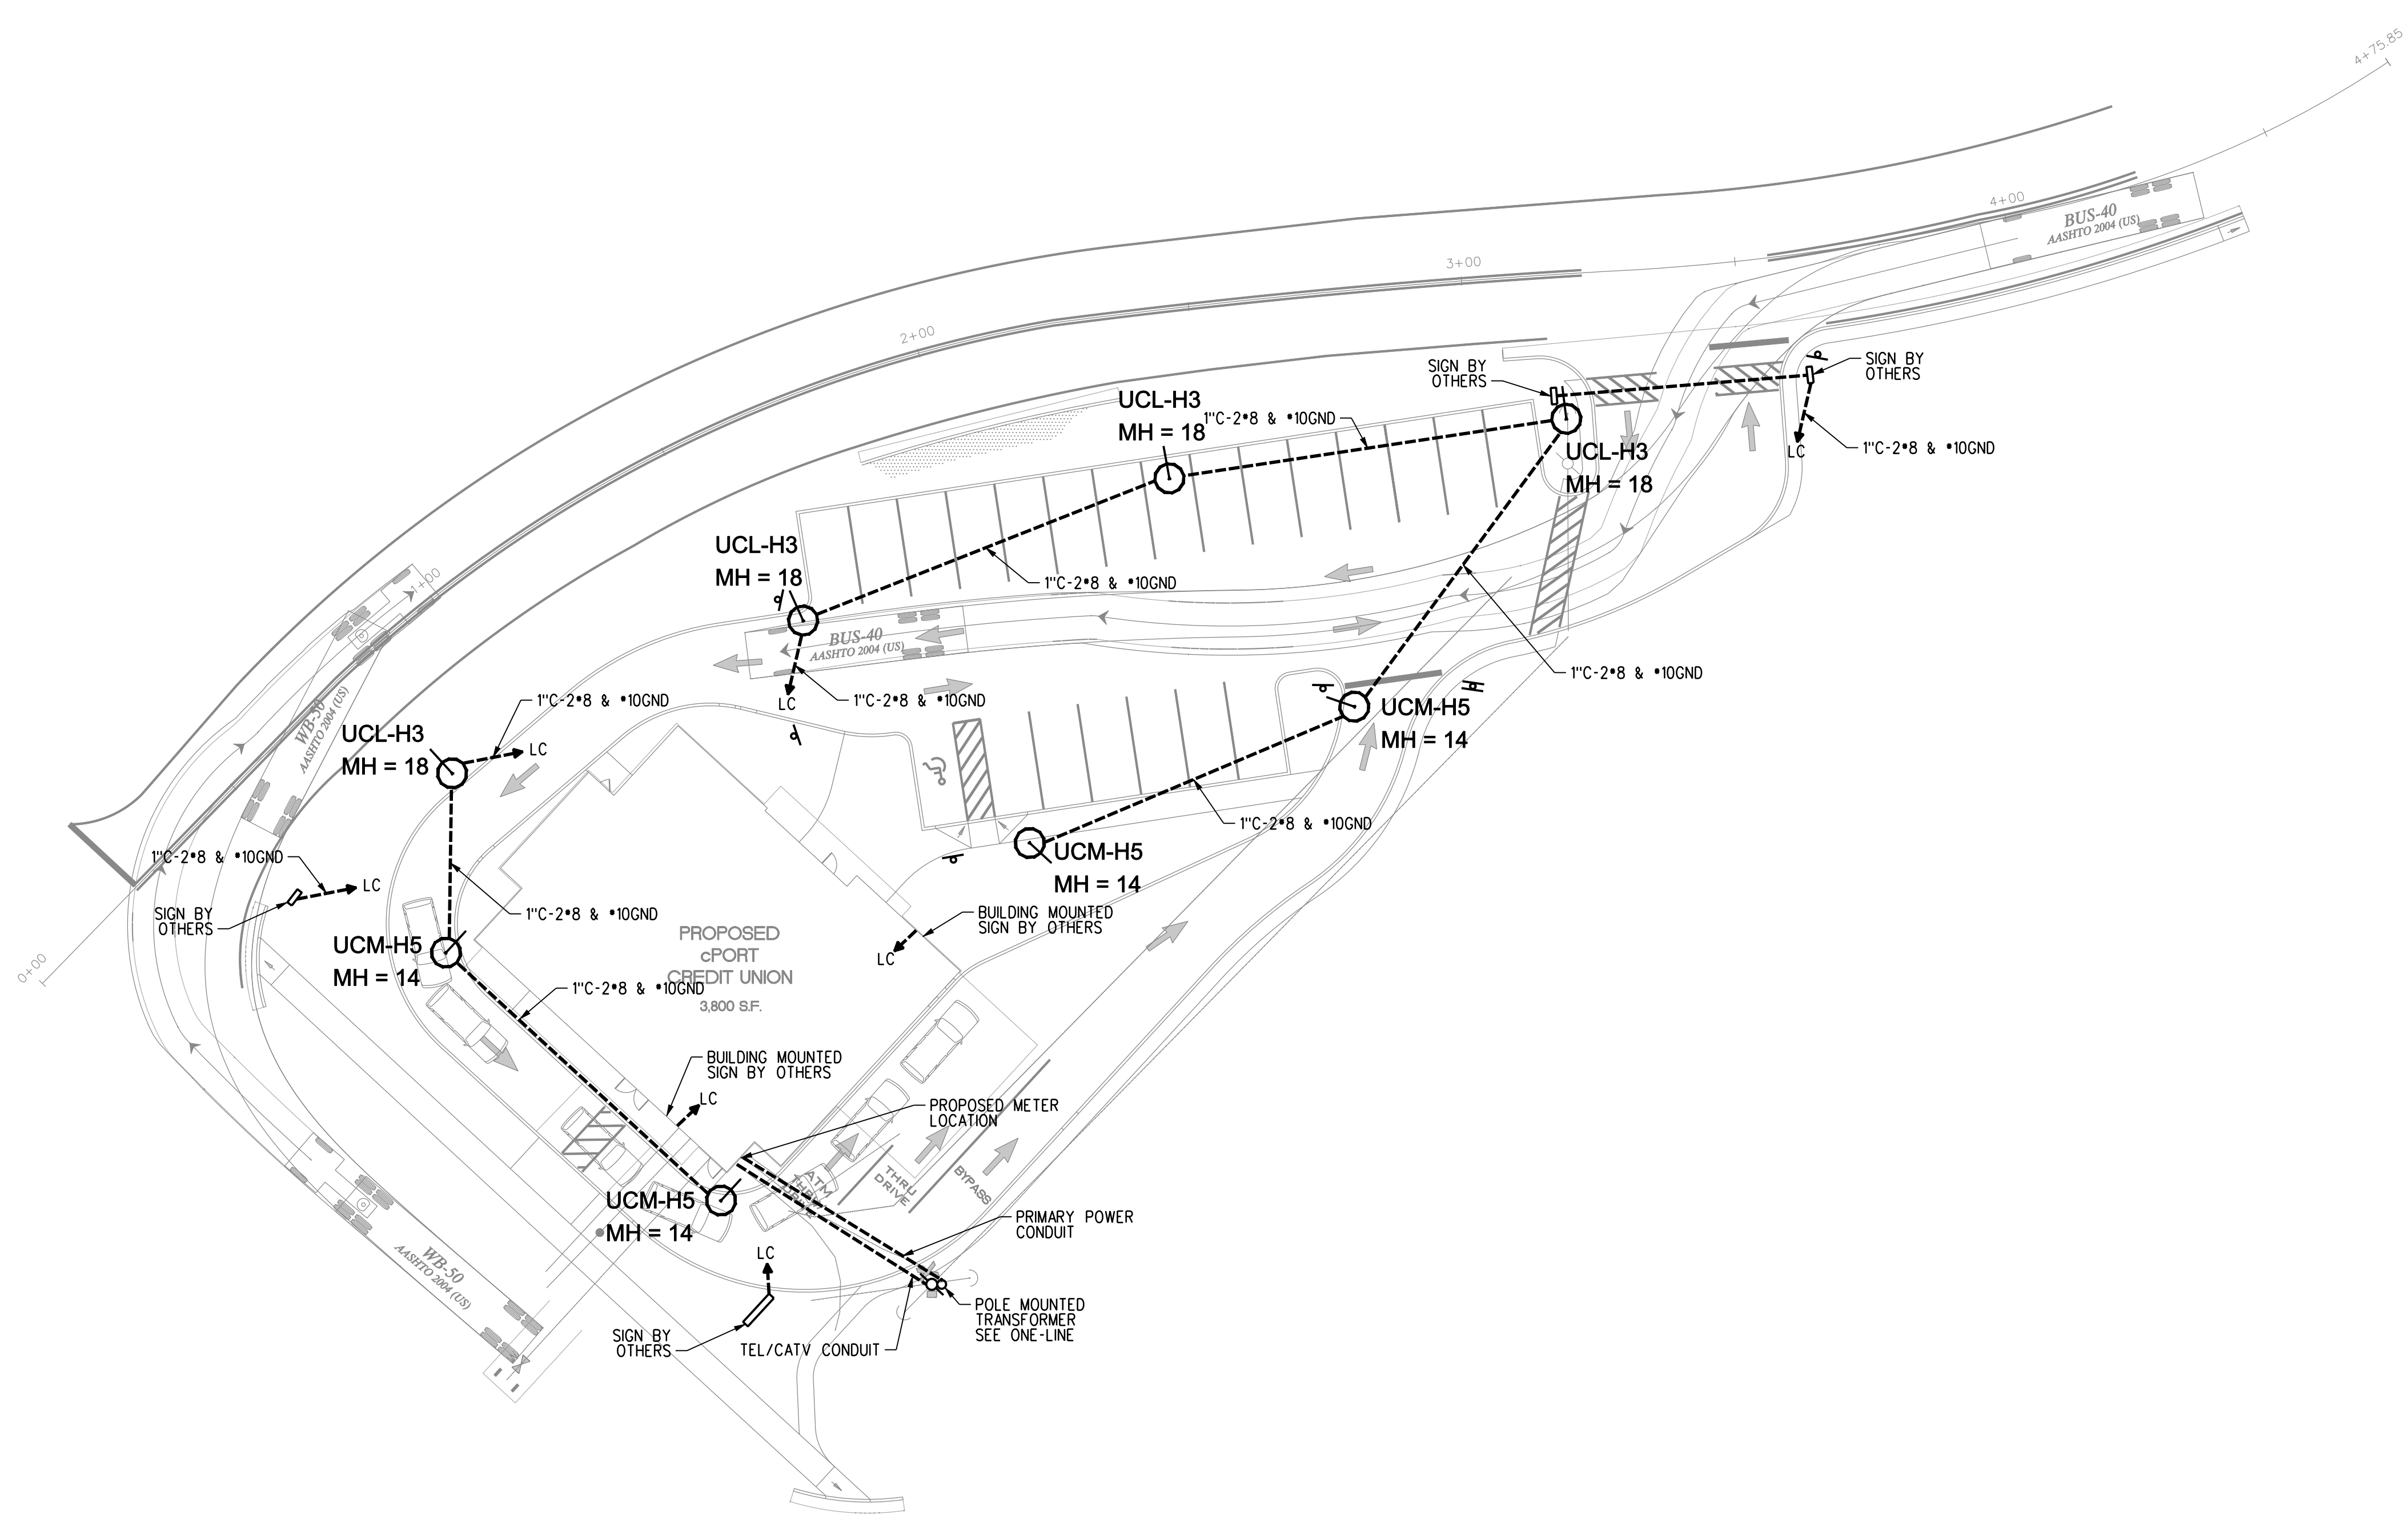

SITE PLAN
SCALE: 1"=20'

Light Fixture Schedule			
Symbol	Label	Arrangement	Notes
⊙	UCL-H3	SINGLE	
⊙	UCM-H5	SINGLE	

