


PROGRESS PRINT  
NOT FOR CONSTRUCTION

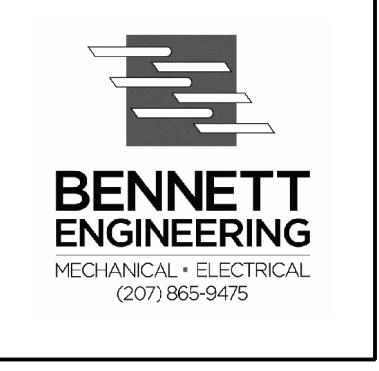


REVISIONS		
#	DATE	DESCRIPTION
1	8/19/11	Revised 90% Review Set

DATE:	08.19.11
PROJECT #:	090609
DRAWN BY:	twg
CHECKED BY:	....
DRAWING SCALE:	1/4"=1'-0"

SHEET TITLE  
FIRST FLOOR LIGHTING PLAN

E200

© COPYRIGHT 1985-2011  
REPRODUCTION OR SALE OF THIS  
DOCUMENT WITHOUT WRITTEN  
PERMISSION OF GAWRON TURGEON  
ARCHITECTS IS PROHIBITED.

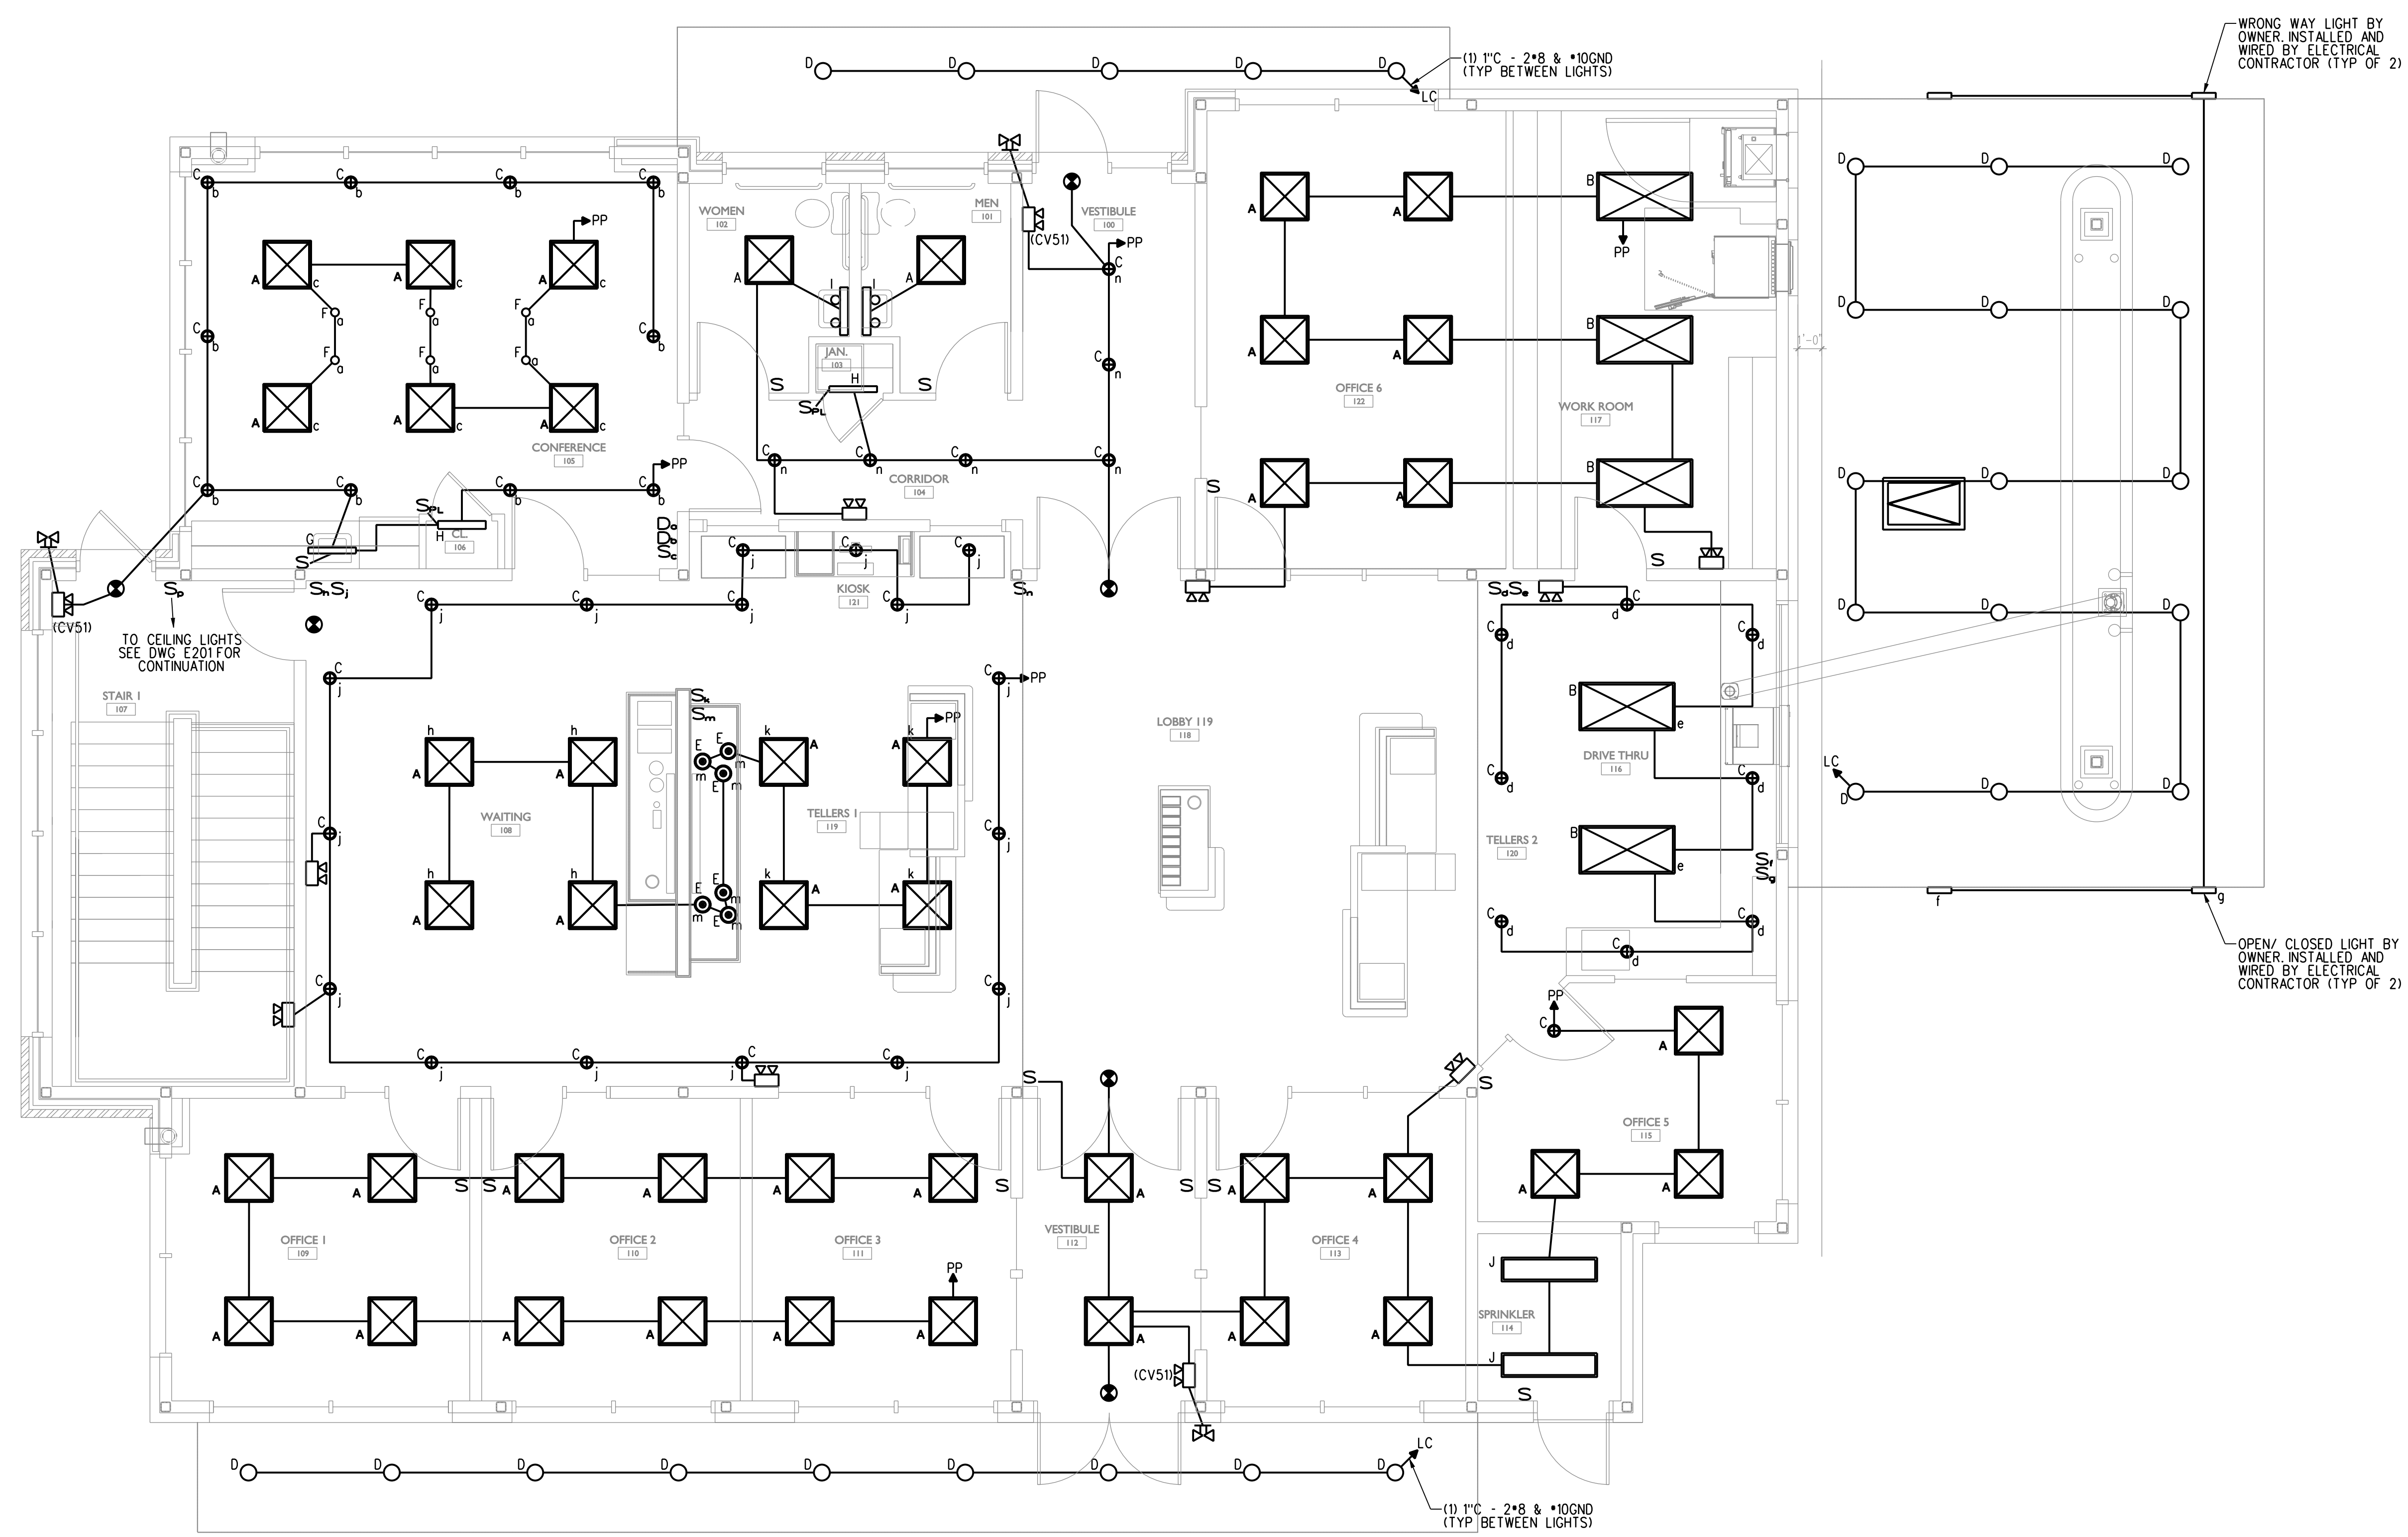

Grid lines: 1, 2, 3, 4, 5, 6, 7, 8, 9, 10, 11, 12, 13, 14, 15, 16, 17, 18, 19, 20

Vertical grid lines: A, B, C, D, E, F, G, H, J, K

Horizontal grid lines: 1, 2, 3, 4, 5, 6, 7, 8, 9, 10, 11, 12, 13, 14, 15, 16, 17, 18, 19, 20